

ABBREVIATIONS			PLUMBING SYMBOLS			CONNECTION TO EXISTING PLUMBING SYSTEMS			PLUMBING GENERAL NOTES			PLUMBING SHEET INDEX		
Ø	ROUND			2"	NOMINAL PIPE SIZE	A	INSTALLATION OF WORK AND NEW CONNECTION TO EXISTING PLUMBING LINES SHALL BE MADE AT TIME WHICH WILL NOT INTERFERE OR INTERRUPT THE NORMAL BUILDING OPERATION.		A	ALL WORK SHALL BE DONE IN ACCORDANCE WITH THE CURRENT EDITION OF ALL APPLICABLE CODES LOCAL CODES AS APPLIED BY THE AUTHORITY HAVING JURISDICTION.		P-010.00	PLUMBING - DEMOLITION PLAN	MARIN ARCHITECTS 57W 38TH ST LV1 10 NEW YORK NY 10018 212 463 8480 INFO@MARINARCHITECTS.COM Contractor CTS Builders Structural Engineer Penn Fusion Engineering MEP Engineering Wolf Engineering
ABV	ABOVE			1/8" / 12° SLOPE	BELOW ASSOCIATED LEVEL PIPING	B	FIELD VERIFY ALL NEW WATER, WASTE, AND VENT PIPING CONNECTIONS AND PROVIDE NEW CONNECTIONS AS REQUIRED FOR PROPERLY OPERATING SYSTEMS.		B	DO NOT SCALE DRAWINGS. VERIFY DIMENSIONS IN FIELD PRIOR TO COMMENCEMENT OF WORK. THE DRAWINGS ARE DIAGRAMMATIC AND INDICATE GENERAL LAYOUT OF PLUMBING SYSTEMS.		P-020.00	PLUMBING - SITE PLAN	
AC	AIR CONDITIONING			(E)	EXISTING PIPE TO REMAIN	C	CONTRACTOR SHALL BE RESPONSIBLE TO VERIFY THE LOCATION OF EXISTING BELOW GRADE WASTE PIPING AND REFLECT ANY DEVIATION GREATER THAN 1'-0" FROM THIS PLAN ON THE AS-BUILT DRAWINGS.		C	CONTRACTOR SHALL REVIEW ARCHITECTURAL, STRUCTURAL, MECHANICAL AND OTHER DRAWINGS PRIOR TO BID AND SHALL COORDINATE ALL TRADES TO PROVIDE A COMPLETE PRODUCT TO AVOID CONFLICTS BETWEEN THE TRADES, AND TO DETERMINE WHICH TRADE IS TO PERFORM THE NECESSARY WORK. RESOLVE ALL QUESTIONS OR CONFLICTS WITH THE ENGINEER BEFORE ANY EQUIPMENT IS ORDERED. MATERIALS FABRICATED OR SYSTEMS INSTALLED. CONSULT THE ARCHITECT'S DRAWINGS FOR ALL GRADE AND FINISH FLOOR ELEVATIONS.		P-100.00	PLUMBING - FLOOR PLANS - DWG	
AD	AREA DRAIN			CW	DOMESTIC COLD WATER	D	EXACT LOCATIONS, SIZE, AND ELEVATION OF EXISTING PIPING SHALL BE FIELD VERIFIED BEFORE START OF ANY WORK. ACTUAL FIELD CONDITIONS MAY REQUIRE ADJUSTMENT OR MODIFICATION TO PROPOSED ROUGHING, LAYOUT, AND ROUTING OF PIPING, INCLUDING POINT OF CONNECTION TO EXISTING WORK OF ADEQUATE SIZE TO ACCOMMODATE NEW WORK.		D	COORDINATE WITH MECHANICAL AND ELECTRICAL CONTRACTORS TO ENSURE PROPER CLEARANCE ABOVE ELECTRICAL SWITCHBOARDS, SWITCHGEAR, PANELBOARD, AND MOTOR CONTROL CENTERS WHERE REQUIRED.		P-200.00	PLUMBING - FLOOR PLANS - DOMESTIC WATER	
ADD	ADDENDUM			NFW	HARD COLD WATER	E	ALL FIXTURES SHALL BE PROTECTED DURING CONSTRUCTION FROM ANY DAMAGE. REFINISHED FIXTURES WILL NOT BE ACCEPTABLE UNDER ANY CONDITIONS.		E	CONTRACTOR SHALL GUARANTEE THE INSTALLATION AGAINST DEFECTS IN MATERIALS AND WORKMANSHIP WHICH MAY OCCUR UNDER NORMAL USAGE FOR A PERIOD OF ONE YEAR AFTER OWNER'S ACCEPTANCE. DEFECTS SHALL BE PROMPTLY REMEDIED WITHOUT COST TO THE OWNER.		P-201.01	PLUMBING - ENLARGED PLAN	
AF	ABOVE FINISHED FLOOR			HW	HOT WATER	F	PROVIDE NECESSARY ADJUSTMENT OF NEW INSTALLATION DUE TO INTERFERENCE WITH BUILDING CONDITIONS, INCLUDING WORK OF OTHER TRADES.		F	CONTRACTOR SHALL SECURE AND PAY FOR ALL PERMITS, FEES, INSPECTION AND TESTS. CONTRACTOR SHALL OBTAIN PERMIT AND APPROVED SUBMITTALS PRIOR TO COMMENCEMENT OF WORK OR ORDERING EQUIPMENT. PLUMBING CONTRACTOR SHALL BE PRESENT FOR ALL INSPECTIONS OF HIS WORK BY REGULATORY AUTHORITIES.		P-201.02	PLUMBING - ROOF PLAN	
AFUE	ANNUAL FUEL UTILIZATION EFFICIENCY			HW 140°	HOT WATER 140°	G	PIPING MATERIAL, VALVES, PIPE SUPPORTS, PIPE COVERING, ETC. USED IN THE INSTALLATION OF WORK OF THIS CONTRACT SHALL BE NEW AND SHALL MATCH EXISTING, PROVIDING SAME MEETS ALL APPLICABLE BUILDING AND PLUMBING CODES.		G	CONTRACTOR SHALL PROVIDE RECORD DRAWINGS TO THE BUILDING OWNER AND ARCHITECT. DRAWINGS SHALL INCLUDE ALL ADDENDUM ITEMS, CHANGE ORDERS, ALTERATIONS, REROUTING, ETC.		P-501.00	PLUMBING LEGEND, SYMBOLS, AND ABBREVIATIONS	
ALT	ALTERNATE			HW-R	HOT WATER RECIRCULATION	H	PROVIDE NEW PLUMBING ROUGHING WITH CONNECTIONS NECESSARY OR REQUIRED FOR PROPER FUNCTION OF PLUMBING EQUIPMENT.		H	CONTRACTOR SHALL PROVIDE INSURANCE FOR PROTECTION AGAINST PUBLIC LIABILITY AND PROPERTY DAMAGE FOR THE DURATION OF THE WORK.		P-002.00	PLUMBING SPECIFICATIONS	
AP	ACCESS PANEL			HW-R 140°	HOT WATER RECIRCULATION 140°	I	EXISTING PIPING SHALL BE MODIFIED AND/OR REMOVED TO POINT THAT WOULD ACCOMMODATE CONNECTION OF NEW (WATER AND WASTE) PLUMBING ROUGHING.		I	CONTRACTOR SHALL PROVIDE SHOP DRAWINGS FOR ALL EQUIPMENT AT ONE TIME, INDEXED IN A NEAT AND ORDERLY MANNER. PARTIAL SUBMITTALS WILL NOT BE ACCEPTED. PLUMBING CONTRACTOR SHALL NOT ORDER ANY EQUIPMENT WITHOUT APPROVAL FROM PLUMBING ENGINEER, ARCHITECT, OWNER, AND INTERIOR DESIGNER (IF APPLICABLE).		P-003.00	PLUMBING SPECIFICATIONS	
ARCH	ARCHITECT/ARCHITECTURAL			SS	SANITARY SEWER	J	ROUTING OF NEW PIPING AND POINT OF CONNECTION TO EXISTING PIPING IS BASED ON ASSUMPTION THAT PIPING IS AT LOCATION SHOWN ON PLAN.		J	CONTRACTOR SHALL PROVIDE ACCESS PANELS FOR ALL CONCEALED VALVES, ACCESS PANELS IN RATED WALLS OR CEILINGS MUST MAINTAIN THE SAME RATING AND MUST MATCH THE FINISH OF THE WALL OR CEILING IN WHICH IS INSTALLED.		P-601.00	PLUMBING DETAILS	
BFF	BELOW FINISHED FLOOR			WV	SANITARY WET VENT	K	PROVIDE NECESSARY TEST TO DETERMINE TIGHTNESS OF EXISTING AND NEW PLUMBING PIPING SYSTEMS. ALL LEAKS AND OPEN OUTLETS FOUND DURING TEST SHALL BE REPAIRED, CAPPED OR PLUGGED, PERFORM ADDITIONAL TEST UNTIL IT IS DETERMINED THAT THE PLUMBING PIPING SYSTEMS IS WATER TIGHT.		K	TRENCHING, BACKFILL AND CONCRETE WORK ASSOCIATED WITH PLUMBING SHALL BE PERFORMED IN ACCORDANCE WITH THE APPLICABLE SPECIFICATIONS.		P-701.00	PLUMBING - RISER DIAGRAM	
BLW	BELOW			CVW	COMBINATION WASTE & VENT	L	CAP AND PLUG OF INACTIVE SANITARY PIPING SHALL BE TO POINT OF CONNECTIONS TO ACTIVE LINES. NO DEAD END SHALL BE PROVIDED.		L	LAYOUT PIPES TO FALL (CONCEALED) WITHIN PARTITION WALL OR CHASES. NOTIFY ARCHITECT IF ADDITIONAL WALL SPACE IS REQUIRED. COORDINATE PIPE DROP WITH FOOTINGS, STRUCTURAL STEEL, FIRE RATED WALLS, WHICH MAY FALL BELOW PARTITION WALL OR CHASE. MAKE NECESSARY ADJUSTMENT TO PIPING TO AVOID CONFLICT WITH BUILDING OBSTRUCTIONS. CONSULT WITH ARCHITECT AND CONTRACT DOCUMENTS FOR LOCATION OF ALL RATED WALLS, CEILINGS, FLOORS AND ROOF. FURNISH AND INSTALL APPROPRIATE AND APPROVED FIRE BARRIER AT ALL PENETRATIONS. INSTALLATION SHALL BE PER MANUFACTURES SPECIFICATIONS.				
BTU	BRITISH THERMAL UNITS			CD	CONDENSATE DRAINAGE	M	ALL OPENINGS, HOLES, ETC; MADE FOR THE REMOVAL OF PLUMBING PIPING, FIXTURES, ETC; SHALL BE PATCHED WITH MATERIAL TO MATCH EXISTING.		M	CONTRACTOR SHALL PROVIDE PIPE HANGERS FOR ALL PIPING. HANGER RODS AND DEVICES SHALL BE USED FOR SUPPORT OF ALL PIPING. MAKESHIFT DEVICES WILL NOT BE ACCEPTABLE. HANGER DEVICES SHALL BE SIZED TO FIT AROUND INSULATION. PROVIDE GALVANIZED STEEL SADDLES AS REQUIRED. PIPING SUPPORT SPACING SHALL COMPLY WITH LOCAL CODE REQUIREMENTS. NON-METALLIC PIPES SHALL BE PADDED WITH 1/8" THICK RUBBER, NEOPRENE, OR SOFT RESILIENT CLOTH.				
BTUH	BRITISH THERMAL UNITS PER HOUR			ID	INDIRECT WASTE	N	IF FIELD CONDITION FINDS THAT EXISTING SANITARY, VENT, AND DOMESTIC WATER LINES CAN BE UTILIZED, CONNECT NEW SANITARY, VENT, AND DOMESTIC WATER LINES TO EXISTING. MAKE NECESSARY ADJUSTMENTS TO ACCOMMODATE NEW SANITARY, VENT AND DOMESTIC WATER LINES.		N	SANITARY, VENT PIPING AND DOMESTIC WATER PIPING SHALL BE TESTED IN ACCORDANCE WITH LOCAL PLUMBING CODE.				
CAP	CAPACITY			S/O	BALL VALVE	O	OVERFLOW ROOF DRAIN		O	DIELECTRIC COUPLINGS ARE REQUIRED BETWEEN ALL DISSIMILAR METAL IN PIPING AND EQUIPMENT CONNECTIONS.				
CB	CATCH BASIN			S/T	SIPHONIC PRIMARY	ORD	OVERFLOW ROOF DRAIN		P	PITCH UNDERFLOOR SANITARY WASTE PIPING AT 1/4" PER FOOT, UNLESS NOTED OTHERWISE.				
CFM	CUBIC FEET PER MINUTE			ST SEC	SIPHONIC SECONDARY	PD	PRESSURE DROP		Q	WASTE AND VENT PIPING BELOW FLOOR AND THROUGH FLOOR SHALL BE 2" MINIMUM.				
CLG	CEILING			CA	COMPRESSED AIR	PBG	PLUMBING		R	PROVIDE CLEANOUTS IN ACCESSIBLE LOCATION AT THE BASE OF ALL PLUMBING RISERS. CLEANOUTS SHALL BE INSTALLED PER CODE REQUIREMENTS.				
CO	CLEAN OUT			G	NATURAL GAS	PRESS	PRESSURE		S	FIELD VERIFY LOCATION AND INVERTS OF SITE UTILITIES PRIOR TO INSTALLATION.				
CW	COLD WATER			G	PROPANE GAS	PRV	PRESSURE REDUCING VALVE		T	ROUTE DOMESTIC WATER, SANITARY SEWER, AND STORM SEWER SERVICES TO SITE UTILITIES 5'-0" FROM BUILDING UNLESS NOTED OTHERWISE. REFER TO CIVIL PLANS.				
D	DEGREE			LP	PIPE RISE / DROP	PSI	POUNDS PER SQUARE INCH		U	ALL VENTS THRU ROOF SHALL BE MINIMUM OF TEN FEET FROM ANY FRESH AIR INTAKE.				
DB	DRY BULB		PIPE ACCESSORY NOTES			PWR	POWER		V	PENETRATIONS OF RATED ASSEMBLIES SHALL BE FIRE STOPPED. FIRE STOPPING SHALL BE AN APPROVED MATERIAL AS PRESCRIBED IN STATE. FIRE MARSHALL AND SHALL BE U.L. LISTED.				
DIA	DIAMETER			4" FCO	CLEAN OUT	RD	ROOF DRAIN		W	PROVIDE FLASHING AND/OR COUNTER FLASHING OF ALL EXTERIOR PENETRATIONS.				
DBP	DOMESTIC WATER BOOSTER PUMP			2" SW	SWING CHECK	REC	RECESSED		X	HANDICAPPED USE PLUMBING FIXTURES SHALL BE MOUNTED AT REQUIRED HEIGHTS AND WITH ALL RELATED ACCESSORIES AS REQUIRED BY THE ADMINISTRATIVE AUTHORITIES.				
DCP	DOMESTIC WATER CIRCULATING PUMP			2" CH	CHECK VALVE	RED	REDUCER		Y	PITCH UNDERFLOOR STORM PIPING 3" AND GREATER AT 1/8" PER FOOT, UNLESS NOTED OTHERWISE. PITCH ALL OTHER STORM PIPING AT 1/4" PER FOOT UNLESS OTHERWISE NOTED.				
DN	DOWN			2" CH	ALTERNATE CHECK VALVE	RM	ROOM							
DW	DISTILLED WATER			2" BAL	BALANCING VALVE	RPM	REVOLUTIONS PER MINUTE							
EA	EACH			2" CIRC	CIRCUIT SETTER	RW	RAIN WATER							
EAT	ENTERING AIR TEMPERATURE			2" GATE	GATE VALVE	SF	SQUARE FOOT							
ELEC	ELECTRICAL			2" QOV	QUICK OPENING VALVE	S/A	SUPPLY AIR							
EQUIP	EQUIPMENT			1" S/O	BALL VALVE	SAN	SANITARY							
EW	ENTERING WATER TEMPERATURE			2" S/T	FLUID STRAINER	SF	SQUARE FOOT							
EWT	ENTERING WATER TEMPERATURE			1" GAS-CNTRL	EMERGENCY GAS SHUTOFF	SM	SURFACE MOUNT							
E/A	EXHAUST AIR			1" PLUG	PLUG VALVE	SP	STANDPIPE							
EXIST	EXISTING			1" GAS COCK	GAS SHUTOFF COCK	S/P	SUMP PUMP							
ET	EXPANSION TANK			1" REG	GAS REGULATOR	STM	STEAM							
FAH	DEGREES FAHRENHEIT			1" TRAP PRIMER	TRAP PRIMER	TD	TRENCH DRAIN							
FCO	FLOOR CLEAN OUT			2" ELEC-CNTRL	ELEC. CONTROL VALVE	TEMP	TEMPERATURE							
FD	FLOOR DRAIN			1" MIXV-T/P	MIXING VALVE	TYP	TYPICAL							
FDC	FIRE DEPARTMENT CONNECTION			1" EMV-EM	EMERGENCY MIXER	UG	UNDERGROUND							
FL	FLOOR			2" PRV	PRESSURE REDUCING VALVE	VAC	VACUUM							
FP	FIRE PUMP			2" METER	WATER METER	V	VENT							
FPM	FEET PER MINUTE			1 1/2" METER	IRRIGATION METER	VTR	VENT THROUGH ROOF							
FS	FLOOR SINK				DOUBLE CHECK VALVE	W	WASTE							
FT	FOOT/FEET				REDUCED PRESSURE ZONE	WCO	WALL CLEAN OUT							
GAL	GALLON		PLUMBING FUTURE NOTES			WH	WALL HYDRANT							
GPM	GALLONS PER MINUTE				DESIGN SIZE									
GF	GAS-FIRED				IDENTITY TYPE									
GC	GENERAL CONTRACTOR			2" FD-3	FLOOR DRAIN W/ DEEP SEAL TRAP									
GREASE	GREASE INTERCEPTOR			3" AD-1	AREA DRAIN (NO TRAP)									
GI	GREASE WASTE			6" DD-1	DECK DRAIN									
HB	HOSE BIB			3" HD-1	HUB DRAIN (FUNNEL TYPE)									
HP	HORSE POWER			3" FS-4	FLOOR SINK									
HTG	HEATING			8" SD-12	STORM DRAIN									
HTR	HEATER			6" SD-1	COMBINATION DRAIN									
HW	HOT WATER			2000 SF	RAINFALL SURFACE AREA									
HYD	HYDRANT		GENERAL PLAN SYMBOLS											
ID	INDIRECT			#	DETAIL NUMBER ON SHEET									
IN	INCH			P-#	SHEET NUMBER WHERE DETAIL IS PLACED									
INV	INVERT			#	KEYNOTE SYMBOL									
LP	LOW PRESSURE			?	CONTINUATION SYMBOL									
LWT	LEAVING WATER TEMPERATURE			●	POINT WHERE NEW CONNECTS TO EXISTING									
MAX	MAXIMUM			ROOM 001	ROOM NAME / NUMBER									
MBH	ONE THOUSAND BTU PER HOUR				AREA BEING DEMOUSHED									
MD	MOTORIZED DAMPER				AREA NOT IN CONTRACT									
MECH	MECHANICAL													
MFR	MANUFACTURER													
MIN	MINIMUM													
MISC	MISCELLANEOUS													
MTR	MOTOR													
NIC	NOT IN CONTRACT													
NO	NUMBER													
NTS	NOT TO SCALE													
O	OXYGEN													
ORD	OVERFLOW ROOF DRAIN													
PD	PRESSURE DROP													
PBG	POST INDICATOR VALVE													
PBG	PLUMBING													
PRESS	PRESSURE													
PRV	PRESSURE REDUCING VALVE													
PSI	POUNDS PER SQUARE INCH													
PWR	POWER													
RD	ROOF DRAIN													
REC	RECESSED													
RED	REDUCER													
RM	ROOM													
RPM	REVOLUTIONS PER MINUTE													
RW	RAIN WATER													
SF	SQUARE FOOT													
S/A	SUPPLY AIR													
SAN	SANITARY													
SF	SQUARE FOOT													
SM	SURFACE MOUNT													
SP	STANDPIPE													
S/P	SUMP PUMP													
STM	STEAM													
TD	TRENCH DRAIN													
TEMP	TEMPERATURE													
TYP	TYPICAL													
UG	UNDERGROUND													
VAC	VACUUM													
V	VENT													
VTR	VENT THROUGH ROOF													
W	WASTE													
WCO	WALL CLEAN OUT													
WH	WALL HYDRANT													

PROJECT NAME:

US FOODS MEZZANINE RENOVATION

PROJECT ADDRESS:

40 S FORT LEWIS BLVD
SALEM, VA 24153

DWG TITLE:

PLUMBING LEGEND, SYMBOLS, AND ABBREVIATIONS

SEAL

DATE: 9/2/2025 2:38:22 PM

PROJECT No: 20250189.0


DRAWING BY: BG

CHK'D BY: EW

DWG No:

P-001.00

9/02/2025

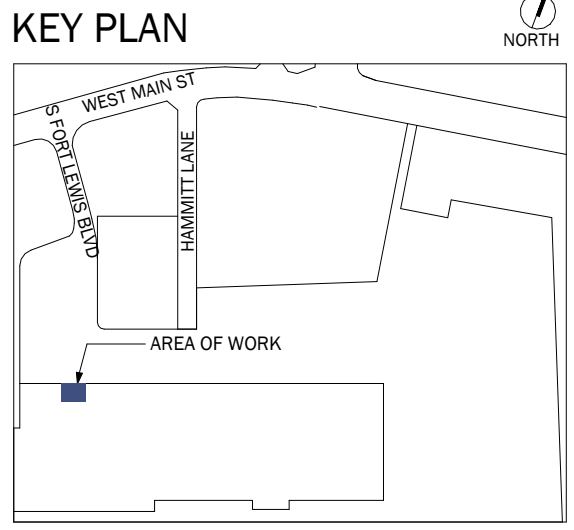

CLIENT:

PROJECT NAME:


US FOODS
MEZZANINE RENOVATION

PROJECT ADDRESS:

40 S FORT LEWIS BLVD
SALEM, VA 24153

DWG TITLE:

PLUMBING - DEMOLITION PLAN

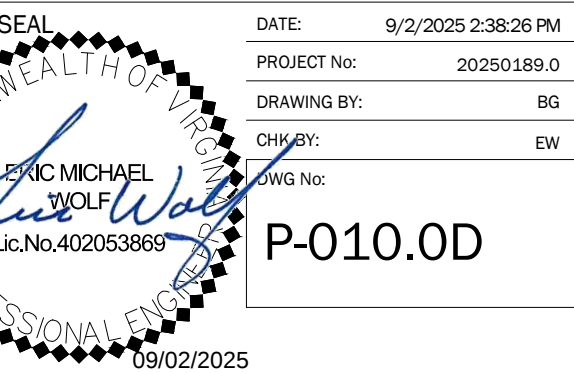


GENERAL NOTES


- IT IS THE RESPONSIBILITY OF THE GENERAL AND PLUMBING CONTRACTOR TO FULLY INSPECT THE SITE PRIOR TO COMMENCEMENT.
- VERIFY ALL EXISTING CONDITIONS INCLUDING LOCATION OF ALL STRUCTURAL ELEMENTS, BAR JOISTS, COLUMNS, ETC. AND COORDINATE PIPING SYSTEMS AND LOCATIONS ACCORDINGLY.

KEY NOTES

- DEMOLISH ALL ASSOCIATED PIPING AND ASSOCIATED APPARATUS BACK TO SOURCE.
- EXISTING SANITARY SEWER PIPING TO BE RELOCATED TO UNDER NEW MEZZANINE LEVEL AS REQUIRED. ALL STORM WATER PIPING SHALL SLOPE AT 1/4" PER FOOT. EXTEND AND MODIFY PIPING AND ASSOCIATED APPARATUS AS REQUIRED. COORDINATE EXACT LOCATION IN THE FIELD.
- EXISTING STORM WATER PIPING TO BE RELOCATED UNDER NEW MEZZANINE LEVEL AS REQUIRED. ALL STORM WATER PIPING SHALL BE INSTALLED SUCH THAT THE SLOPE IS 1/4" PER FOOT. COORDINATE EXACT LOCATION IN THE FIELD, AND MODIFY PIPING AND ASSOCIATED APPARATUS AS REQUIRED.
- EXISTING DOMESTIC WATER/SANITARY SEWER TO RESTROOMS OUT OF SCOPE.
- DEMOLISH FIXTURES, EXISTING DOMESTIC WATER SUPPLY PIPING AND SANITARY SEWER PIPING TO SERVE NEW FIXTURES DURING NEW WORK.

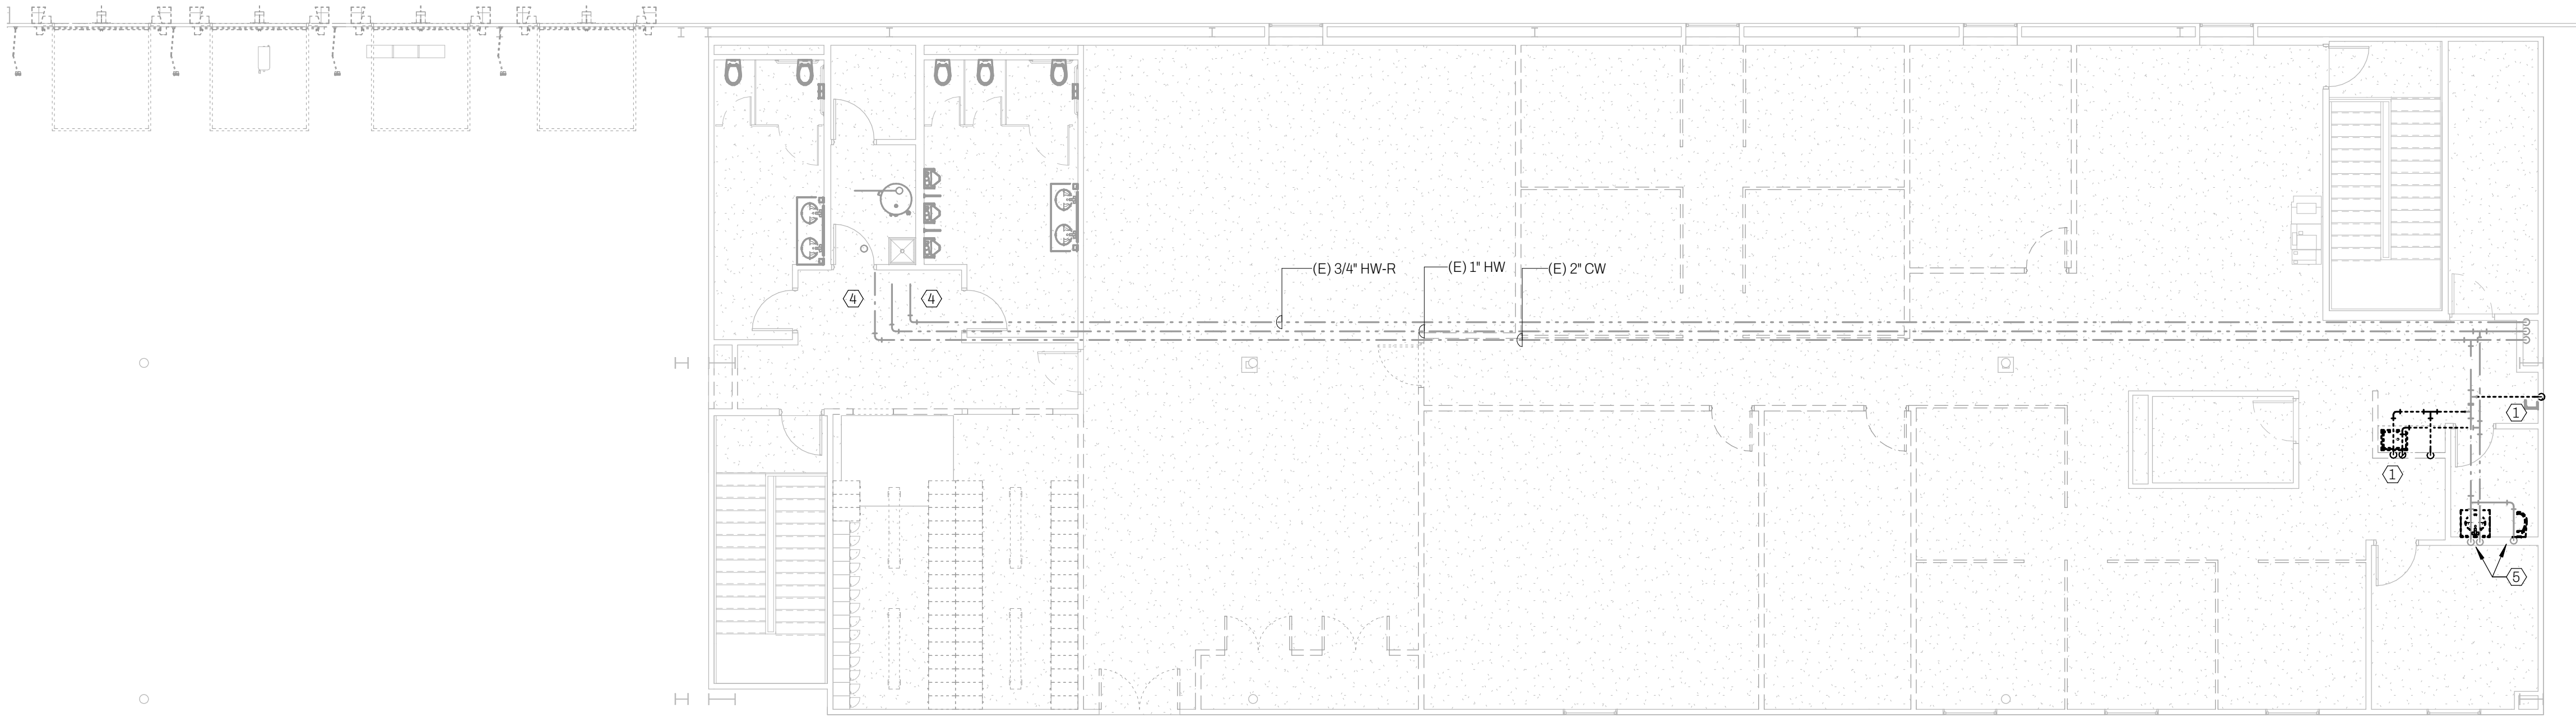

2 PLUMBING - MEZZANINE PLAN - DEMOLITION
P-010.0D 1/8" = 1'-0"

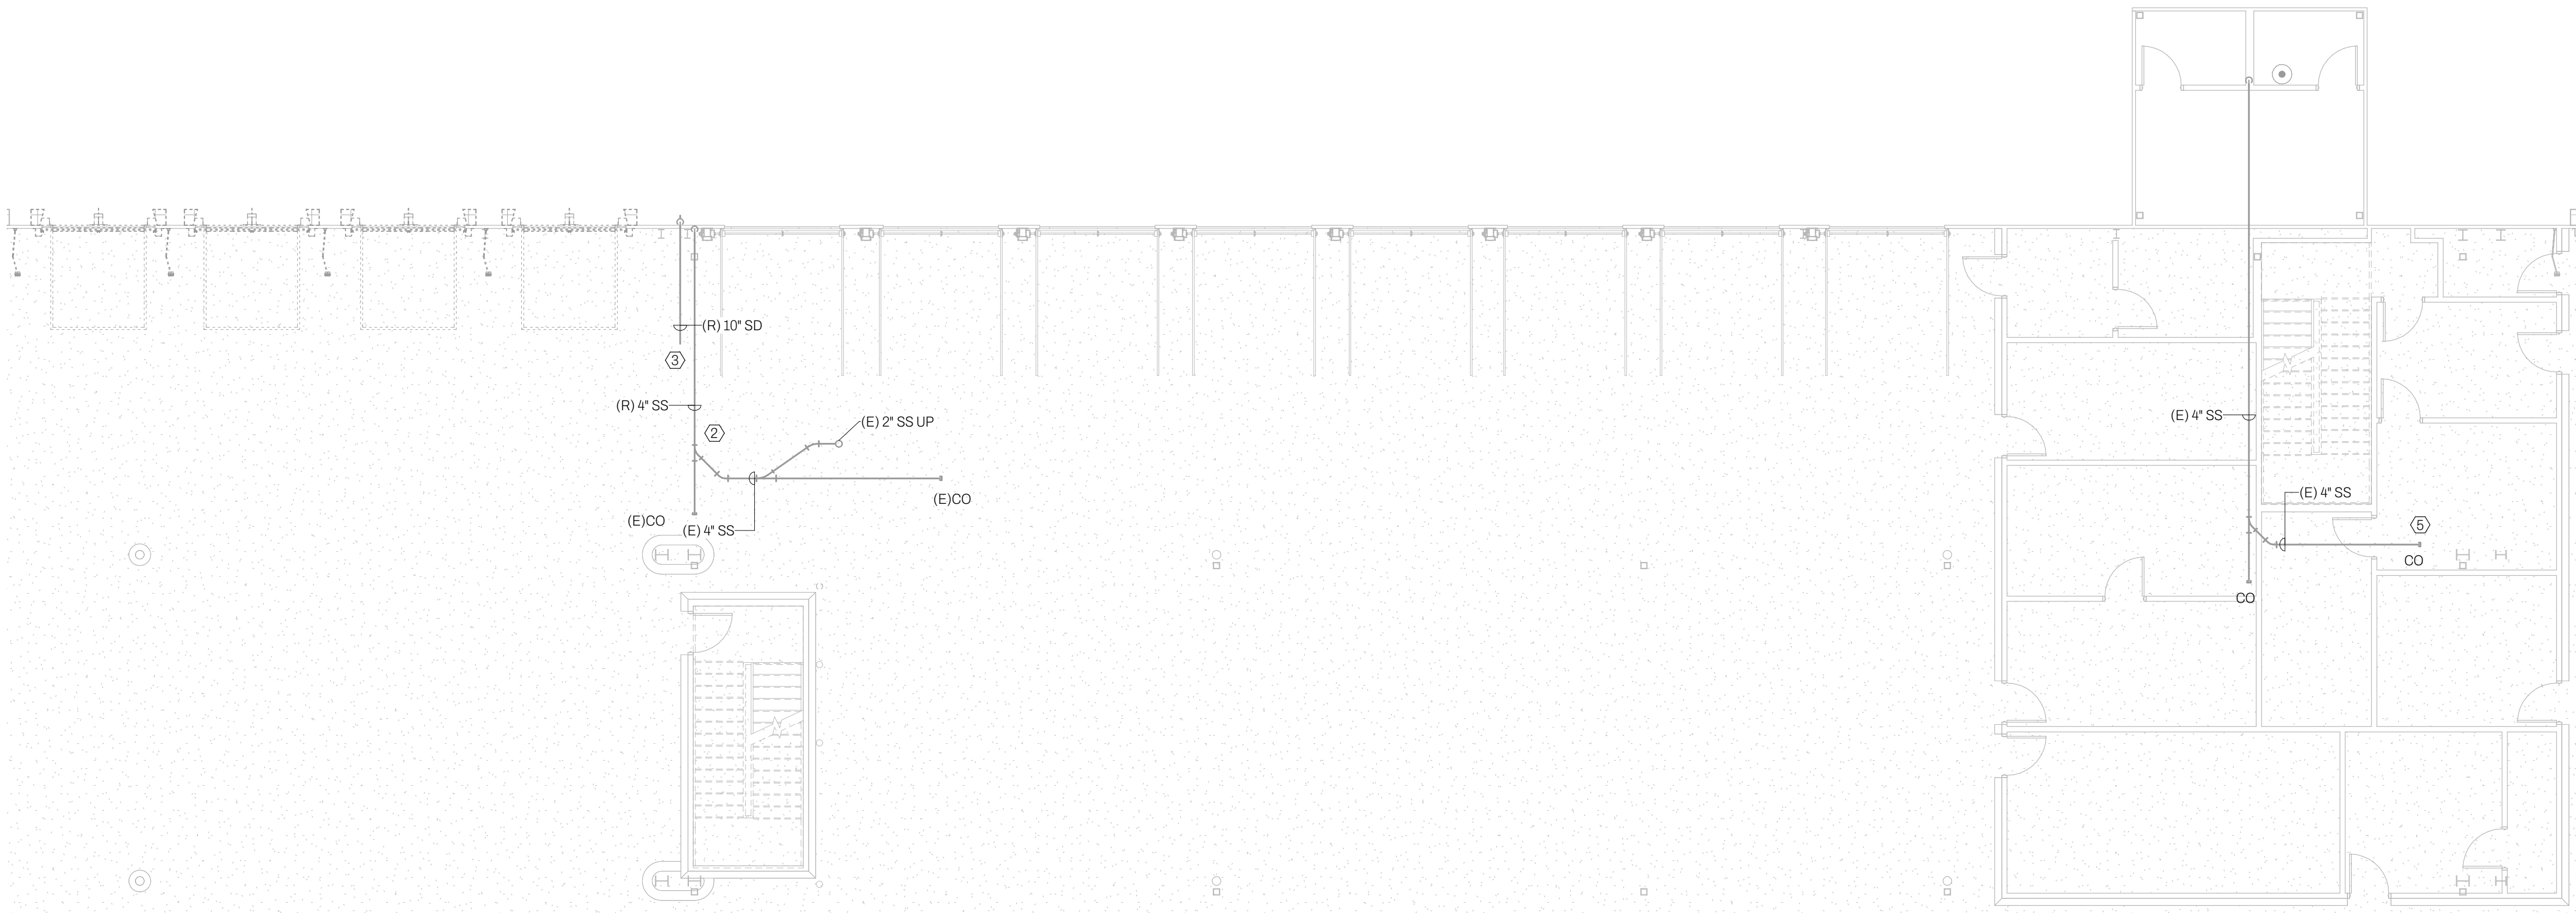

1 PLUMBING - GROUND FLOOR - DEMOLITION
P-010.0D 1/8" = 1'-0"

- A. IT IS THE RESPONSIBILITY OF THE GENERAL AND PLUMBING CONTRACTOR TO FULLY INSPECT THE SITE PRIOR TO COMMENCEMENT.
- B. VERIFY ALL EXISTING CONDITIONS INCLUDING LOCATION OF ALL STRUCTURAL ELEMENTS, BAR JOISTS, COLUMNS, ETC. AND COORDINATE PIPING SYSTEMS AND LOCATIONS ACCORDINGLY.

- A. IT IS THE RESPONSIBILITY OF THE GENERAL AND PLUMBING CONTRACTOR TO FULLY INSPECT THE SITE PRIOR TO COMMENCEMENT.
- B. VERIFY ALL EXISTING CONDITIONS INCLUDING LOCATION OF ALL STRUCTURAL ELEMENTS, BAR JOISTS, COLUMNS, ETC. AND COORDINATE PIPING SYSTEMS AND LOCATIONS ACCORDINGLY.

1. DEMOLISH ALL PLUMBING BACK TO SOURCE COMPLETE, INCLUDING ALL SANITARY SEWER AND VENT PIPING, DOMESTIC WATER PIPING, NATURAL GAS PIPING, AND ALL ASSOCIATED APPARATUS.
2. OUT OF SCOPE/NOT IN CONTRACT.
3. AREA OF SCOPE. REFER TO SHEETS WITHIN THIS SET FOR ADDITIONAL INFORMATION.

1. DEMOLISH ALL PLUMBING BACK TO SOURCE COMPLETE, INCLUDING ALL SANITARY SEWER AND VENT PIPING, DOMESTIC WATER PIPING, NATURAL GAS PIPING, AND ALL ASSOCIATED APPARATUS.
2. OUT OF SCOPE/NOT IN CONTRACT.
3. AREA OF SCOPE. REFER TO SHEETS WITHIN THIS SET FOR ADDITIONAL INFORMATION.

57W 38TH ST LVL 10 NEW YORK NY 10018
212 463 8480 INFO@MARINARCHITECTS.COM

Contractor
CTS Builders

Structural Engineer
Penn Fusion Engineering

MEP Engineering
Wolf Engineering

P.O. BOX 38 | DALTON, GA 30722

09/02/25		FILING SET
08/25/25		90% REVIEW
08/07/25		60% PROGRESS SET

NO COPIES, TRANSMISSIONS, REPRODUCTIONS, OR ELECTRONIC REVISIONS OF ANY PORTIONS OF THESE DRAWINGS IN WHOLE OR IN PART BE MADE WITHOUT THE EXPRESS WRITTEN PERMISSION OF MARIN ARCHITECTS. ALL DESIGNS INDICATED IN THESE DRAWINGS ARE PROPERTY OF MARIN ARCHITECTS. ALL COPYRIGHTS RESERVED © 2019.

CLIENT:

PROJECT NAME:

US FOODS

MEZZANINE RENOVATION

PROJECT ADDRESS:

40 S FORT LEWIS BLVD
SALEM, VA 24153

DWG TITLE:

PLUMBING - SITE PLAN

SEAL	DATE: 9/2/2025 2:38:27 PM
WEALTH OF VIRGINIA	PROJECT No: 20250189.0
ERIC MICHAEL WOLF	DRAWING BY: BG
<i>Eric Wolf</i>	CHK BY: EW
Lic.No.402053869	FWG No:
PROFESSIONAL ENGINEER	P-020.00
09/02/2025	

GENERAL NOTES

- A. IT IS THE RESPONSIBILITY OF THE GENERAL AND PLUMBING CONTRACTOR TO FULLY INSPECT THE SITE PRIOR TO COMMENCEMENT.
- B. VERIFY ALL EXISTING CONDITIONS INCLUDING LOCATION OF ALL STRUCTURAL ELEMENTS, BAR JOISTS, COLUMNS, ETC. AND COORDINATE PIPING SYSTEMS AND LOCATIONS ACCORDINGLY.
- C. REFER TO ENLARGED PLANS FOR ADDITIONAL INFORMATION.

KEY NOTES

1. RELOCATE SANITARY SEWER PIPING PLAN EAST OF MEZZANINE'S I-BEAM. FIELD COORDINATE EXACT LOCATION.
2. PROVIDE NEW 4" SANITARY SEWER PIPING TO SERVE MEZZANINE.
3. ROUTE NEW SANITARY AND GREASE WASTE PIPING TIGHT TO STRUCTURE ABOVE.
4. PROVIDE NEW 75GPM GREASE INTERCEPTOR SUSPENDED TIGHT TO STRUCTURE ABOVE. REFER TO SHEET P201.01 FOR ADDITIONAL INFORMATION.
5. EXISTING SANITARY SEWER AND VENT PIPING SERVING RESTROOMS OUT OF SCOPE.
6. LOCATE EXISTING SANITARY SEWER AND VENT PIPING. EXTEND AND MODIFY AS REQUIRED TO SERVE NEW FIXTURES.
7. FIXTURES OUT OF SCOPE/EXISTING TO REMAIN.

MARIN
ARCHITECTS

57W 38TH ST LVL 10 NEW YORK NY 10018
212 463 8480 INFO@MARINARCHITECTS.COM

Contractor
CTS Builders

Structural Engineer
Penn Fusion Engineering

MEP Engineering
Wolf Engineering


WOLF
ENGINEERING

P.O. BOX 38 | DALTON, GA 30722

09/02/25 FILING SET
08/25/25 90% REVIEW
08/07/25 60% PROGRESS SET

NO COPIES, TRANSMISSIONS, REPRODUCTIONS, OR ELECTRONIC REVISIONS OF ANY PORTIONS OF THESE DRAWINGS IN WHOLE OR IN PART BE MADE WITHOUT THE EXPRESS WRITTEN PERMISSION OF MARIN ARCHITECTS. ALL DESIGNS INDICATED IN THESE DRAWINGS ARE PROPERTY OF MARIN ARCHITECTS. ALL COPYRIGHTS RESERVED © 2019.

KEY PLAN

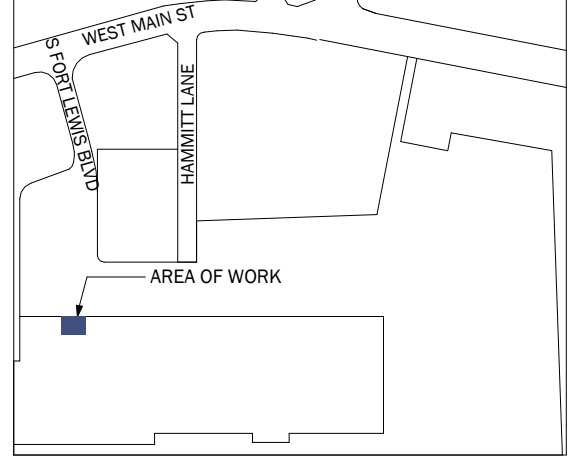

CLIENT:

PROJECT NAME:

US FOODS
MEZZANINE RENOVATION


PROJECT ADDRESS:

40 S FORT LEWIS BLVD
SALEM, VA 24153


DWG TITLE:

PLUMBING - FLOOR PLANS - DWV

SEAL
COMMONWEALTH OF VIRGINIA
PROFESSIONAL ENGINEER
ERIC MICHAEL WOLF
Lic No. 402053869
DATE: 9/2/2025 2:38:29 PM
PROJECT No: 20250189.0
DRAWING BY: BG
CHK BY: EW
DWG No: P-100.00
09/02/2025

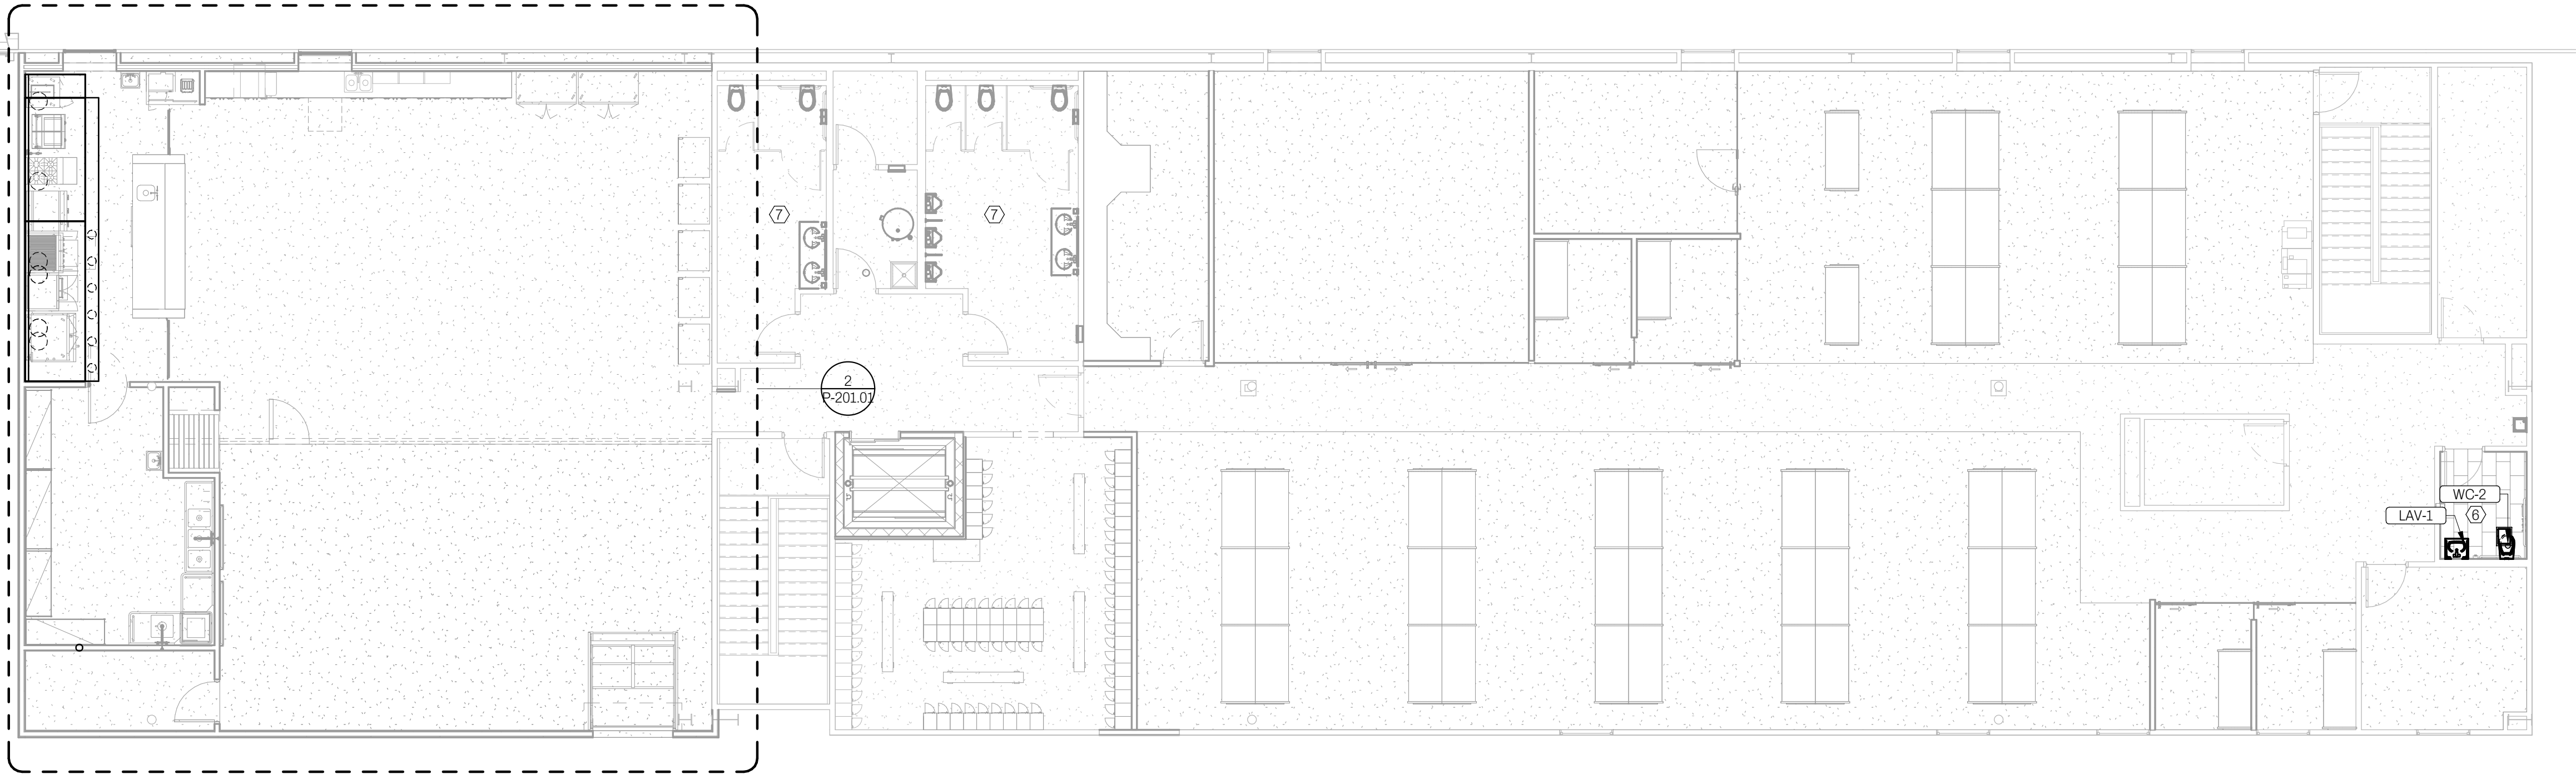


2 PLUMBING - MEZZANINE PLAN - DWV
P-100.00 1/8" = 1'-0"

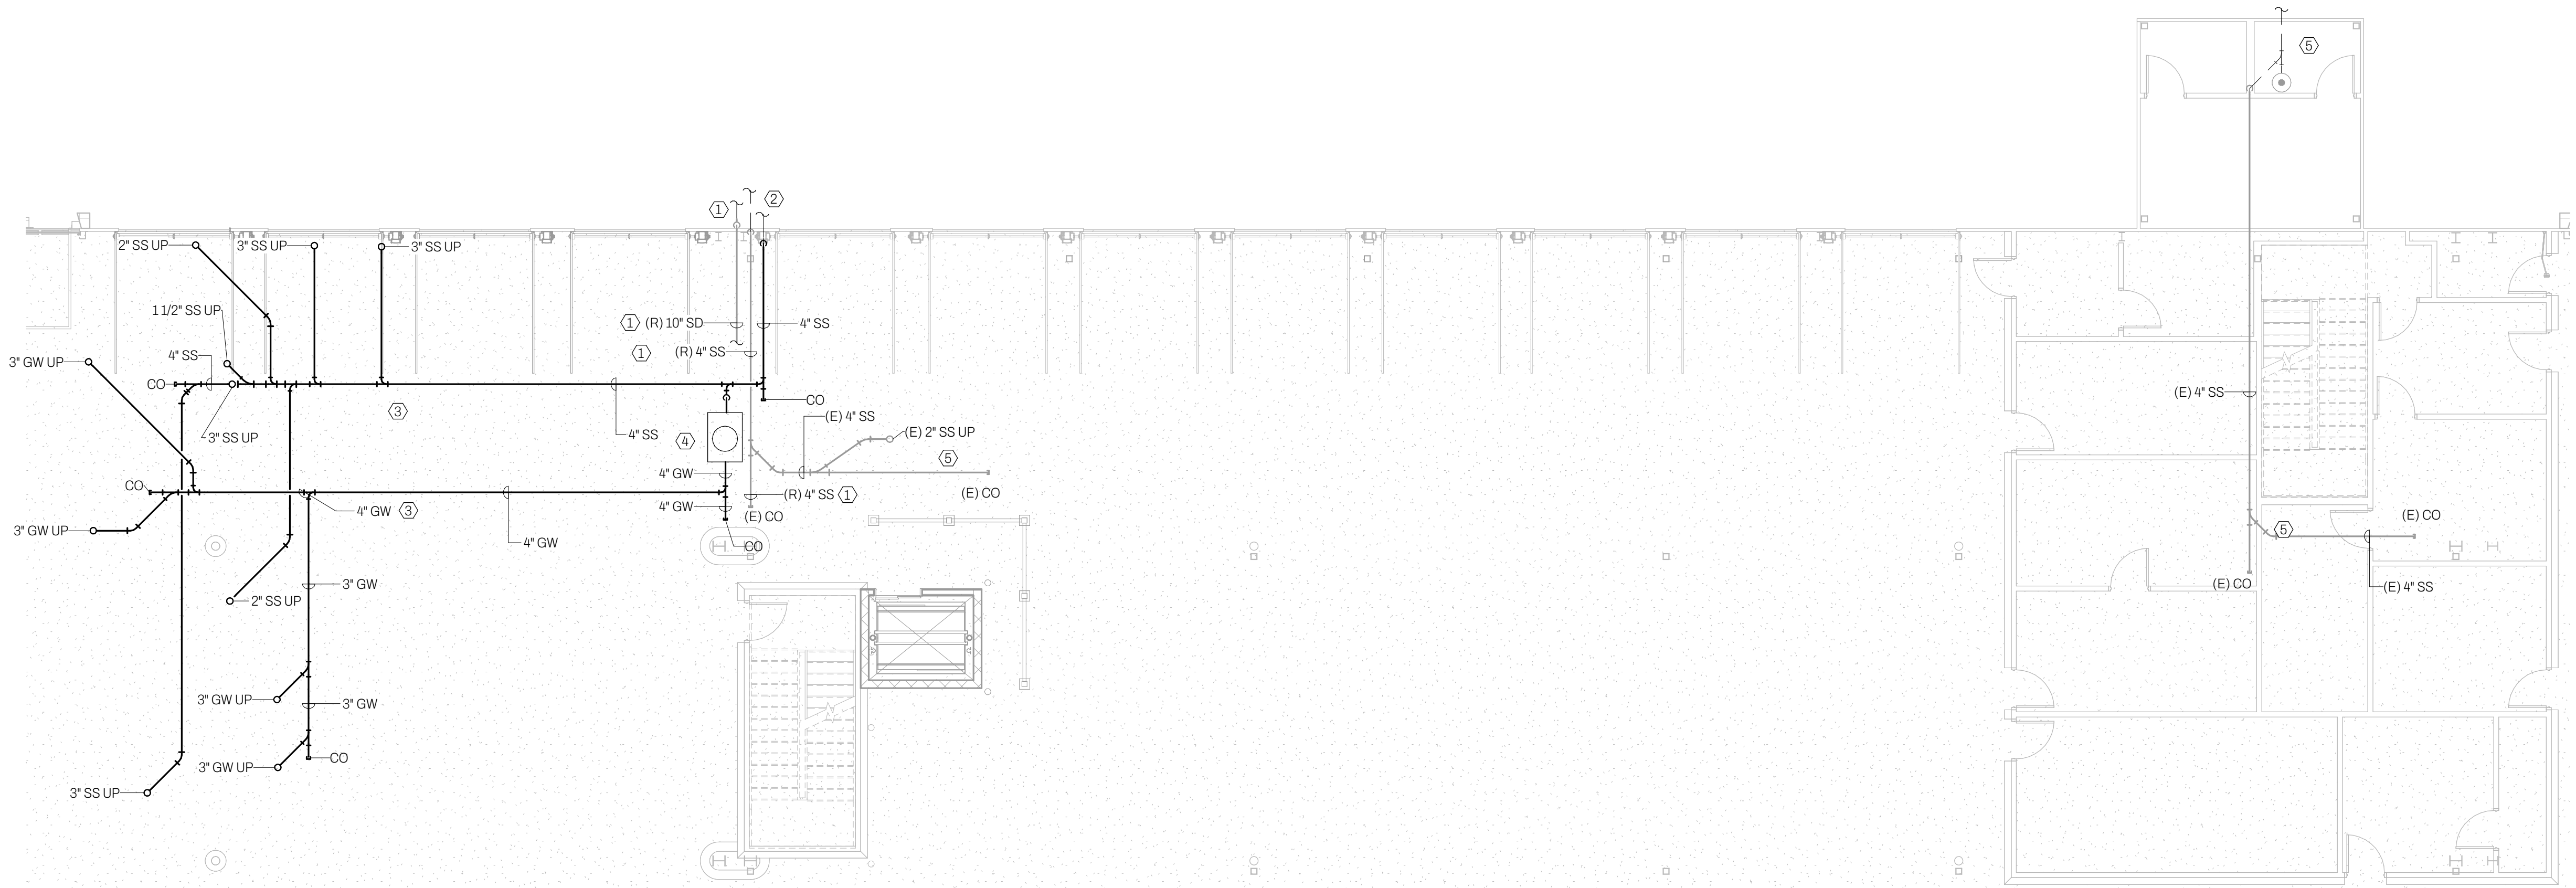


1 PLUMBING - GROUND FLOOR PLAN - DWV
P-100.00 1/8" = 1'-0"

2 PLUMBING - MEZZANINE PLAN - DOMESTIC WATER
P-200.00 1/8" = 1'-0"

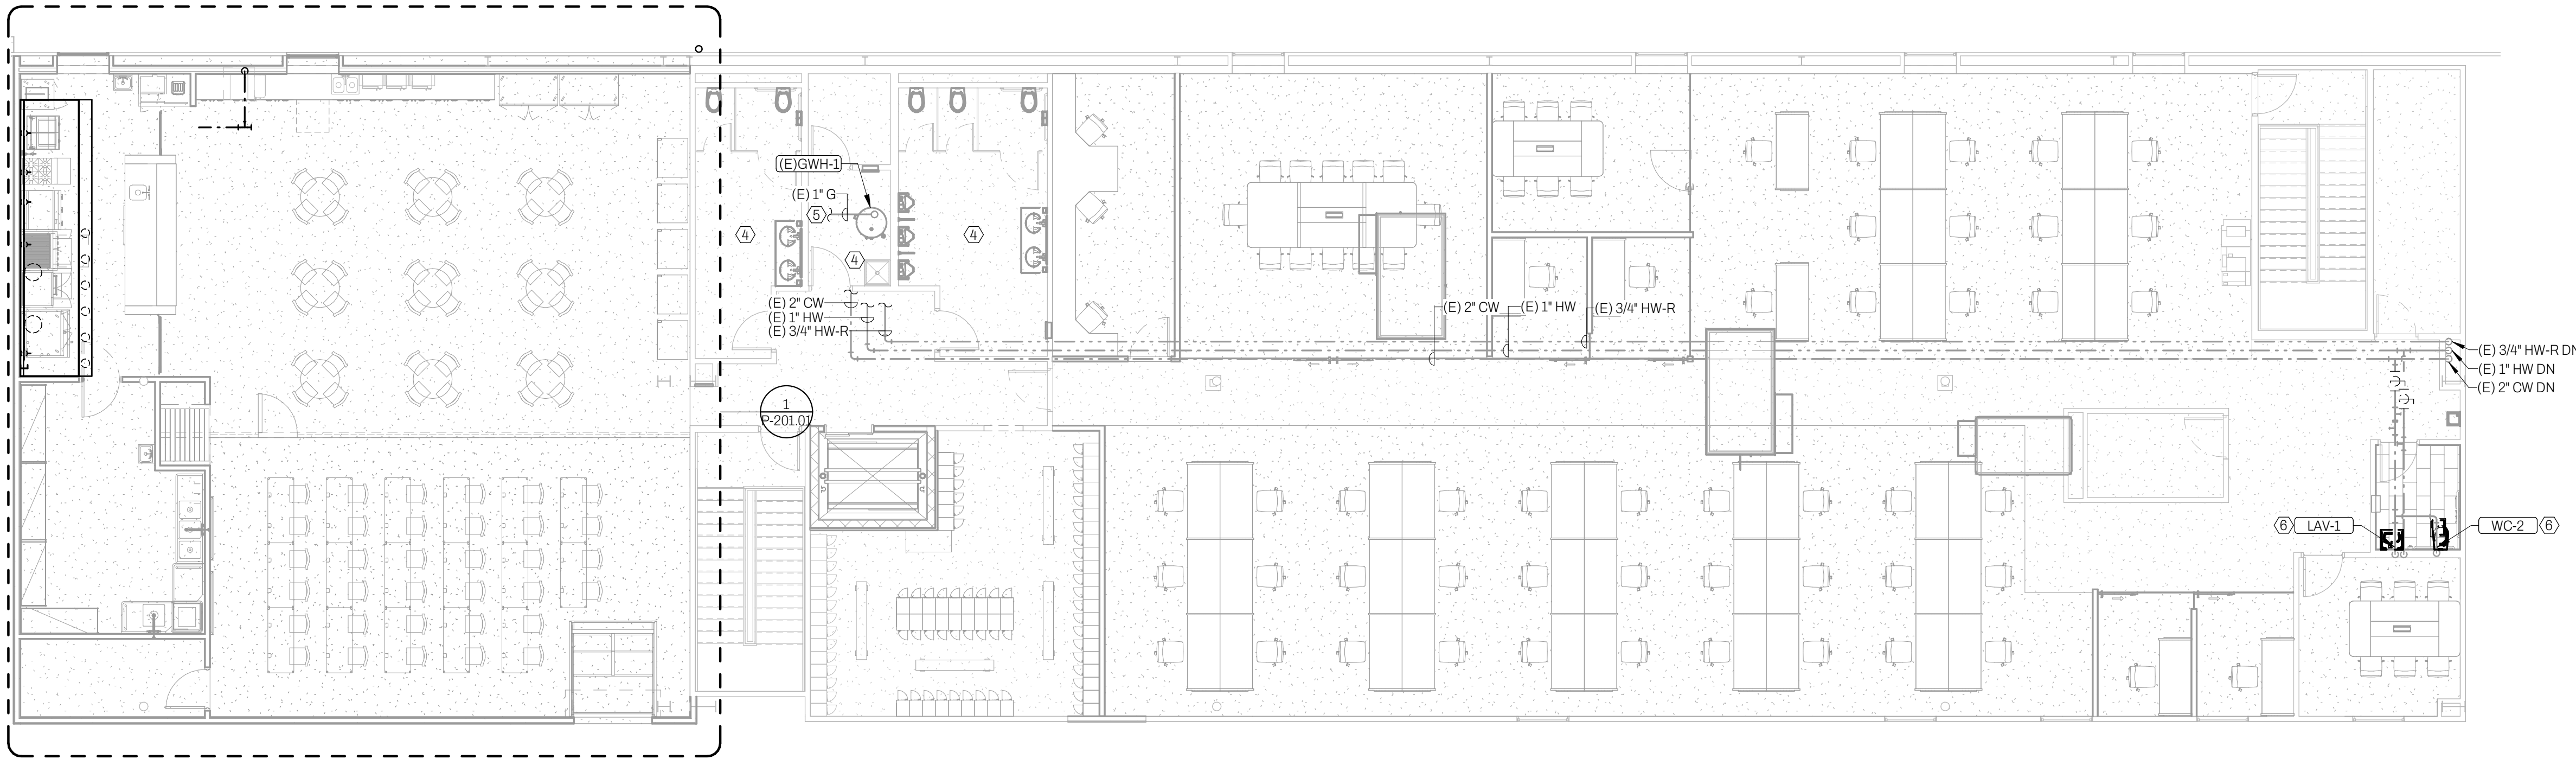

1 PLUMBING - GROUND FLOOR PLAN - DOMESTIC WATER
P-200.00 1/8" = 1'-0"

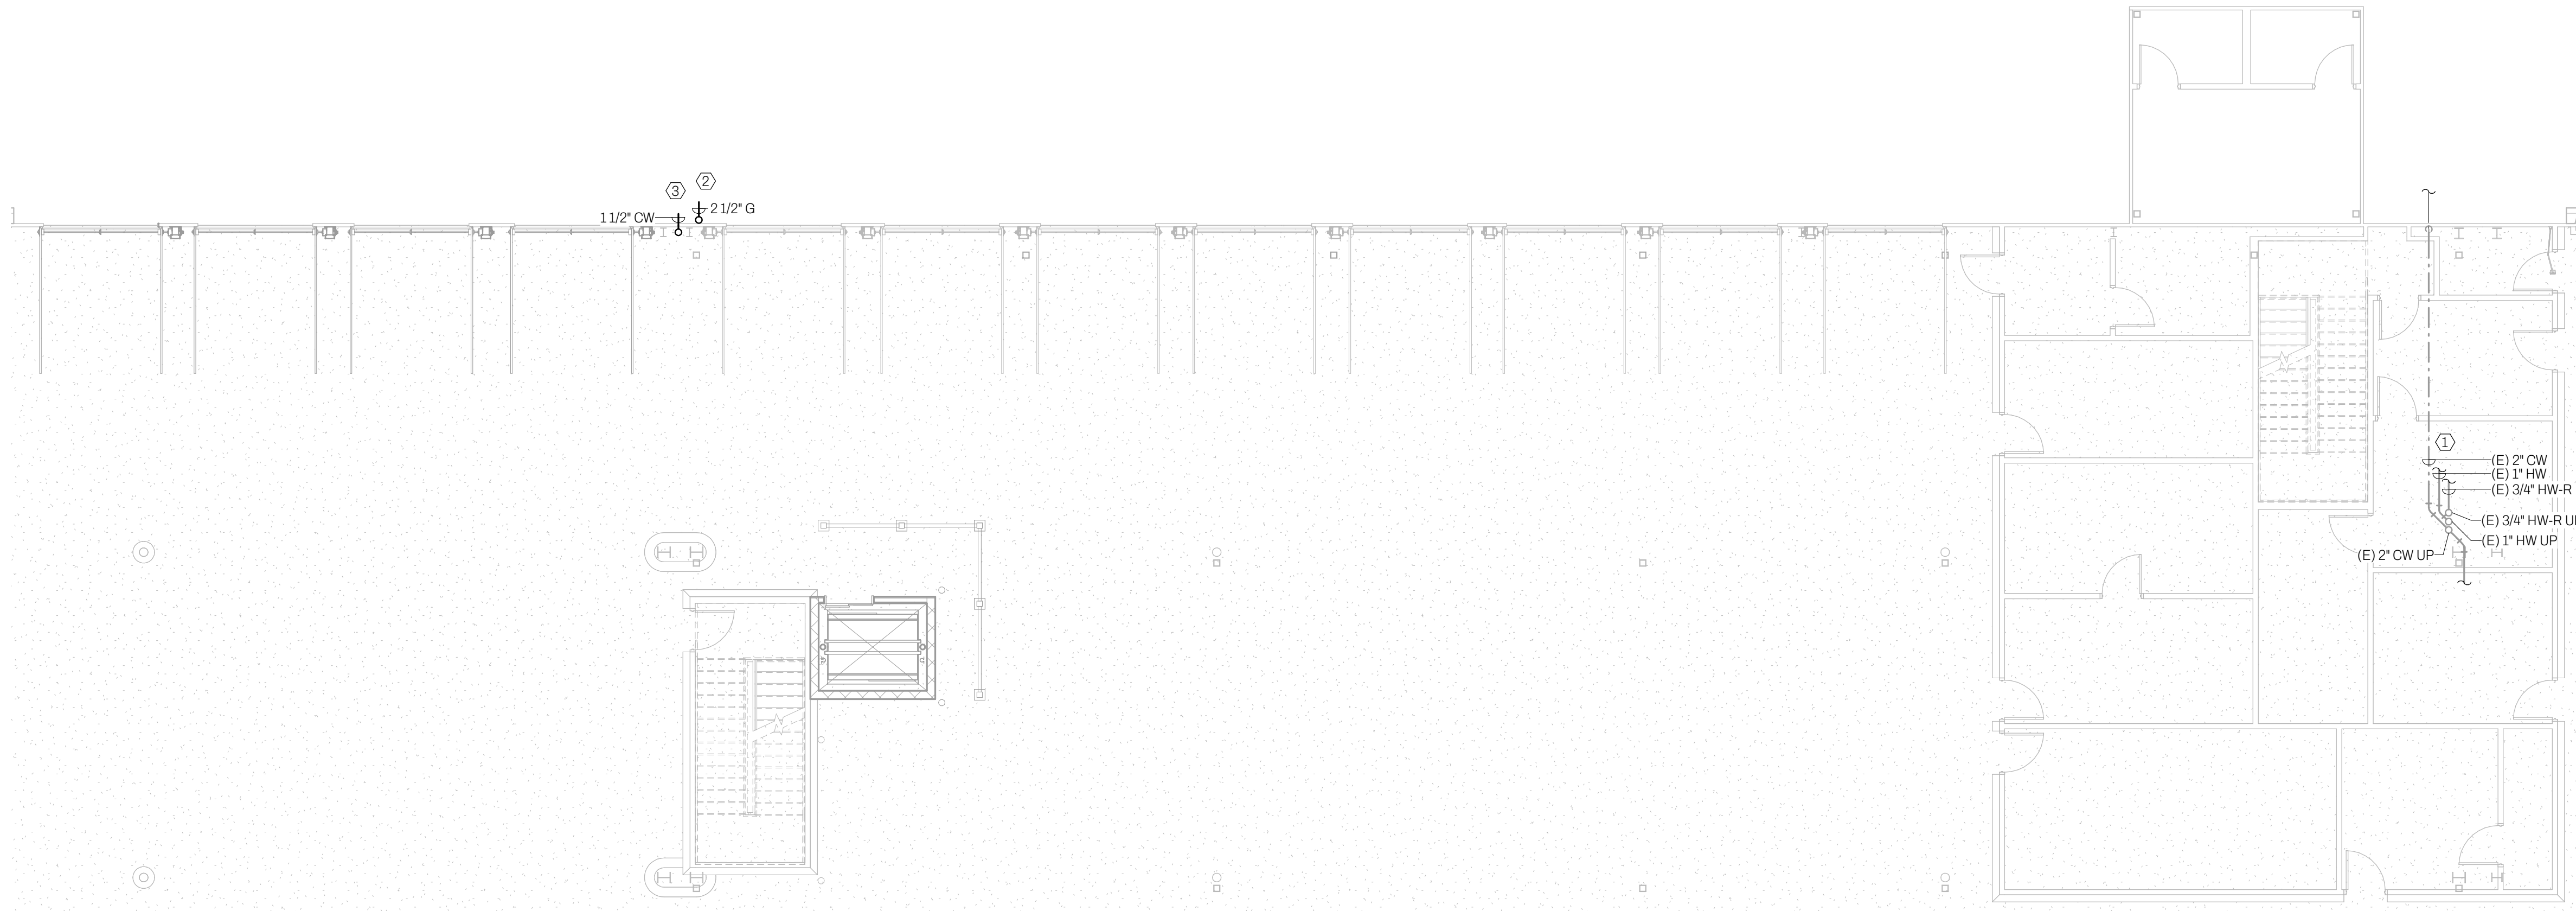

GENERAL NOTES

- IT IS THE RESPONSIBILITY OF THE GENERAL AND PLUMBING CONTRACTOR TO FULLY INSPECT THE SITE PRIOR TO COMMENCEMENT.
- VERIFY ALL EXISTING CONDITIONS INCLUDING LOCATION OF ALL STRUCTURAL ELEMENTS, BAR JOISTS, COLUMNS, ETC. AND COORDINATE PIPING SYSTEMS AND LOCATIONS ACCORDINGLY.
- REFER TO ENLARGED PLANS FOR ADDITIONAL INFORMATION.

KEY NOTES

- LOCATE CONTINUATION OF EXISTING DOMESTIC HOT WATER, DOMESTIC COLD WATER, AND HOT WATER RETURN PIPING.
- PROVIDE NEW 2-1/2" NATURAL GAS PIPING INTO SPACE TO SERVE MEZZANINE. UPGRADE METER AS REQUIRED FOR ADDITIONAL LOAD (REFER TO SHEET P201.01). COORDINATE NEEDS WITH UTILITIES.
- PROVIDE NEW 1-1/2" DOMESTIC WATER PIPING TO SERVE MEZZANINE. UPGRADE METER AND RPZ ASSEMBLY AS REQUIRED. COORDINATE WITH UTILITIES. REFER TO SHEET P201.01 FOR ADDITIONAL INFORMATION.
- EXISTING FIXTURE(S) AND DOMESTIC WATER PIPING TO REMAIN (OUT OF SCOPE).
- EXISTING NATURAL GAS PIPING, REGULATOR, AND SHUTOFF TO WATER HEATER.
- LOCATE AND REPLACE EXISTING FIXTURES WITH NEW. INSPECT AND REPAIR/REPLACE EXISTING PIPING CONNECTIONS AS REQUIRED.

MARIN
ARCHITECTS

57W 38TH ST LVL 10 NEW YORK NY 10018
212 463 8480 INFO@MARINARCHITECTS.COM

Contractor
CTS Builders

Structural Engineer
Penn Fusion Engineering

MEP Engineering
Wolf Engineering


WOLF
ENGINEERING

P.O. BOX 38 | DALTON, GA 30722

09/02/25	FILING SET
08/25/25	90% REVIEW
08/07/25	60% PROGRESS SET

NO COPIES, TRANSMISSIONS, REPRODUCTIONS, OR ELECTRONIC REVISIONS OF ANY PORTIONS OF THESE DRAWINGS IN WHOLE OR IN PART BE MADE WITHOUT THE EXPRESS WRITTEN PERMISSION OF MARIN ARCHITECTS. ALL DESIGNS INDICATED IN THESE DRAWINGS ARE PROPERTY OF MARIN ARCHITECTS. ALL COPYRIGHTS RESERVED © 2019.

KEY PLAN

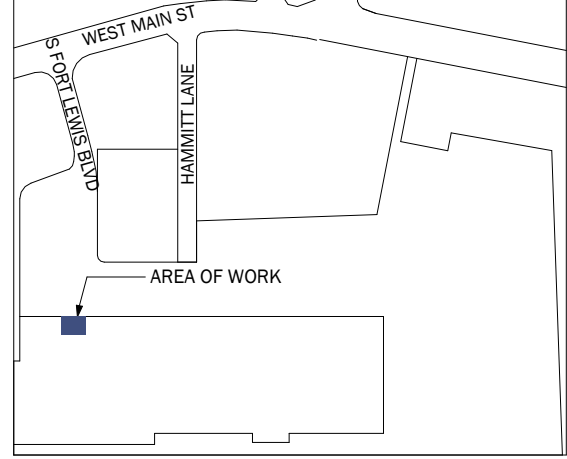

CLIENT:

PROJECT NAME:


US FOODS
MEZZANINE RENOVATION

PROJECT ADDRESS:

40 S FORT LEWIS BLVD
SALEM, VA 24153

DWG TITLE:

PLUMBING - FLOOR PLANS - DOMESTIC
WATER

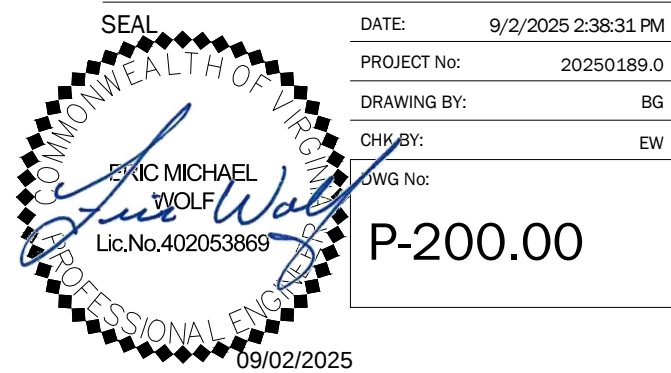

DATE:	9/2/2025 2:38:31 PM
PROJECT No:	20250189.0
DRAWING BY:	BG
CHKD BY:	EW
DWG No:	P-200.00

9/02/2025

A. IT IS THE RESPONSIBILITY OF THE GENERAL AND PLUMBING CONTRACTOR TO FULLY INSPECT THE SITE PRIOR TO COMMENCEMENT.

B. VERIFY ALL EXISTING CONDITIONS INCLUDING LOCATION OF ALL STRUCTURAL ELEMENTS, BAR JOISTS, COLUMNS, ETC. AND COORDINATE PIPING SYSTEMS AND LOCATIONS ACCORDINGLY.

Contractor
CTS Builders

Structural Engineer
Penn Fusion Engineering

MEP Engineering
Wolf Engineering

P.O. BOX 38 | DALTON, GA 30722

08/07/25 | 60% PROGRESS SE

NO COPIES, TRANSMISSIONS, REPRODUCTIONS, OR ELECTRONIC
REVISIONS OF ANY PORTIONS OF THESE DRAWINGS IN WHOLE OR IN
PART BE MADE WITHOUT THE EXPRESS WRITTEN PERMISSION OF
MARIN ARCHITECTS. ALL DESIGNS INDICATED IN THESE DRAWINGS
ARE PROPERTY OF MARIN ARCHITECTS. ALL COPYRIGHTS RESERVED
© 2019.

A map showing the project location. The map includes labels for 'WEST MAIN ST', 'HAMILT LANE', 'S 10TH AVE', and 'AREA OF WORK'. A blue square indicates the project location on S 10TH AVE.

CLIENT:

PROJECT NAME:

US FOODS MEZZANINE RENOVATION

PROJECT ADDRESS:

40 S FORT LEWIS BLVD
SALEM, VA 24153

DWG TITLE:


PLUMBING - ENLARGED PLAN

DATE:	9/2/2025 2:38:34 PM
PROJECT No:	20250189.0
DRAWING BY:	BG
CHK BY:	EW
DWG No:	

P-201.01

09/02/2025

GREAST INTERCEPTOR SIZING (2021 IPC SECTION 1003.3.5) - METHOD - PDI G101							
EQUIPMENT:	QUANTITY:	DIMENSIONS:	GALLONS (EACH) (CUB. INCH/231)	GALLONS (TOTAL)	DRAINAGE LOAD (GALLONS X.75)	FLOW RATE (1 MINUTE)	FLOW RATE (2 MINUTE)
3 COMP SINK	1	54X16X14	53	53	39.75	39.75	19.88
PREP SINK	2	16X16X12	13.3	26.6	19.95	19.95	9.98
					TOTAL FLOW RATE:	59.7	29.85
					PDI=FLOW RATE:	75	35
					GREASE CAPACITY:	100	75
GREASE INTERCEPTOR SELECTION : SCHIER GB-75 GREAT BASIN - RATING - 75GPM WITH 125 GALLON CAPACITY							
GREASE INTERCEPTOR DIMENSIONS : 42.75" TALL, 33" WIDE, 47" LONG. SUSPENDED SUPPORT WEIGHT - 1172LBS							

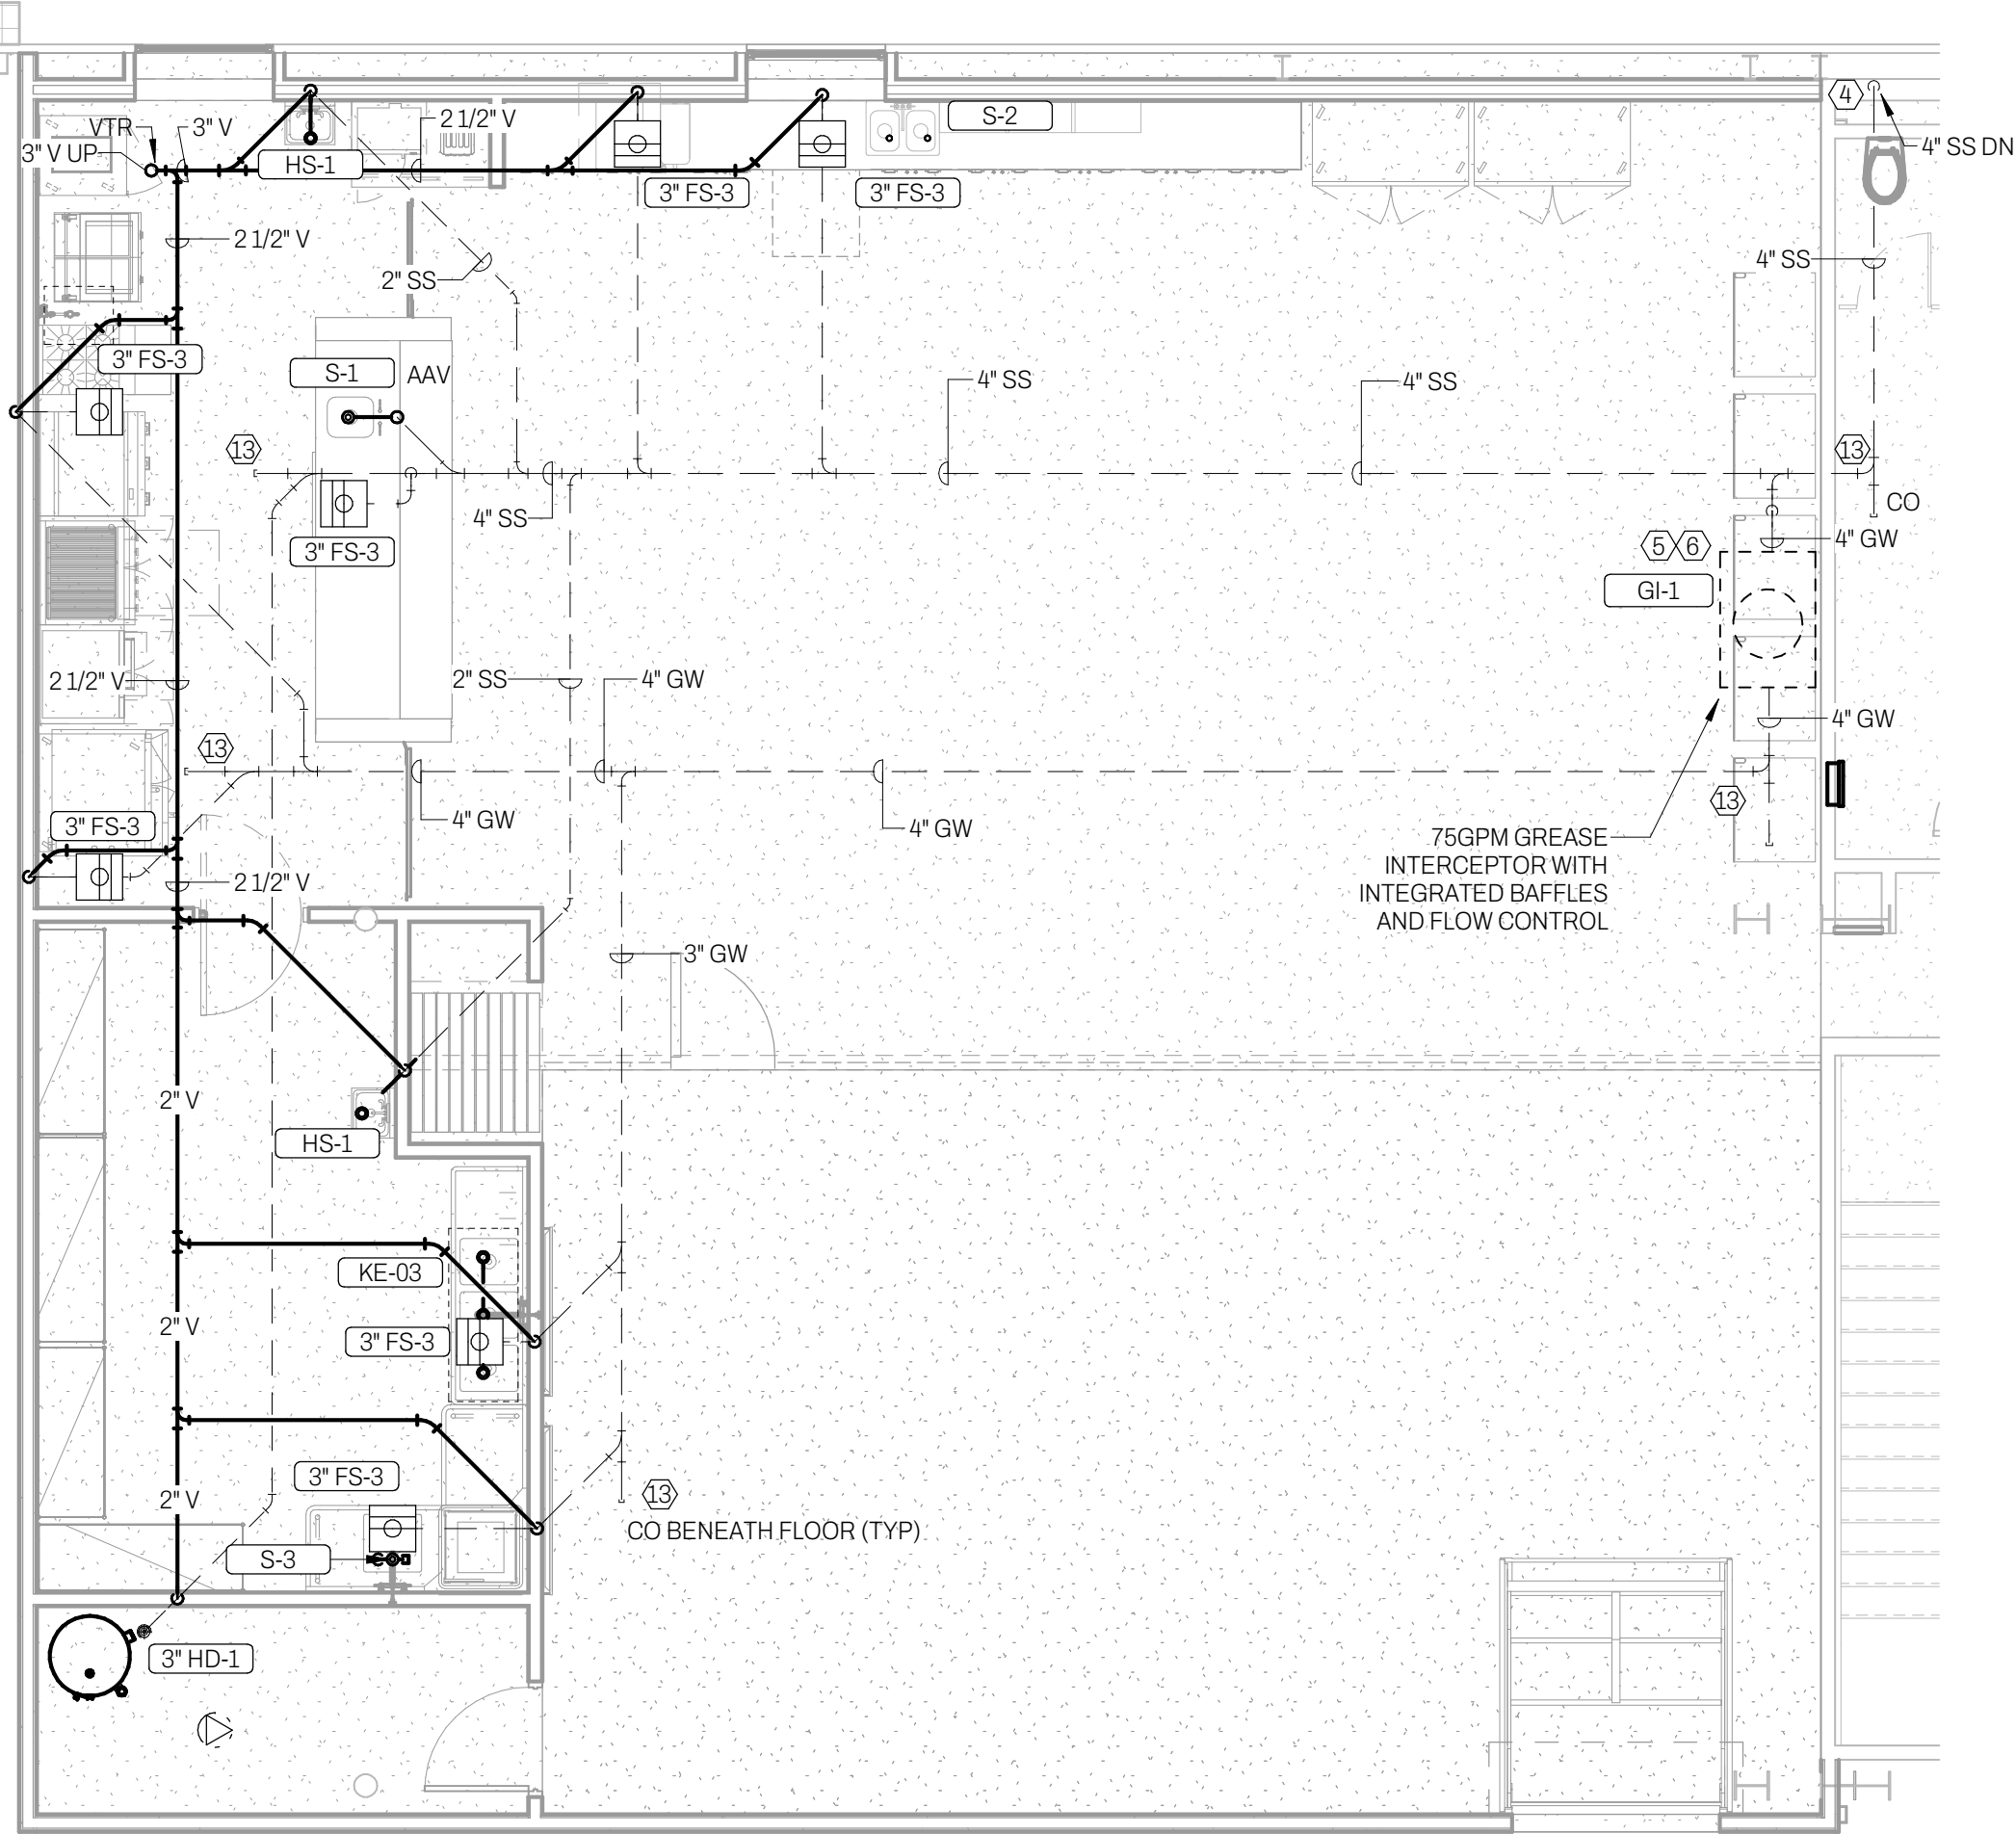

GENERAL NOTES

- A. IT IS THE RESPONSIBILITY OF THE GENERAL AND PLUMBING CONTRACTOR TO FULLY INSPECT THE SITE PRIOR TO COMMENCEMENT.
- B. VERIFY ALL EXISTING CONDITIONS INCLUDING LOCATION OF ALL STRUCTURAL ELEMENTS, BAR JOISTS, COLUMNS, ETC. AND COORDINATE PIPING SYSTEMS AND LOCATIONS ACCORDINGLY.
- C. REFER TO ENLARGED PLANS FOR ADDITIONAL INFORMATION.

KEY NOTES

1. PROVIDE 1-1/2" NATURAL GAS PIPING UP THRU ROOF TO SERVE UNITS AS SHOWN.
2. PROVID SHUTOFF, DIRT LEGS, AND ALL ASSOCIATED APPARATUS TO CONNECT NEW AND RELOCATED EQUIPMENT.
3. FIXTURES/EQUIPMENT EXISTING TO REMAIN/OUT OF SCOPE.

MARIN
ARCHITECTS

57W 38TH ST LVL 10 NEW YORK NY 10018
212 463 8480 INFO@MARINARCHITECTS.COM

Contractor
CTS Builders

Structural Engineer
Penn Fusion Engineering

MEP Engineering
Wolf Engineering


WOLF
ENGINEERING

P.O. BOX 38 | DALTON, GA 30722

09/02/25	FILING SET
08/25/25	90% REVIEW
08/07/25	60% PROGRESS SET

NO COPIES, TRANSMISSIONS, REPRODUCTIONS, OR ELECTRONIC REVISIONS OF ANY PORTIONS OF THESE DRAWINGS IN WHOLE OR IN PART BE MADE WITHOUT THE EXPRESS WRITTEN PERMISSION OF MARIN ARCHITECTS. ALL DESIGNS INDICATED IN THESE DRAWINGS ARE PROPERTY OF MARIN ARCHITECTS. ALL COPYRIGHTS RESERVED © 2019.

KEY PLAN

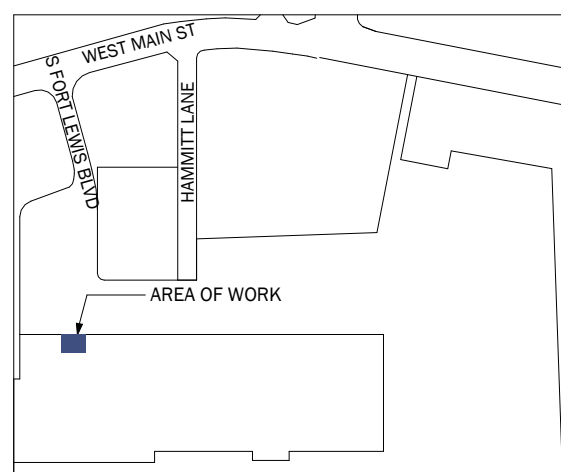

CLIENT:

PROJECT NAME:


US FOODS
MEZZANINE RENOVATION

PROJECT ADDRESS:

40 S FORT LEWIS BLVD
SALEM, VA 24153

DWG TITLE:


PLUMBING - ROOF PLAN

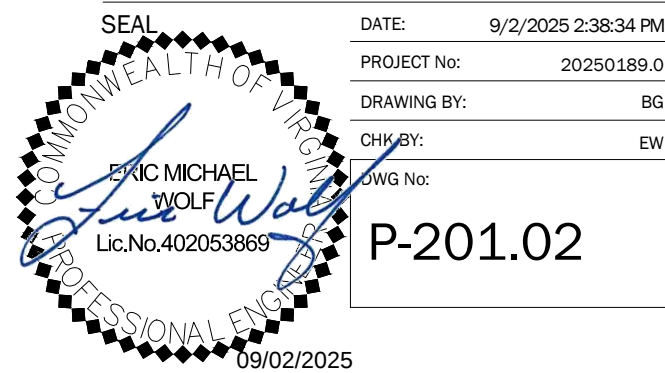

DATE:	9/2/2025 2:38:34 PM
PROJECT No:	20250189.0
DRAWING BY:	BG
CHK'BY:	EW
DWG No:	

P-201.02

09/02/2025

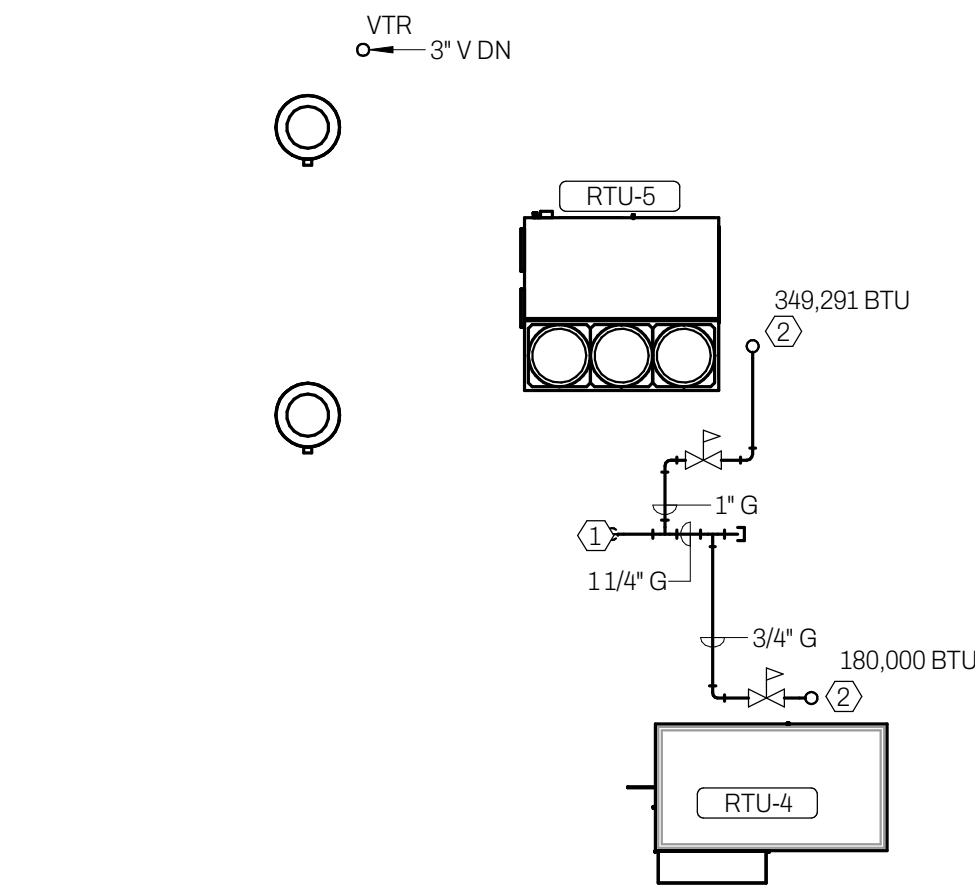

MEP Engineering
Wolf Engineering



NO COPIES, TRANSMISSIONS, REPRODUCTIONS, OR ELECTRONIC REVISIONS OF ANY PORTIONS OF THESE DRAWINGS IN WHOLE OR IN PART BE MADE WITHOUT THE EXPRESS WRITTEN PERMISSION OF MARIN ARCHITECTS. ALL DESIGNS INDICATED IN THESE DRAWINGS ARE PROPERTY OF MARIN ARCHITECTS. ALL COPYRIGHTS RESERVED © 2019.

NORTH



PLUMBING SCHEDULES

P-501.00

PIPING SCHEDULE	
PRODUCT SPECIFICATION	
1. LEVER SWIVEL FAUCET WITH 12" SPOUT. AERO MODEL NO. S-17 BASKET ASSEMBLY, P-TRAP, TAILPIECES, SUPPLIES AND STOPS. 2. SINK COMPARTMENT, 16 GAUGE. DUAL LEVER SWIVEL FAUCET WITH 18" SWING SPOUT. THREE AERO MODEL NO. S-20 TWIST LEVERWASTE, AERO MODEL NO. S-22 3 COMPARTMENT CONTINUOUS WASTE, SUPPLIES AND STOPS.	

KITCHEN EQUIPMENT SCHEDULE								
MARK	MANUFACTURER	MODEL	CONNECTION SIZES					PRODUCT SPECIFICATION
			CW	HW	WASTE	VENT	GAS	
K-8	BY OTHERS	BY OTHERS	1/2"	1/2"	0"		0"	DUAL LEVER SWIVEL FAUCET WITH 12" SPOUT. ONE AERO MODEL NO. S-17 BASKET ASSEMBLY, P-TRAP, TAILPIECES, SUPPLIES AND STOPS.
KE-03	BY OTHERS	BY OTHERS	1/2"	1/2"	2"		0"	THREE COMPARTMENT, 16 GAUGE. DUAL LEVER SWIVEL FAUCET WITH 18" SWING SPOUT. THREE AERO MODEL NO. S-20 TWIST TYPE LEVERWASTE, AERO MODEL NO. S-22 3 COMPARTMENT CONTINUOUS WASTE, SUPPLIES AND STOPS.

GAS-FIRED WATER HEATER SCHEDULE															
MARK	MANUFACTURER	MODEL	PRODUCT TYPE	DOMESTIC PIPING SIZE	TEMP. RISE	HOT SETPOINT	RECOVERY CAPACITY	STORAGE CAPACITY	GAS BURNER			ELECTRICAL		NOTES	
									TYPE	INPUT RATING	OUTPUT RATING	EFFICIENCY	VOLTAGE		PHASE
GWH-1	AO SMITH	BTH-199	STORAGE	1 1/2"	100 °F	140 °F	235 GPH	98 GAL	NG	199,900 BTU/H	194,000 BTU/H	97%	120 V	1	PROVIDE ASSE 1017 COMPLIANT MIXING VALVE; POWERS SERIES LF5H OR EQUAL

DOMESTIC CIRCULATOR PUMP SCHEDULE												
IDENTITY	MANUFACTURER	MODEL	MATERIAL	PUMP DESIGN		DESIGN PIPE SIZE	CONNECTIONS		MOTOR		ELECTRICAL	
				FLOW	HEAD		SUCTION	DISCHARGE	POWER	FLA	VOLTAGE	PHASE
DCP-1	BELL & GOSSETT	ECOCIRC E3-6V	BRASS	3.0 GPM	6.0 FT	1/2"	1/2"	1/2"	28 W	1.0 A	120 V	1

MARK	MANUFACTURER	MODEL	CONNECTION SIZES				PRODUCT SPECIFICATION
			CW	HW	WASTE	VENT	
FS-3	WATTS	FS-730			3"		12" SQUARE X 6" DEEP SANITARY FLOOR SINK WITH WHITE PORCELAIN ENAMEL COATED INTERIOR, LOOSE SET PORCELAIN ENAMEL COATED CAST IRON GRATE, ALUMINUM DOME BOTTOM STRAINER, AND NO HUB OUTLET.
HD-1	WATTS	FD-100-DD			3"		EPOXY COATED CAST IRON FLOOR DRAIN WITH ANCHOR FLANGE, REVERSIBLE CLAMPING COLLAR WITH PRIMARY & SECONDARY WEEPHOLES, ADJUSTABLE CAST IRON HUB FUNNEL, AND NO HUB OUTLET.
HS-1	ELKAY	EHS-18X	1/2"	1/2"	2"	2"	SINGLE COMPARTMENT, WALL HUNG, 18 GAUGE, WITH STRAINER AND FAUCET INCLUDED, P-TRAP, TAILPIECES, SUPPLIES AND STOPS. PROVIDE WITH HAWS MODEL NO. 7620 FAUCET MOUNTED EYEWASH AXION EYEOOD.
LAV-1	AMERICAN STANDARD	LUCERNE	1/2"	1/2"	1 1/2"	2"	WALL HUNG LAVATORY WITH BACKSPASH. FAUCET HOLES ON 4" CENTERS. DECK-MOUNTED FAUCET WITH SENSOR, WATER TURBINE POWER WITH VANDAL RESISTANT SPRAY, EXTERNAL ASSE 1070 COMPLANT THERMOSTATIC MIXING VALVE, GRID DRAIN, LOOSE KEY ANGLE STOPS AND SUPPLIES. INSULATE WATER AND WASTE WITH INSULATION KIT.
S-1	ELKAY	LRAD221955-3	1/2"	1/2"	1 1/2"	2"	SINGLE COMPARTMENT, ADA COMPLIANT, SELF-RIMMING, 18 GAUGE. SINGLE LEVER SWIVEL FAUCET. ONE ELKAY MODEL NO. LK35 BASKET STRAINER, P-TRAP, TAILPIECES, SUPPLIES AND STOPS. INSULATE WATER AND WASTE TO MEET ADA REQUIREMENTS.
S-2	ELKAY	LRAD291865	1/2"	1/2"	1 1/2"	2"	TWO COMPARTMENT, 16 GAUGE. DUAL LEVER SWIVEL FAUCET WITH 14" SPOUT. TWO AERO MODEL NO. S-17 BASKET ASSEMBLY, P-TRAP, TAILPIECES, SUPPLIES AND STOPS.
S-3	ELKAY	LRAD221955-3	1/2"	1/2"	1 1/2"	2"	SINGLE COMPARTMENT, ADA COMPLIANT, SELF-RIMMING, 18 GAUGE. SINGLE LEVER SWIVEL FAUCET. ONE ELKAY MODEL NO. LK35 BASKET STRAINER, P-TRAP, TAILPIECES, SUPPLIES AND STOPS. INSULATE WATER AND WASTE TO MEET ADA REQUIREMENTS.
WC-2	AMERICAN STANDARD	MADERA	1"		4"	2"	ELONGATED FLOOR MOUNTED WATER CLOSET, 1-1/2" TOP SPUD, WITH CHURCH 295CT ELONGATED OPEN FRONT SEAT. SOLAR POWERED SENSOR ACTIVATED FLUSHOMETER.

HYDROMECHANICAL GREASE INTERCEPTOR SCHEDULE								
MARK	MANUFACTURER	LOCATION	FLOW RATE	RATING	LIQUID CAPACITY	WEIGHT	DIMENSIONS	REMARKS
GH-1	SCHIER	SUSPENDED	75GPM	861LBS	125 GALLONS	190 LBS	1170 LBS	43"TX33"WX47"L ALL

REMARKS:

1. UNIT CONTAINS INTEGRATED BAFFLES AND FLOW CONTROL DEVICE CONFORMING TO TYPE D ASME STANDARDS, WITH 25% KITCHEN SINKS CAPACITY.
2. UNIT SHALL CONTAIN MANUFACTURER'S TRIPLE OUTLET FOR REMOTE PUMPOUT SERVICE.
3. PROVIDE UNIT WITH MANUFACTURER'S TRAFFIC COVER.
4. STRUCTURAL TO COORDINATE INSTALLATION LOCATION, ACCESS, AND SUPPORTS.

Contractor
CTS Builders

Structural Engineer
Penn Fusion Engineering

MEP Engineering
Wolf Engineering


WOLF
ENGINEERING

P.O. BOX 38 | DALTON, GA 30722

09/02/25 FILING SET
08/25/25 90% REVIEW
08/07/25 60% PROGRESS SET

NO COPIES, TRANSMISSIONS, REPRODUCTIONS, OR ELECTRONIC REVISIONS OF ANY PORTIONS OF THESE DRAWINGS IN WHOLE OR IN PART BE MADE WITHOUT THE EXPRESS WRITTEN PERMISSION OF MARIN ARCHITECTS. ALL DESIGNS INDICATED IN THESE DRAWINGS ARE PROPERTY OF MARIN ARCHITECTS. ALL COPYRIGHTS RESERVED © 2019.

KEY PLAN

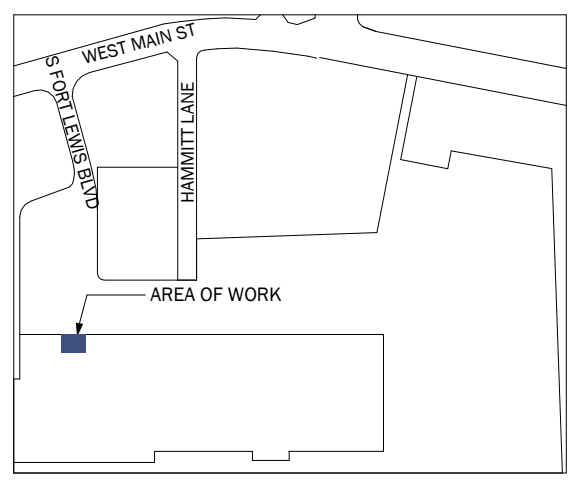

CLIENT:

PROJECT NAME:

US FOODS
MEZZANINE RENOVATION


PROJECT ADDRESS:

40 S FORT LEWIS BLVD
SALEM, VA 24153


DWG TITLE:

PLUMBING DETAILS


SEAL
COMMONWEALTH OF VIRGINIA
PROFESSIONAL ENGINEER
ERIC MICHAEL WOLF
Lic. No. 402053869
DATE: 9/2/2025 2:38:37 PM
PROJECT No: 20250189.0
DRAWING BY: BG
CHECKED BY: EW
DWG No: P-601.00
09/02/2025

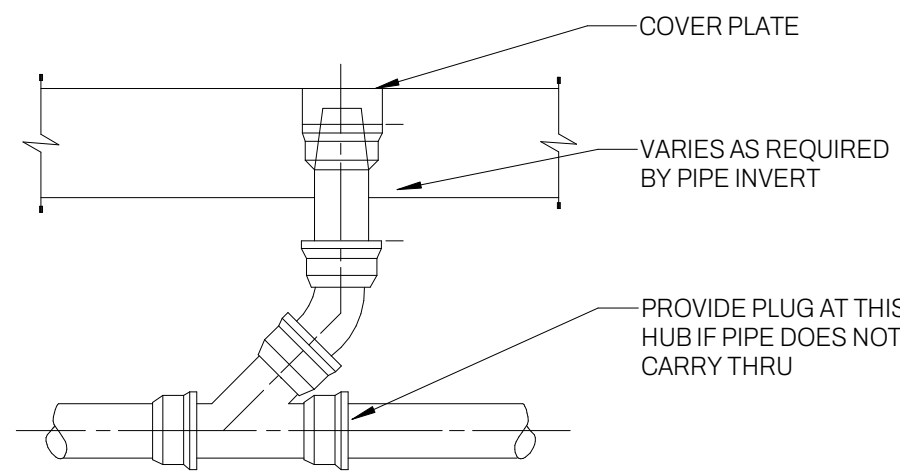

9 CLEAN OUT AND PLUGGED RISER
P-601.00 NOT TO SCALE

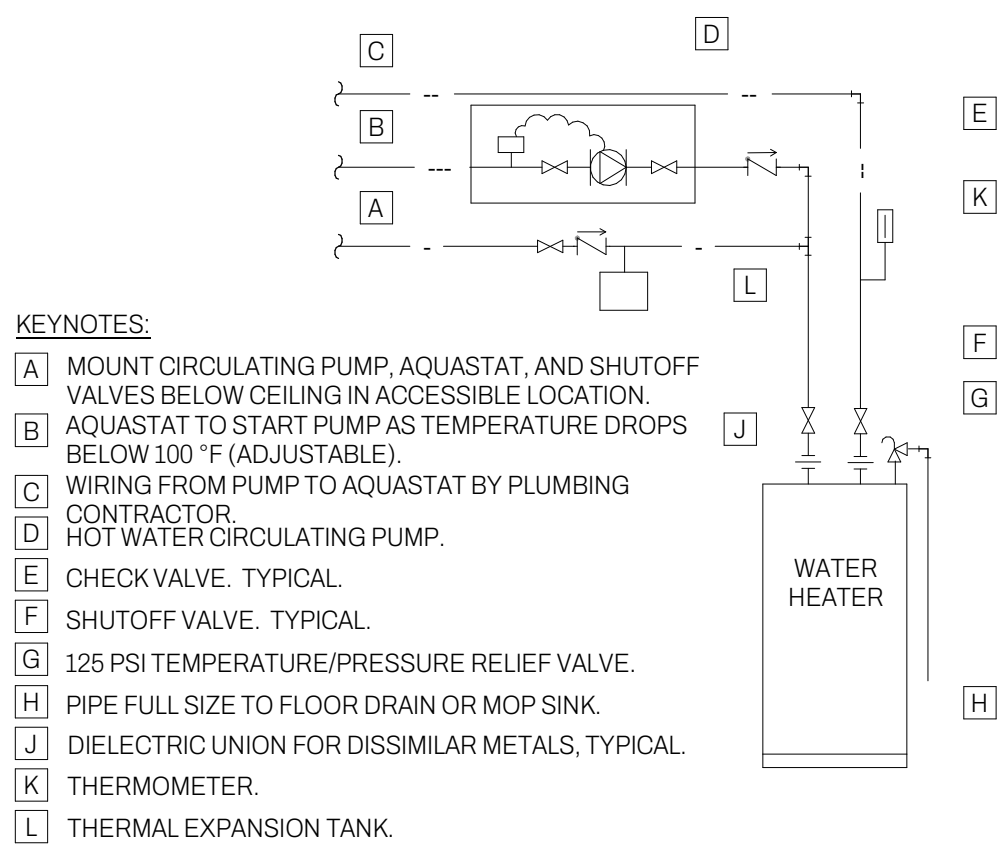


5 HOT WATER CIRCULATING PUMP PIPING DETAIL
P-601.00 NOT TO SCALE

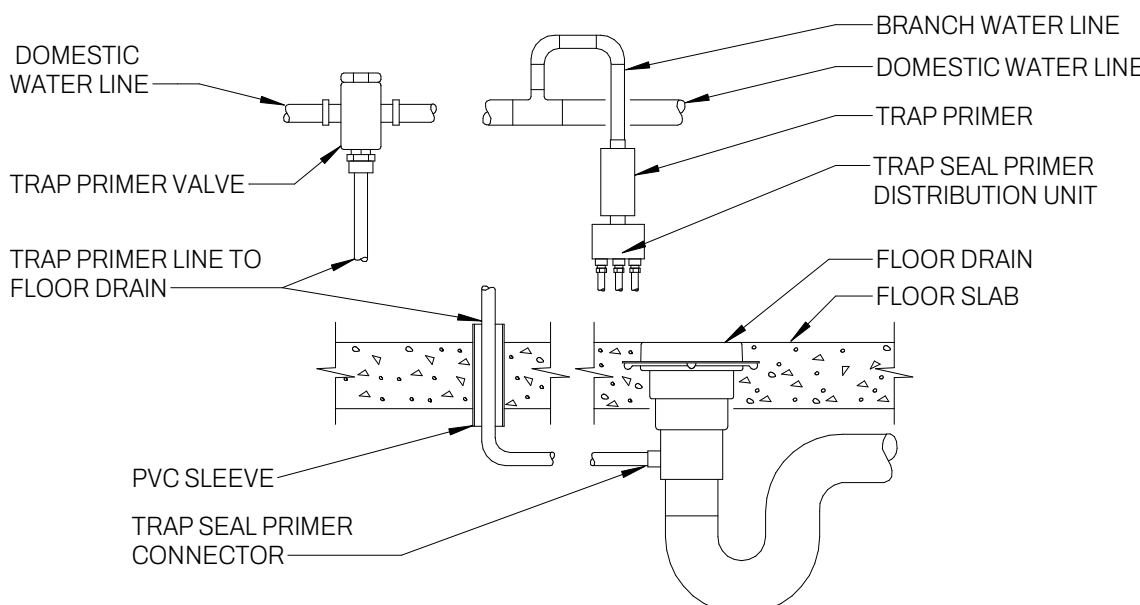


NOTES:
PROVIDE 12X12 ACCESS PANEL IN PLUMBING WALLS FOR SERVICING OF TRAP PRIMER VALVES.

6 TRAP PRIMER DETAIL
P-601.00 NOT TO SCALE

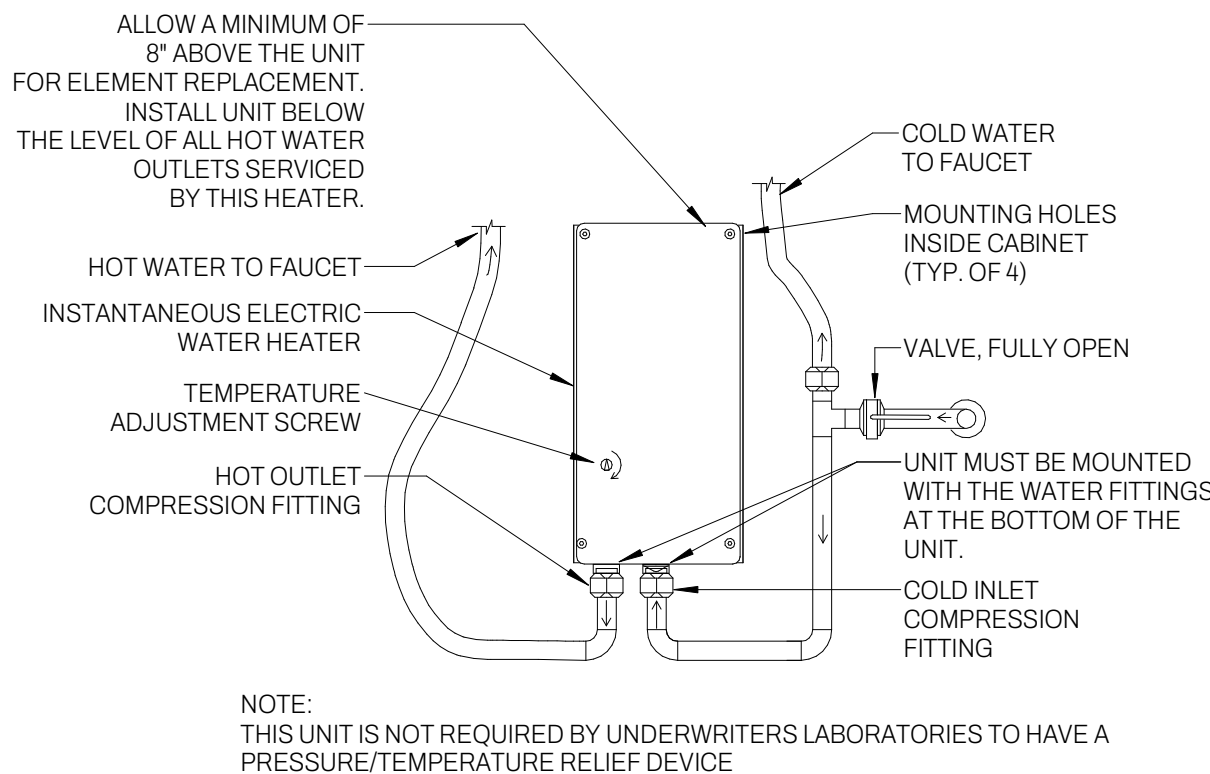


NOTE:
THIS UNIT IS NOT REQUIRED BY UNDERWRITERS LABORATORIES TO HAVE A PRESSURE/TEMPERATURE RELIEF DEVICE


7 PLUMBING - INSTANTANEOUS ELECTRIC WATER HEATER
P-601.00 1/8" = 1'-0"

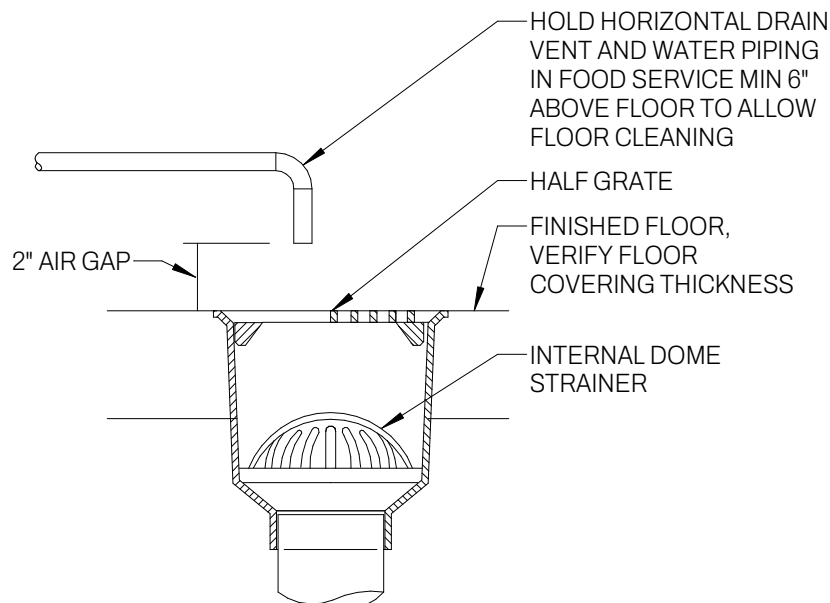


8 FLOOR SINK
P-601.00 NOT TO SCALE

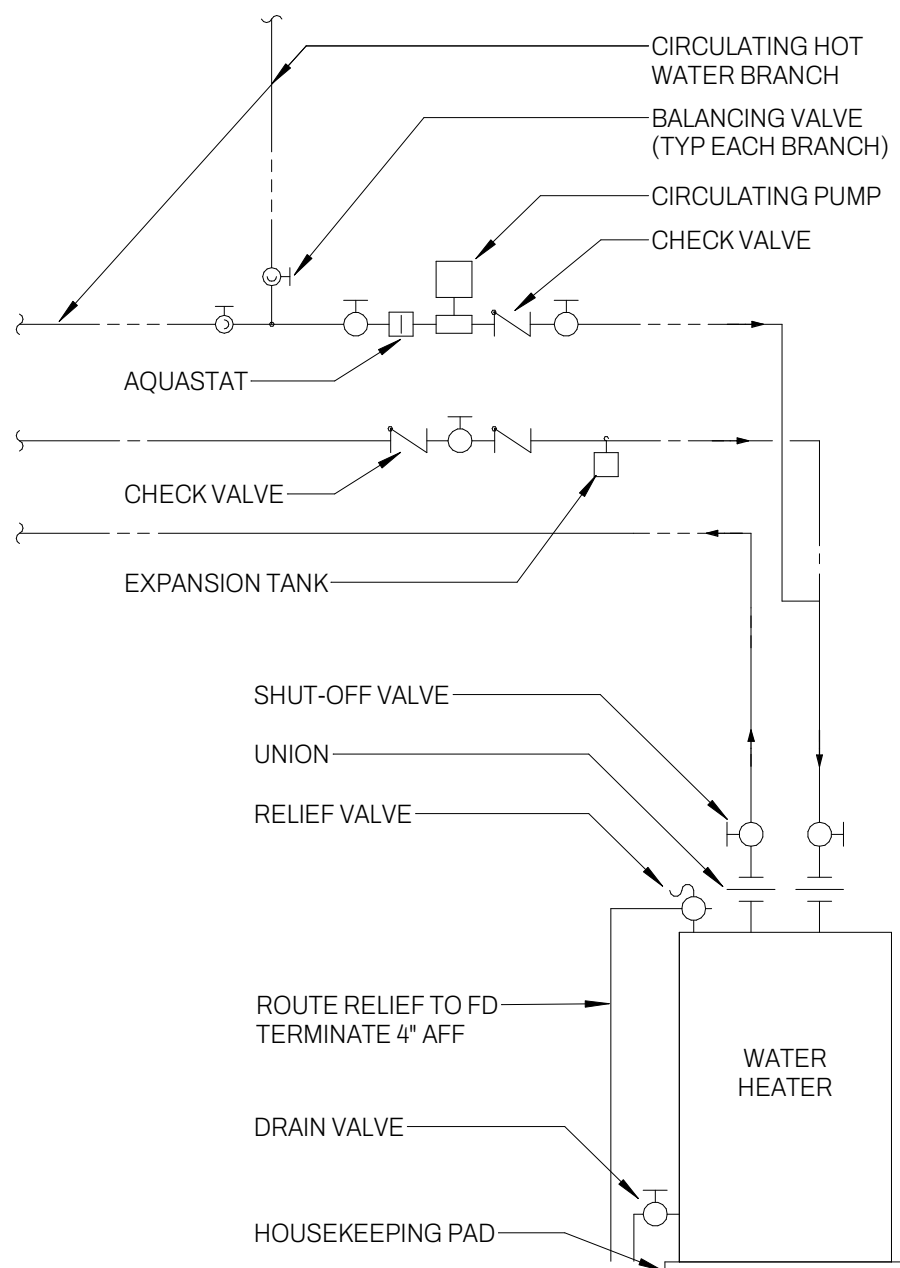


1 WATER HEATER PIPING DETAIL - SINGLE W/RECIRCULATION
P-601.00 NOT TO SCALE

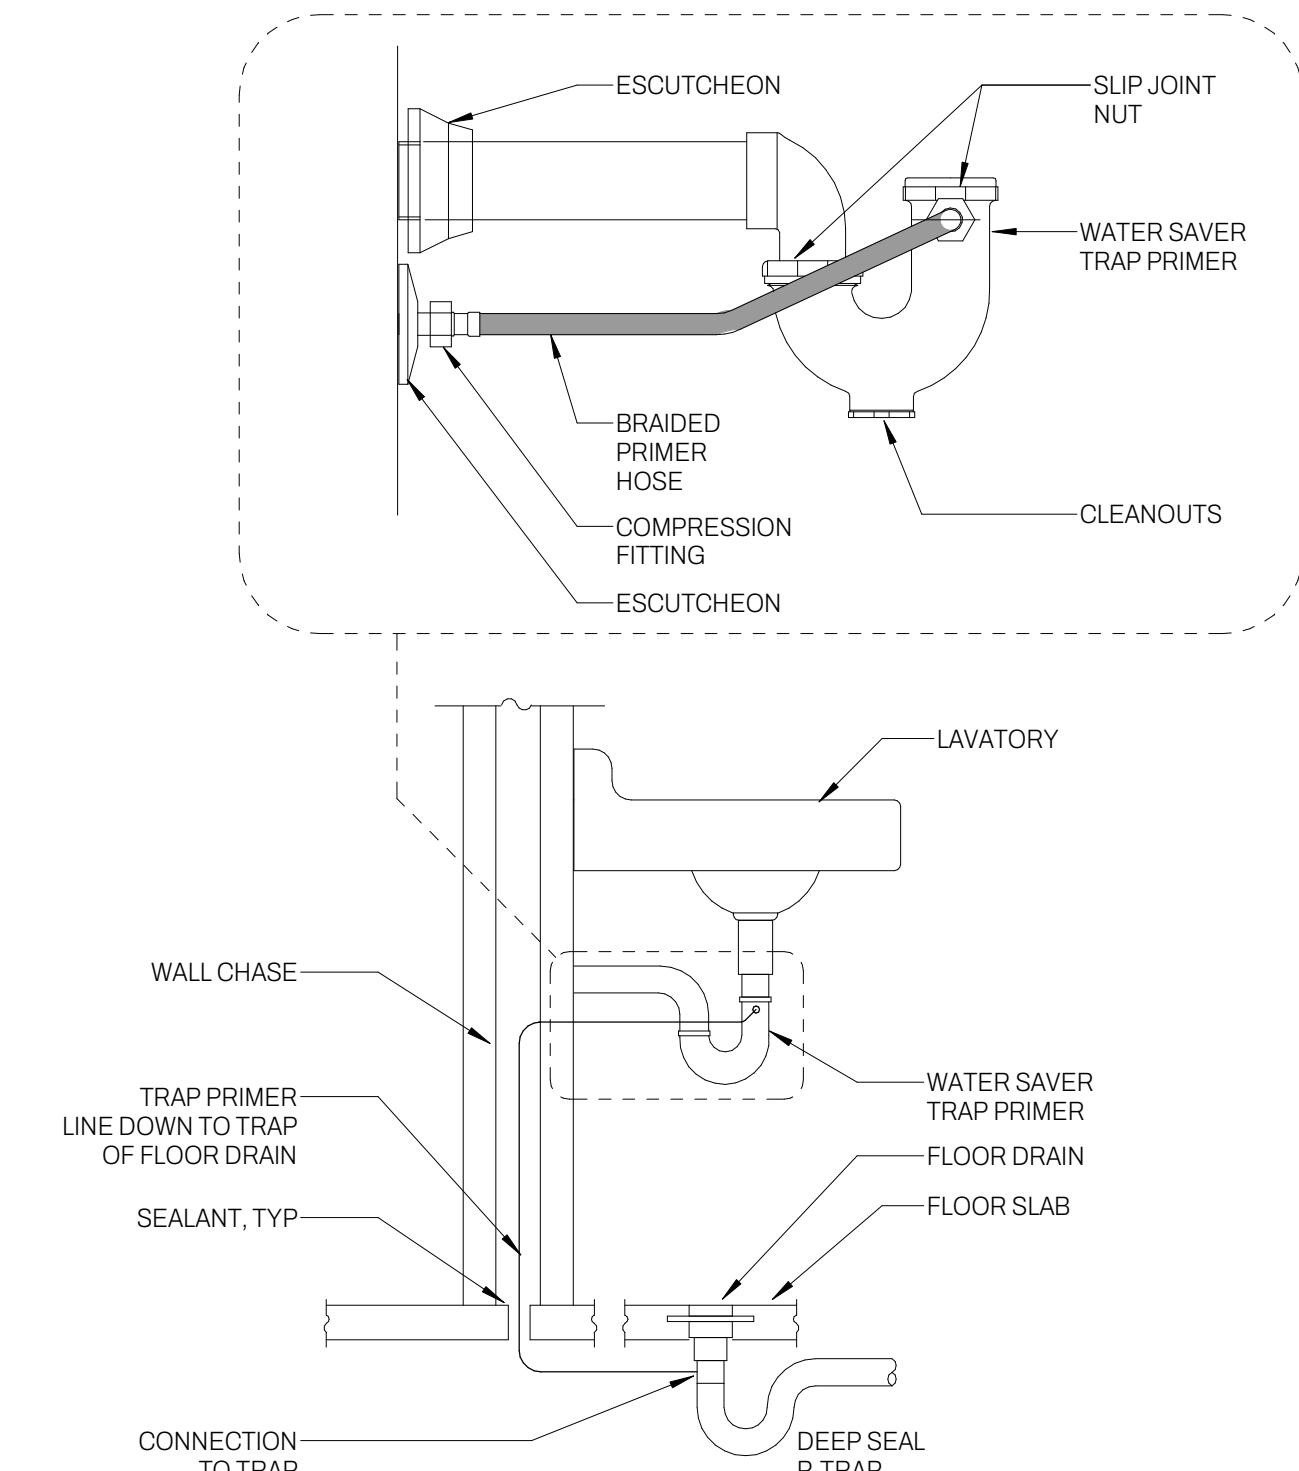

2 VALVE-LESS TRAP PRIMER DETAIL - TOILET ROOMS
P-601.00 NOT TO SCALE

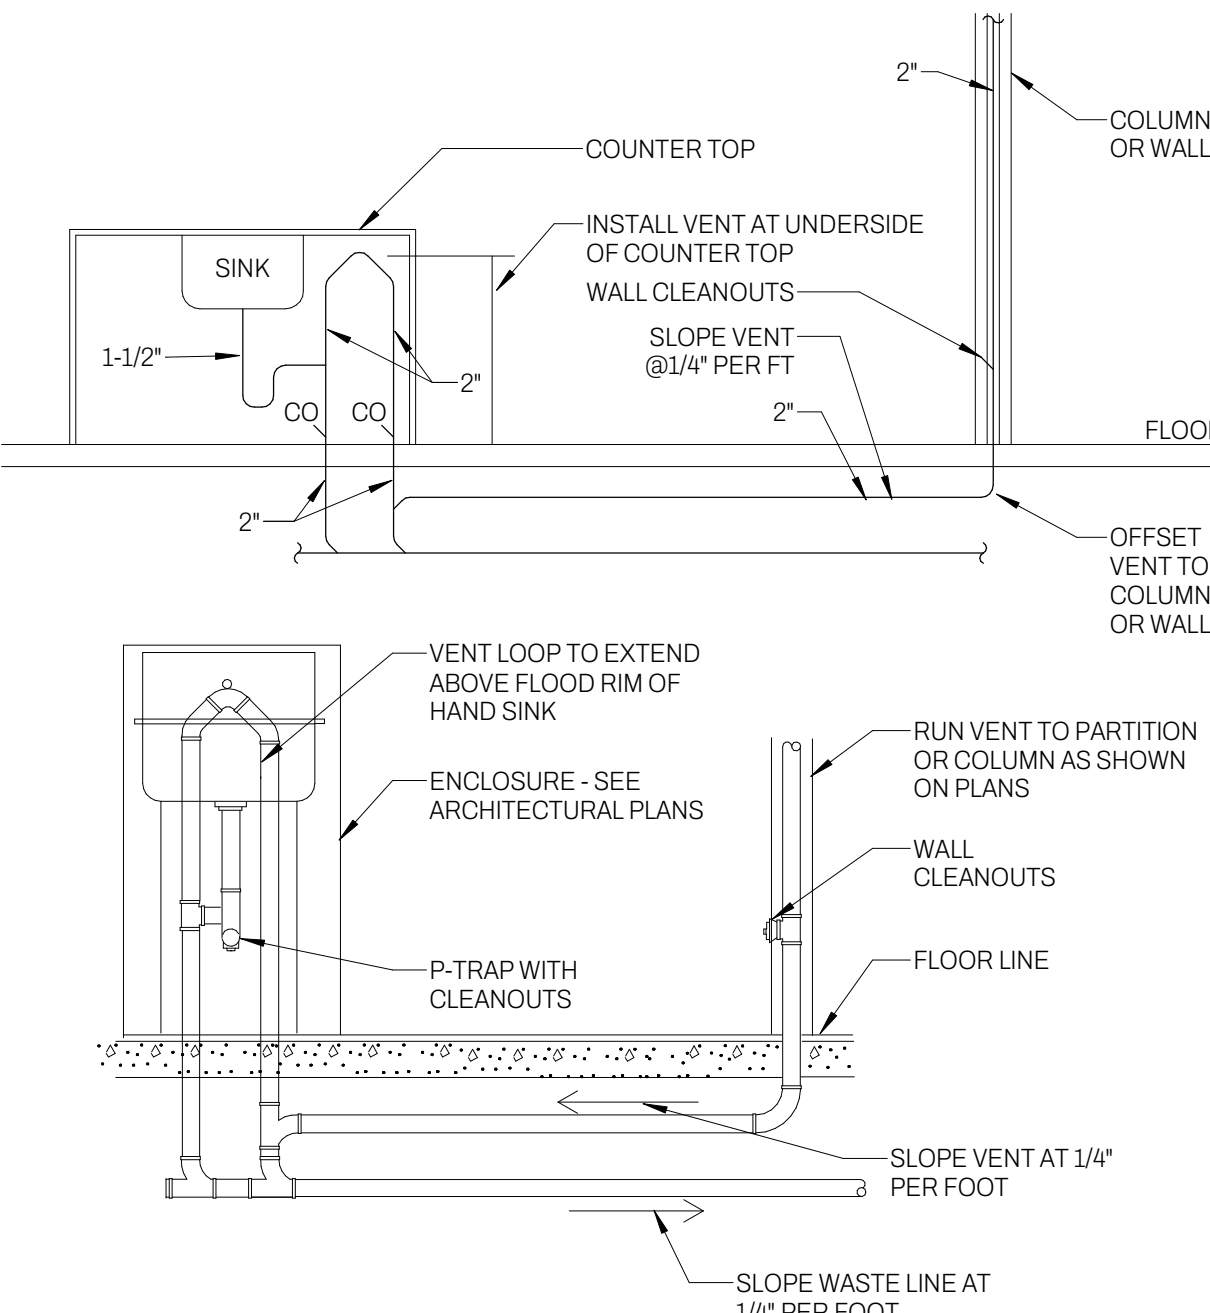

3 ISLAND VENT PIPING DETAIL
P-601.00 NOT TO SCALE

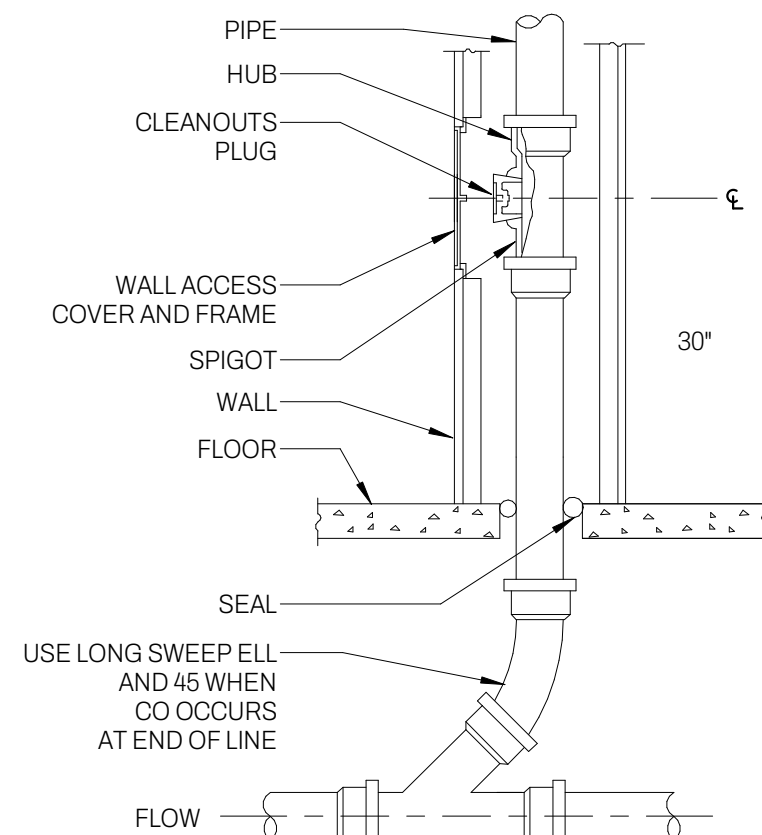

4 WALL CLEAN OUT DETAIL
P-601.00 NOT TO SCALE

- A. IT IS THE RESPONSIBILITY OF THE GENERAL AND PLUMBING CONTRACTOR TO FULLY INSPECT THE SITE PRIOR TO COMMENCEMENT.
- B. VERIFY ALL EXISTING CONDITIONS INCLUDING LOCATION OF ALL STRUCTURAL ELEMENTS, BAR JOISTS, COLUMNS, ETC. AND COORDINATE PIPING SYSTEMS AND LOCATIONS ACCORDINGLY.

MARIN
ARCHITECTS

57W 38TH ST LVL 10 NEW YORK NY 10018
212 463 8480 INFO@MARINARCHITECTS.COM

Contractor
CTS Builders

Structural Engineer
Penn Fusion Engineering

MEP Engineering
Wolf Engineering




P.O. BOX 38 | DALTON, GA 30722

09/02/25	FILING SET	
08/25/25	90% REVIEW	

NO COPIES, TRANSMISSIONS, REPRODUCTIONS, OR ELECTRONIC REVISIONS OF ANY PORTIONS OF THESE DRAWINGS IN WHOLE OR IN PART BE MADE WITHOUT THE EXPRESS WRITTEN PERMISSION OF MARIN ARCHITECTS. ALL DESIGNS INDICATED IN THESE DRAWINGS ARE PROPERTY OF MARIN ARCHITECTS. ALL COPYRIGHTS RESERVED © 2019.

KEY PLAN

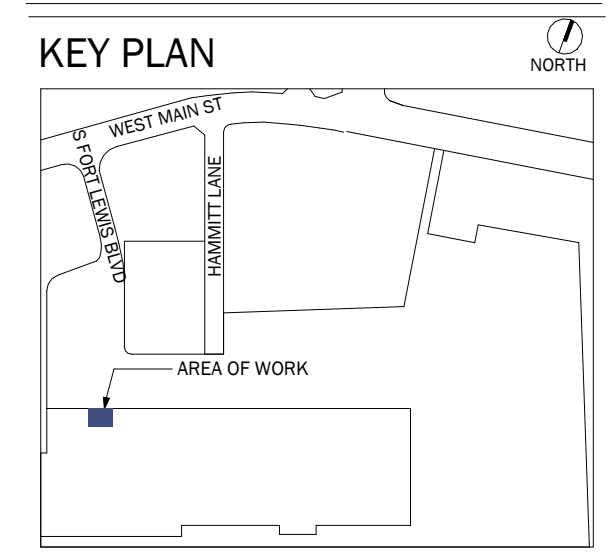

CLIENT:

PROJECT NAME:

US FOODS MEZZANINE RENOVATION

PROJECT ADDRESS:

40 S FORT LEWIS BLVD
SALEM, VA 24153

DWG TITLE:

PLUMBING - RISER DIAGRAM

