 


ORIGINAL USE ARCHITECT (BMA) 4/13/2024 10:11:35 AM
C:\Users\josh\Documents\3114_Webb\3114_Webb.dwg - P101.dwg



LOWER LEVEL FLOOR PLAN - PLUMBING
SCALE: 1/8" = 1'-0"



SPECTRUM DESIGN
architects | engineers

Plaza Suite 1
10 Church Avenue, SE
Roanoke, VA 24011

540.342.4001
spectrumpc.com




LAWRENCE PERRY & ASSOCIATES
Consulting Engineers

15 E Salem Avenue SE, Suite 101
Roanoke, Virginia 24011
Ph: (540) 342-1818
Fax: (540) 344-3410
Curren No.: 25114
© Lawrence Perry and Associates, Inc.

**DEPARTMENT OF SOCIAL
SERVICES BUILDING**

BEDFORD COUNTY

SPECTRUM DESIGN PROJECT NO.: **24112**

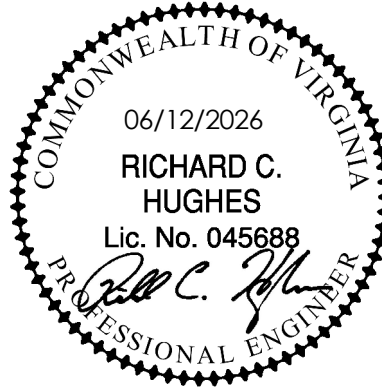

PROJ. MGR.: **RCH** CHECKED BY: **MGW** DRAWN BY: **CAD**

SHEET ISSUE DATE:

06.12.2026

PROJECT PHASE:

BID DOCUMENTS

SHEET REVISIONS:



SHEET NAME:

**LOWER LEVEL FLOOR
PLAN - PLUMBING**


SHEET NUMBER:

P101

ORIGINAL USE ARCHITECT (BMA) 4/12/2024 10:31:38 AM
C:\Users\josh\Documents\3114_Webb\0305-111001_125_cad\p102



MAIN LEVEL FLOOR PLAN - PLUMBING
SCALE: 1/8" = 1'-0"

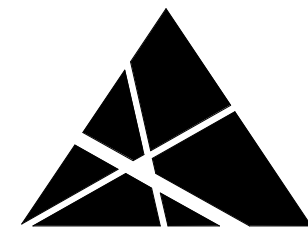

SPECTRUM DESIGN
architects | engineers

Plaza Suite 1
10 Church Avenue, SE
Roanoke, VA 24011

540.342.4001
spectrumpc.com




LAWRENCE PERRY & ASSOCIATES
Consulting Engineers

15 E Salem Avenue SE, Suite 101
Roanoke, Virginia 24011
Ph: (540) 342-1818
Fax: (540) 344-3410
Comm. No.: 25114
© Lawrence Perry and Associates, Inc.

**DEPARTMENT OF SOCIAL
SERVICES BUILDING**

BEDFORD COUNTY

SPECTRUM DESIGN PROJECT NO.: **24112**

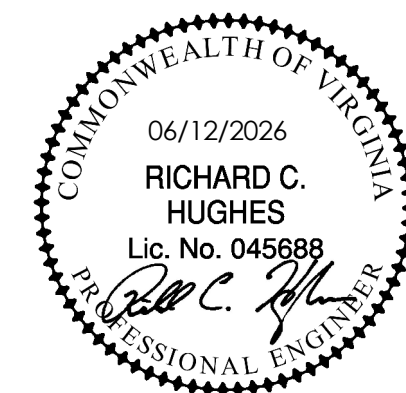

PROJ. MGR.: **RCH** CHECKED BY: **MGW** DRAWN BY: **CAD**

SHEET ISSUE DATE:
06.12.2026

PROJECT PHASE:
BID DOCUMENTS

SHEET REVISIONS:



SHEET NAME:
**MAIN LEVEL FLOOR
PLAN - PLUMBING**

SHEET NUMBER:

P102





1. LOCKING RECESSED HOSE BIBB


P201



ORIGINAL SIZE : ARCH E1 (30042) | 6/15/2026 10:23:46 AM
 C:\Users\cad\Documents\251114 - Bedford DSS - PH1198 - R26 orderfor 01



540.342.6001
spectrumpc.com

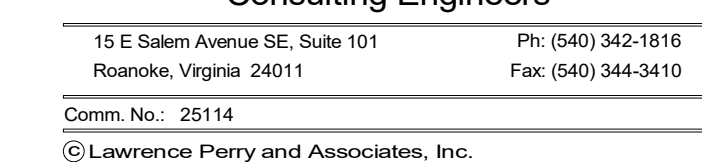

BEDFORD COUNTY

SPECTRUM DESIGN PROJECT NO.: **24112**

SHEET NUMBER:

P202