

VERIFIED BY PLUMBING CONTRACTOR BEFORE ANY PIPING


- PLUMBING FOUNDATION PLAN - FIRST FLOOR AREA C

HOT WATER RETURN ——DHWR——

FL E V	- ELEVATION	SI	- SOLIDS INTERCEPTOR
--------	-------------	----	----------------------

ELEVATION, SECTION, OR
DETAIL IS TAKEN DRAWING NUMBER
WHERE ELEVATION



5

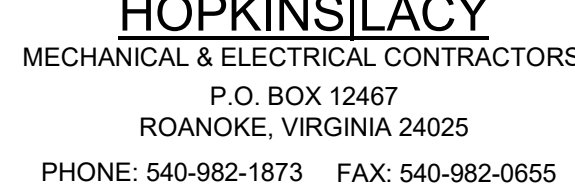

2025-01-01
DR
DR
DN

C
* /

EC

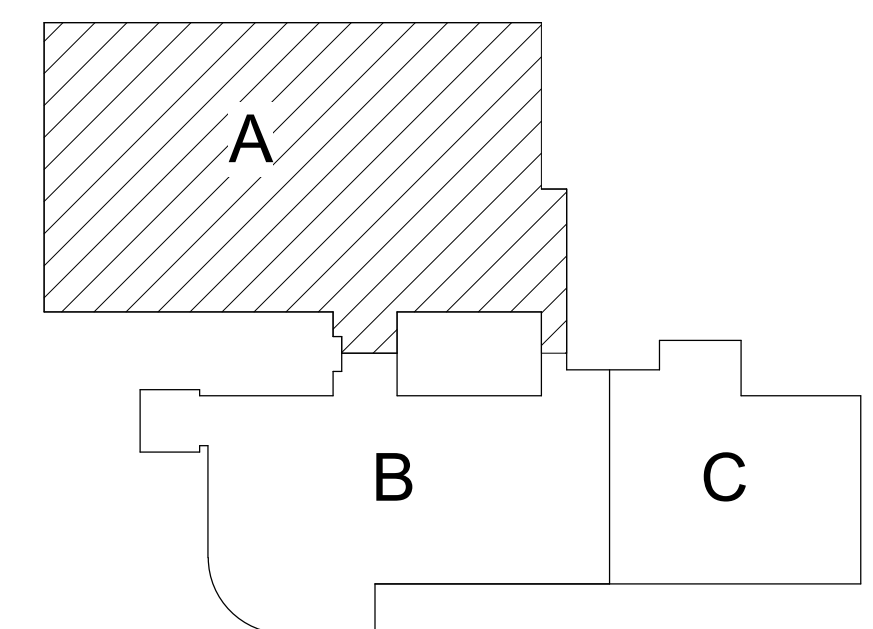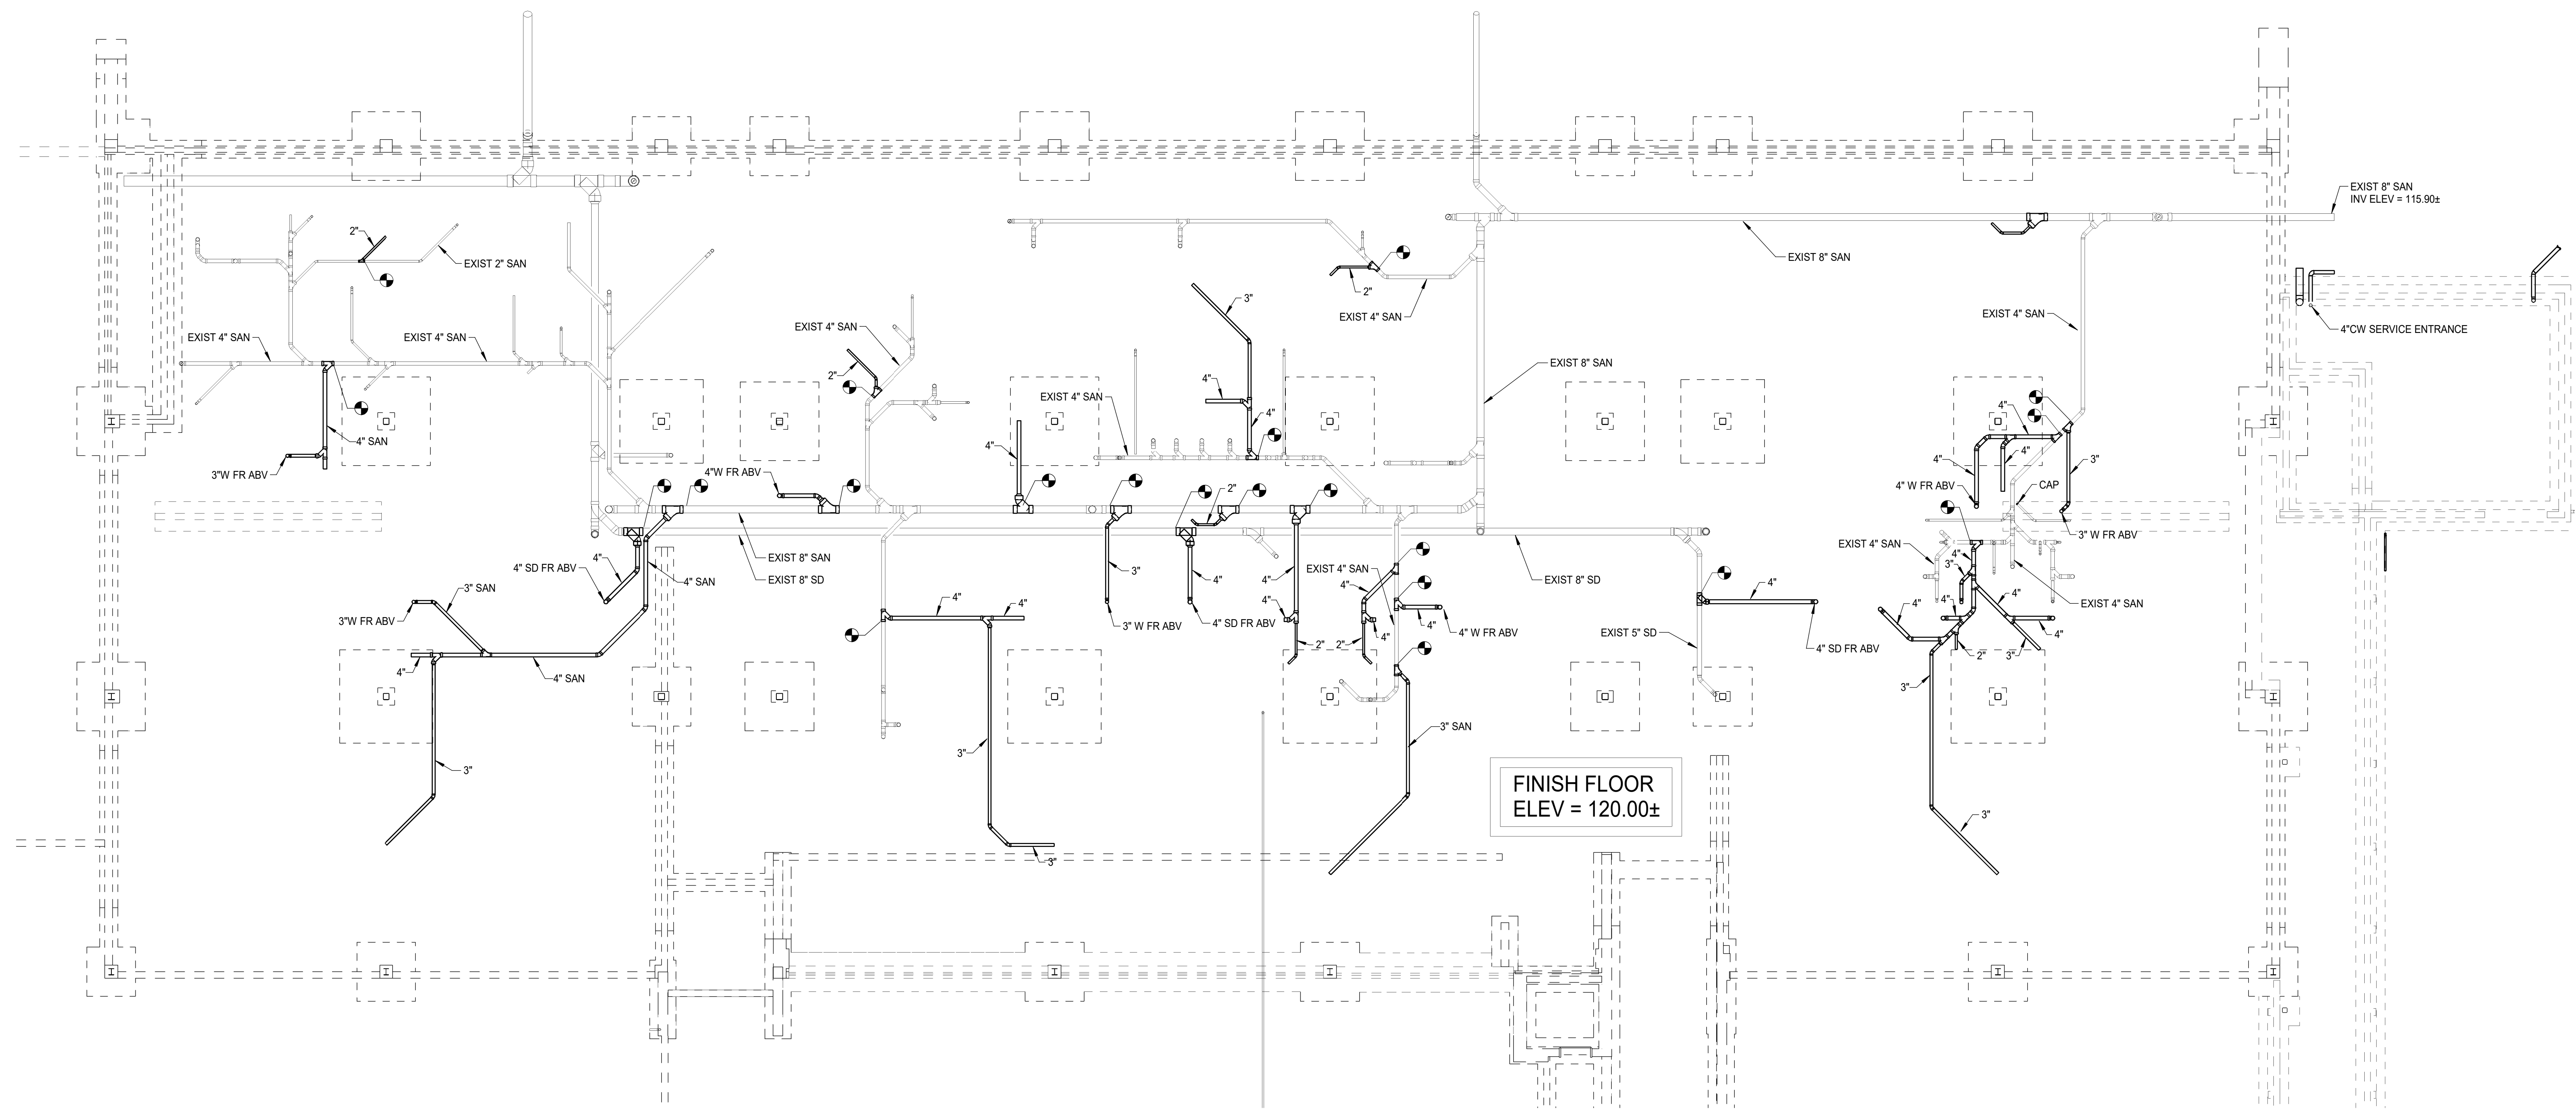

KEY PLAN AREA A

NOT TO SCALE

1
P-101 PLUMBING FOUNDATION PLAN - FIRST FLOOR AREA A
SCALE: 1/8" = 1'-0"



HOPKINS|LACY
MECHANICAL & ELECTRICAL CONTRACTORS
P.O. BOX 12467
ROANOKE, VIRGINIA 24025
PHONE: 540-982-1873 FAX: 540-982-0655

PROJECT: W.E. CONDIFF ELEMENTARY SCHOOL ADDITIONS AND RENOVATIONS
 ROANOKE COUNTY PUBLIC SCHOOLS
 1200 HARDY RD
 VINTON, VA
 DRAWING: PLUMBING FOUNDATION PLAN - FIRST FLOOR AREA A

SHEET

P-101


ASCENT
ENGINEERING GROUP
5225 VALLEYPONTE PKWY, SUITE 4
ROANOKE, VIRGINIA 24019
(540) 265-4444
DWR 23900 C: --



DATE	PROJECT	23125-01	03/22/2024
	DESIGNED	DRV	
	DRAWN	DRV	
	CHECKED	DNL	



*NOT*FOR*CONSTRUCTION*

MARK	DATE	BY	DESCRIPTION

3/20/2024 4:12:51 PM Autodesk Docs\\23125-01 ROPS WE Condif ES23900 MEP Central v2.dwg

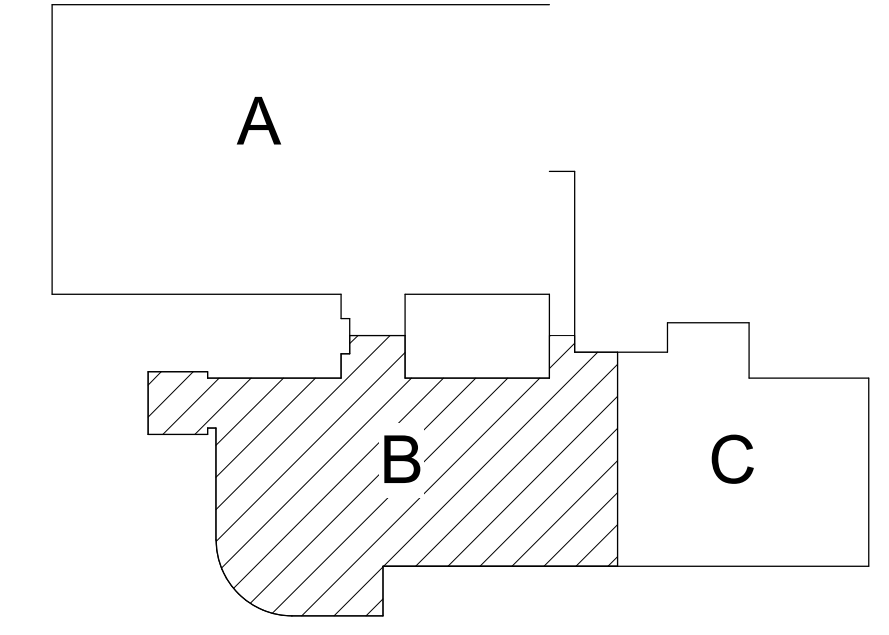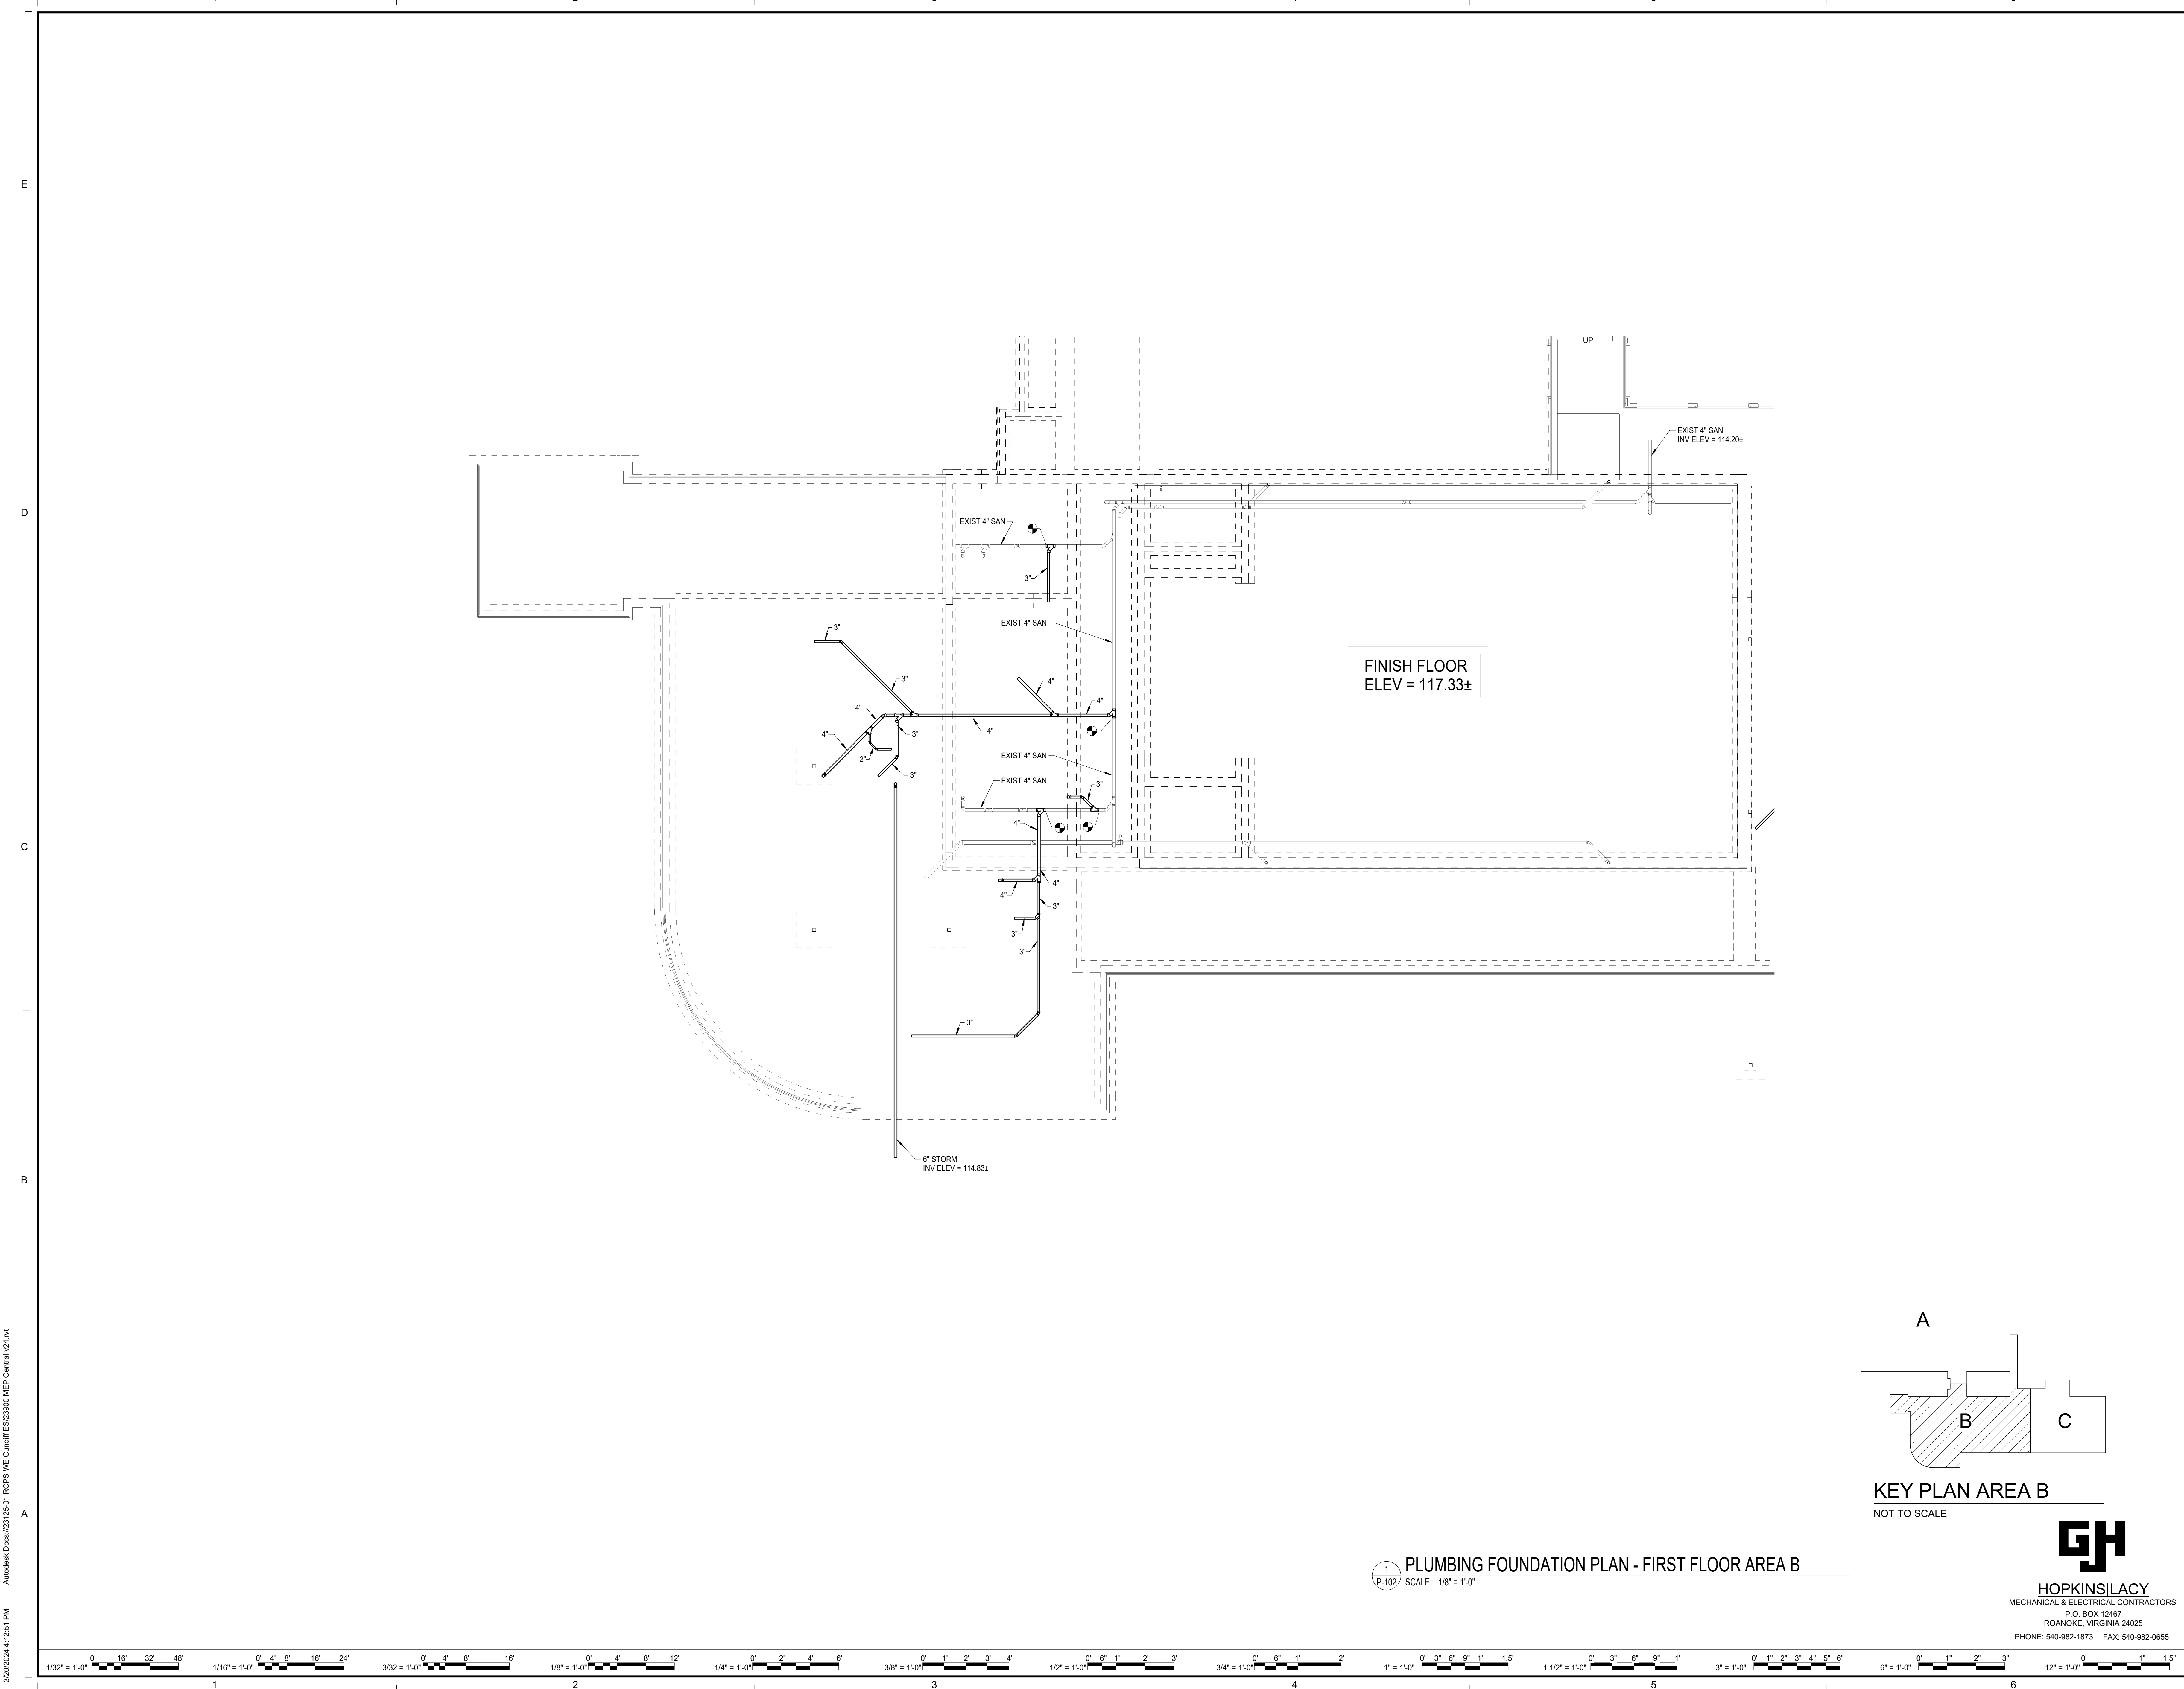

KEY PLAN AREA B
NOT TO SCALE

1 PLUMBING FOUNDATION PLAN - FIRST FLOOR AREA B
P-102 SCALE: 1/8" = 1'-0"



HOPKINS LACY
MECHANICAL & ELECTRICAL CONTRACTORS
P.O. BOX 12467
ROANOKE, VIRGINIA 24025
PHONE: 540-982-1873 FAX: 540-982-0655

REVISIONS		DESCRIPTION
MARK	DATE	BY

ASCENT
ENGINEERING GROUP
5528 VALLEYPOINTE PKWY, SUITE 4
ROANOKE, VIRGINIA 24019
(540) 265-4444
D.DWR 23900 C. ---

DATE	03/22/2024	PROJECT	23125-01	DRY	DRY	DNL
DESIGNED		DRAWN		CHECKED		

RRMM
ARCHITECTS, PC
28 Church Ave SW
Roanoke, Virginia 24011
(540)344-1212



NOT FOR CONSTRUCTION

PROJECT: W.E. CUNDIFF ELEMENTARY SCHOOL ADDITIONS AND RENOVATIONS
ROANOKE COUNTY PUBLIC SCHOOLS
1200 HARDY RD
VINTON, VA

DRAWING: PLUMBING FOUNDATION PLAN - FIRST FLOOR AREA B

SHEET
P-102

3/20/2024 4:12:55 PM Autodesk Docs\\23125-01 ROPS WE Cusdiff ES\\23900 MEP Central v2.dwg

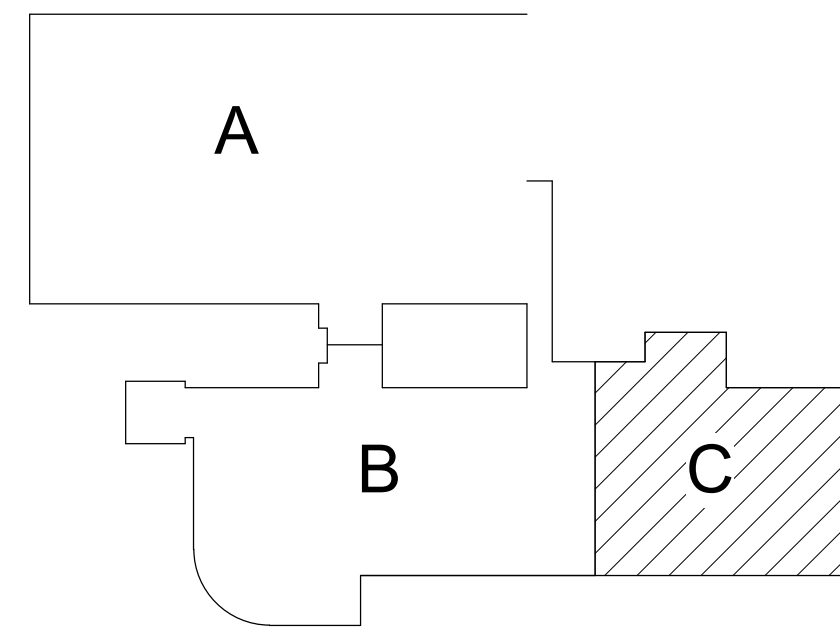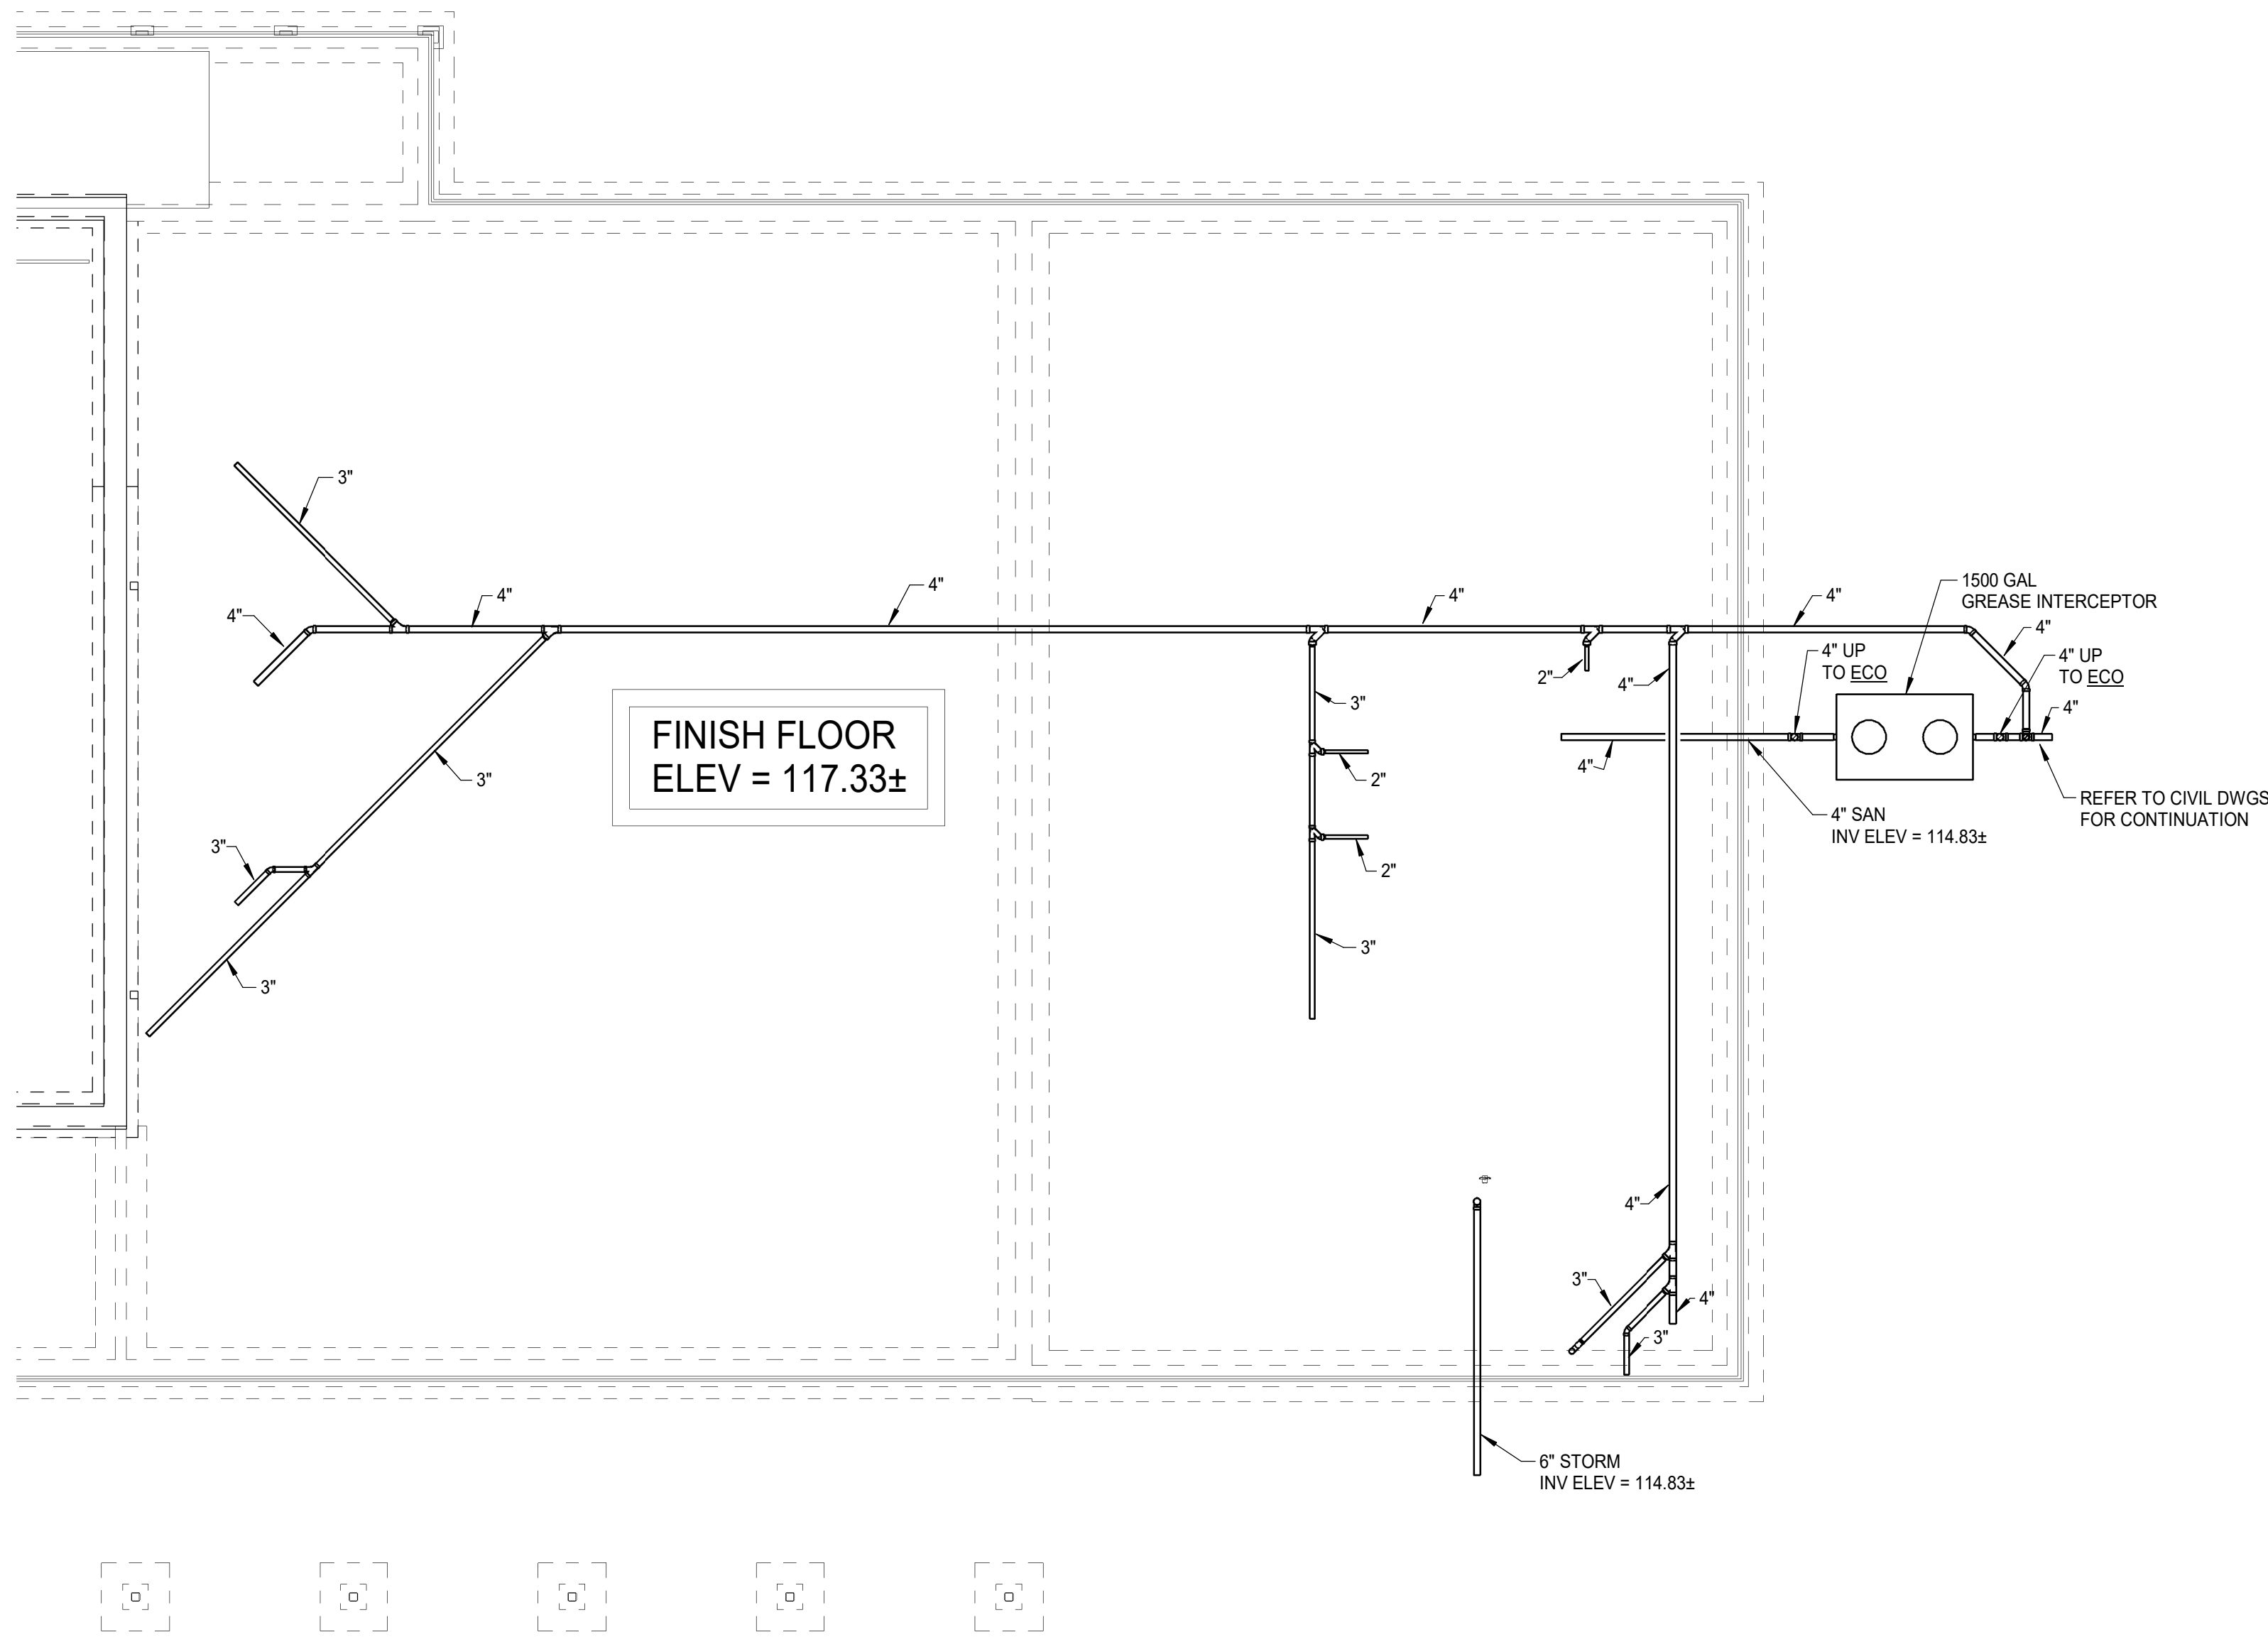

1 PLUMBING FOUNDATION PLAN - FIRST FLOOR AREA C
P-103/ SCALE: 1/8" = 1'-0"

HOPKINSILACY
MECHANICAL & ELECTRICAL CONTRACTORS
P.O. BOX 12467
ROANOKE, VIRGINIA 24025
PHONE: 540-982-1873 FAX: 540-982-0655

PROJECT W.E. CUNDIFF ELEMENTARY SCHOOL ADDITIONS AND RENOVATIONS
ROANOKE COUNTY PUBLIC SCHOOLS
1200 HARDY RD
VINTON, VA
DRAWING PLUMBING FOUNDATION PLAN - FIRST FLOOR AREA C

SHEET
P-103

NOT FOR CONSTRUCTION

RRMM
ARCHITECTS, PC
28 Church Ave SW
Roanoke, Virginia 24011
(540)344-1212





DATE 03/22/2024
PROJECT 23125-01
DESIGNED DRV
DRAWN DRV
CHECKED DNL

ASCENT
ENGINEERING GROUP
5528 VALLEYPOINTE PKWY, SUITE 4
ROANOKE, VIRGINIA 24019
(540) 265-4444
D: 23900 C:

MARK	DATE	BY	DESCRIPTION

3/20/2024 4:13:00 PM Autodesk Docs\\23125-01 ROPS WE Condif ES23900 MEP Central v2.dwg

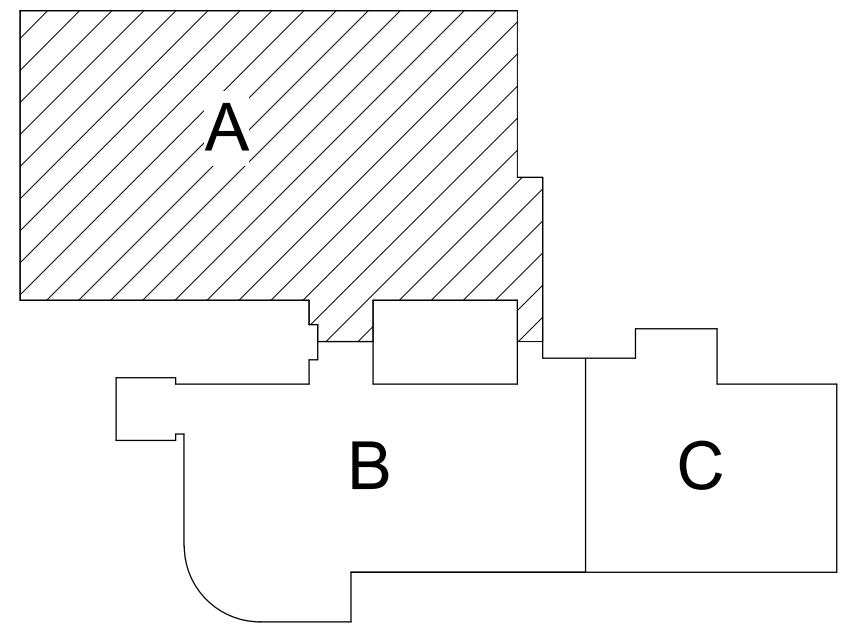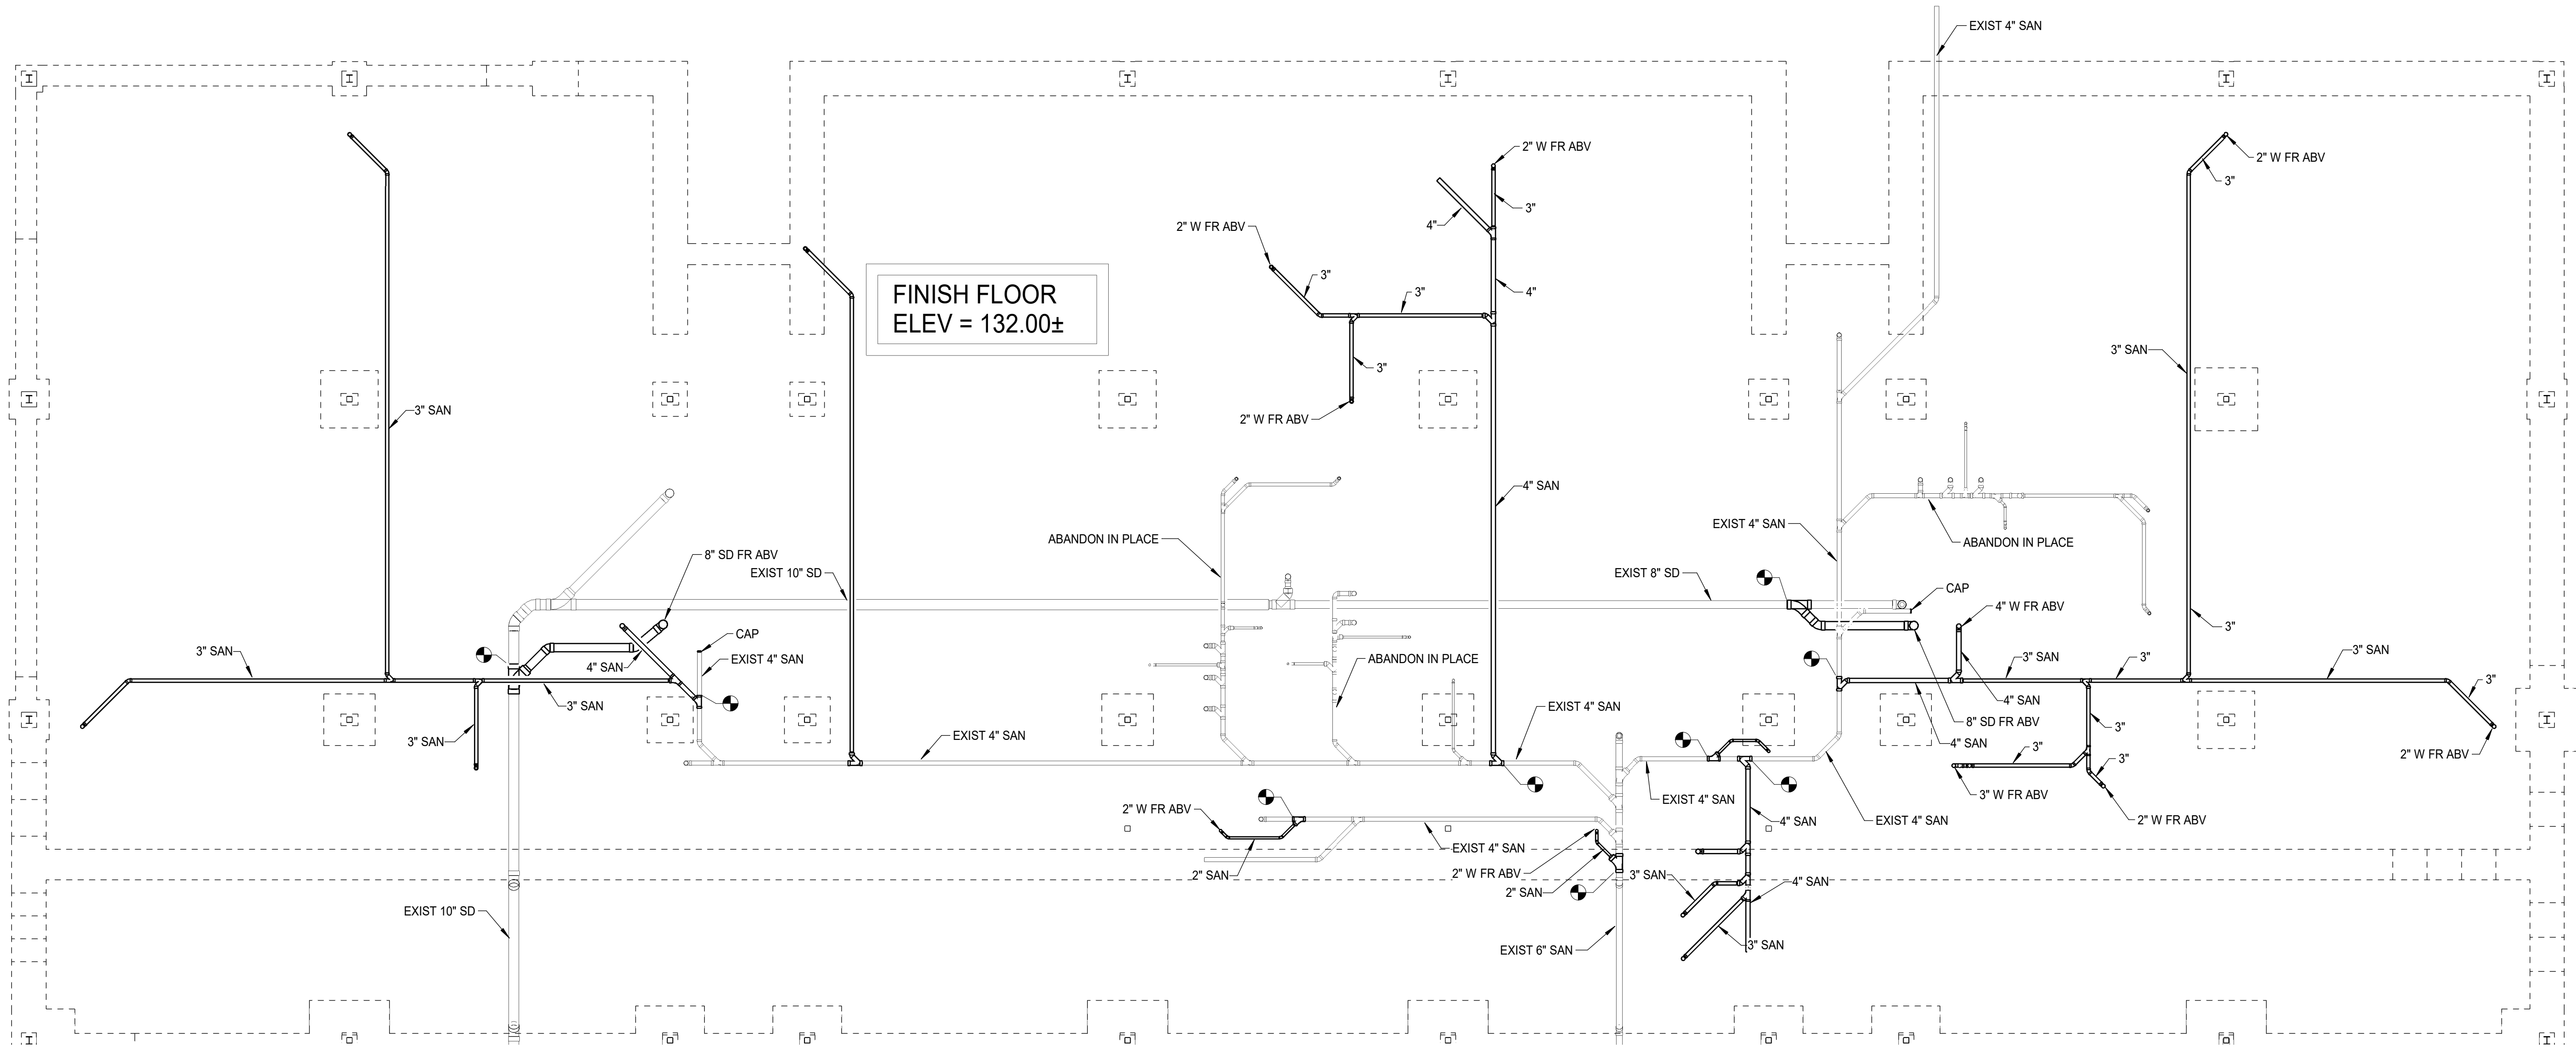

KEY PLAN AREA A
NOT TO SCALE

1
P-104 PLUMBING FOUNDATION PLAN - SECOND FLOOR - AREA A
SCALE: 1/8" = 1'-0"



HOPKINS LACY
MECHANICAL & ELECTRICAL CONTRACTORS
P.O. BOX 12467
ROANOKE, VIRGINIA 24025
PHONE: 540-982-1873 FAX: 540-982-0655

PROJECT W.E. CUNDIFF ELEMENTARY SCHOOL ADDITIONS AND RENOVATIONS
ROANOKE COUNTY PUBLIC SCHOOLS
1200 HARDY RD
VINTON, VA
DRAWING PLUMBING FOUNDATION PLAN - SECOND FLOOR AREA
A

SHEET
P-104




RRMM
ARCHITECTS, PC
28 Church Ave SW
Roanoke, Virginia 24011
(540)344-1212

DATE	PROJECT	DESIGNED	DRAWN	CHECKED
03/22/2024	23125-01	DRV	DRV	DNL

ASCENT
ENGINEERING GROUP
5228 VALLEYPONTE PKWY, SUITE 4
ROANOKE, VIRGINIA 24019
(540) 265-4144
D: DWR 23900 C: ---

REVISIONS	MARK	DATE	BY	DESCRIPTION

3/20/2024 4:13:08 PM Autodesk Docs\\23125-01 ROPS WE Condif ES\\23900 MEP Central v2.dwg

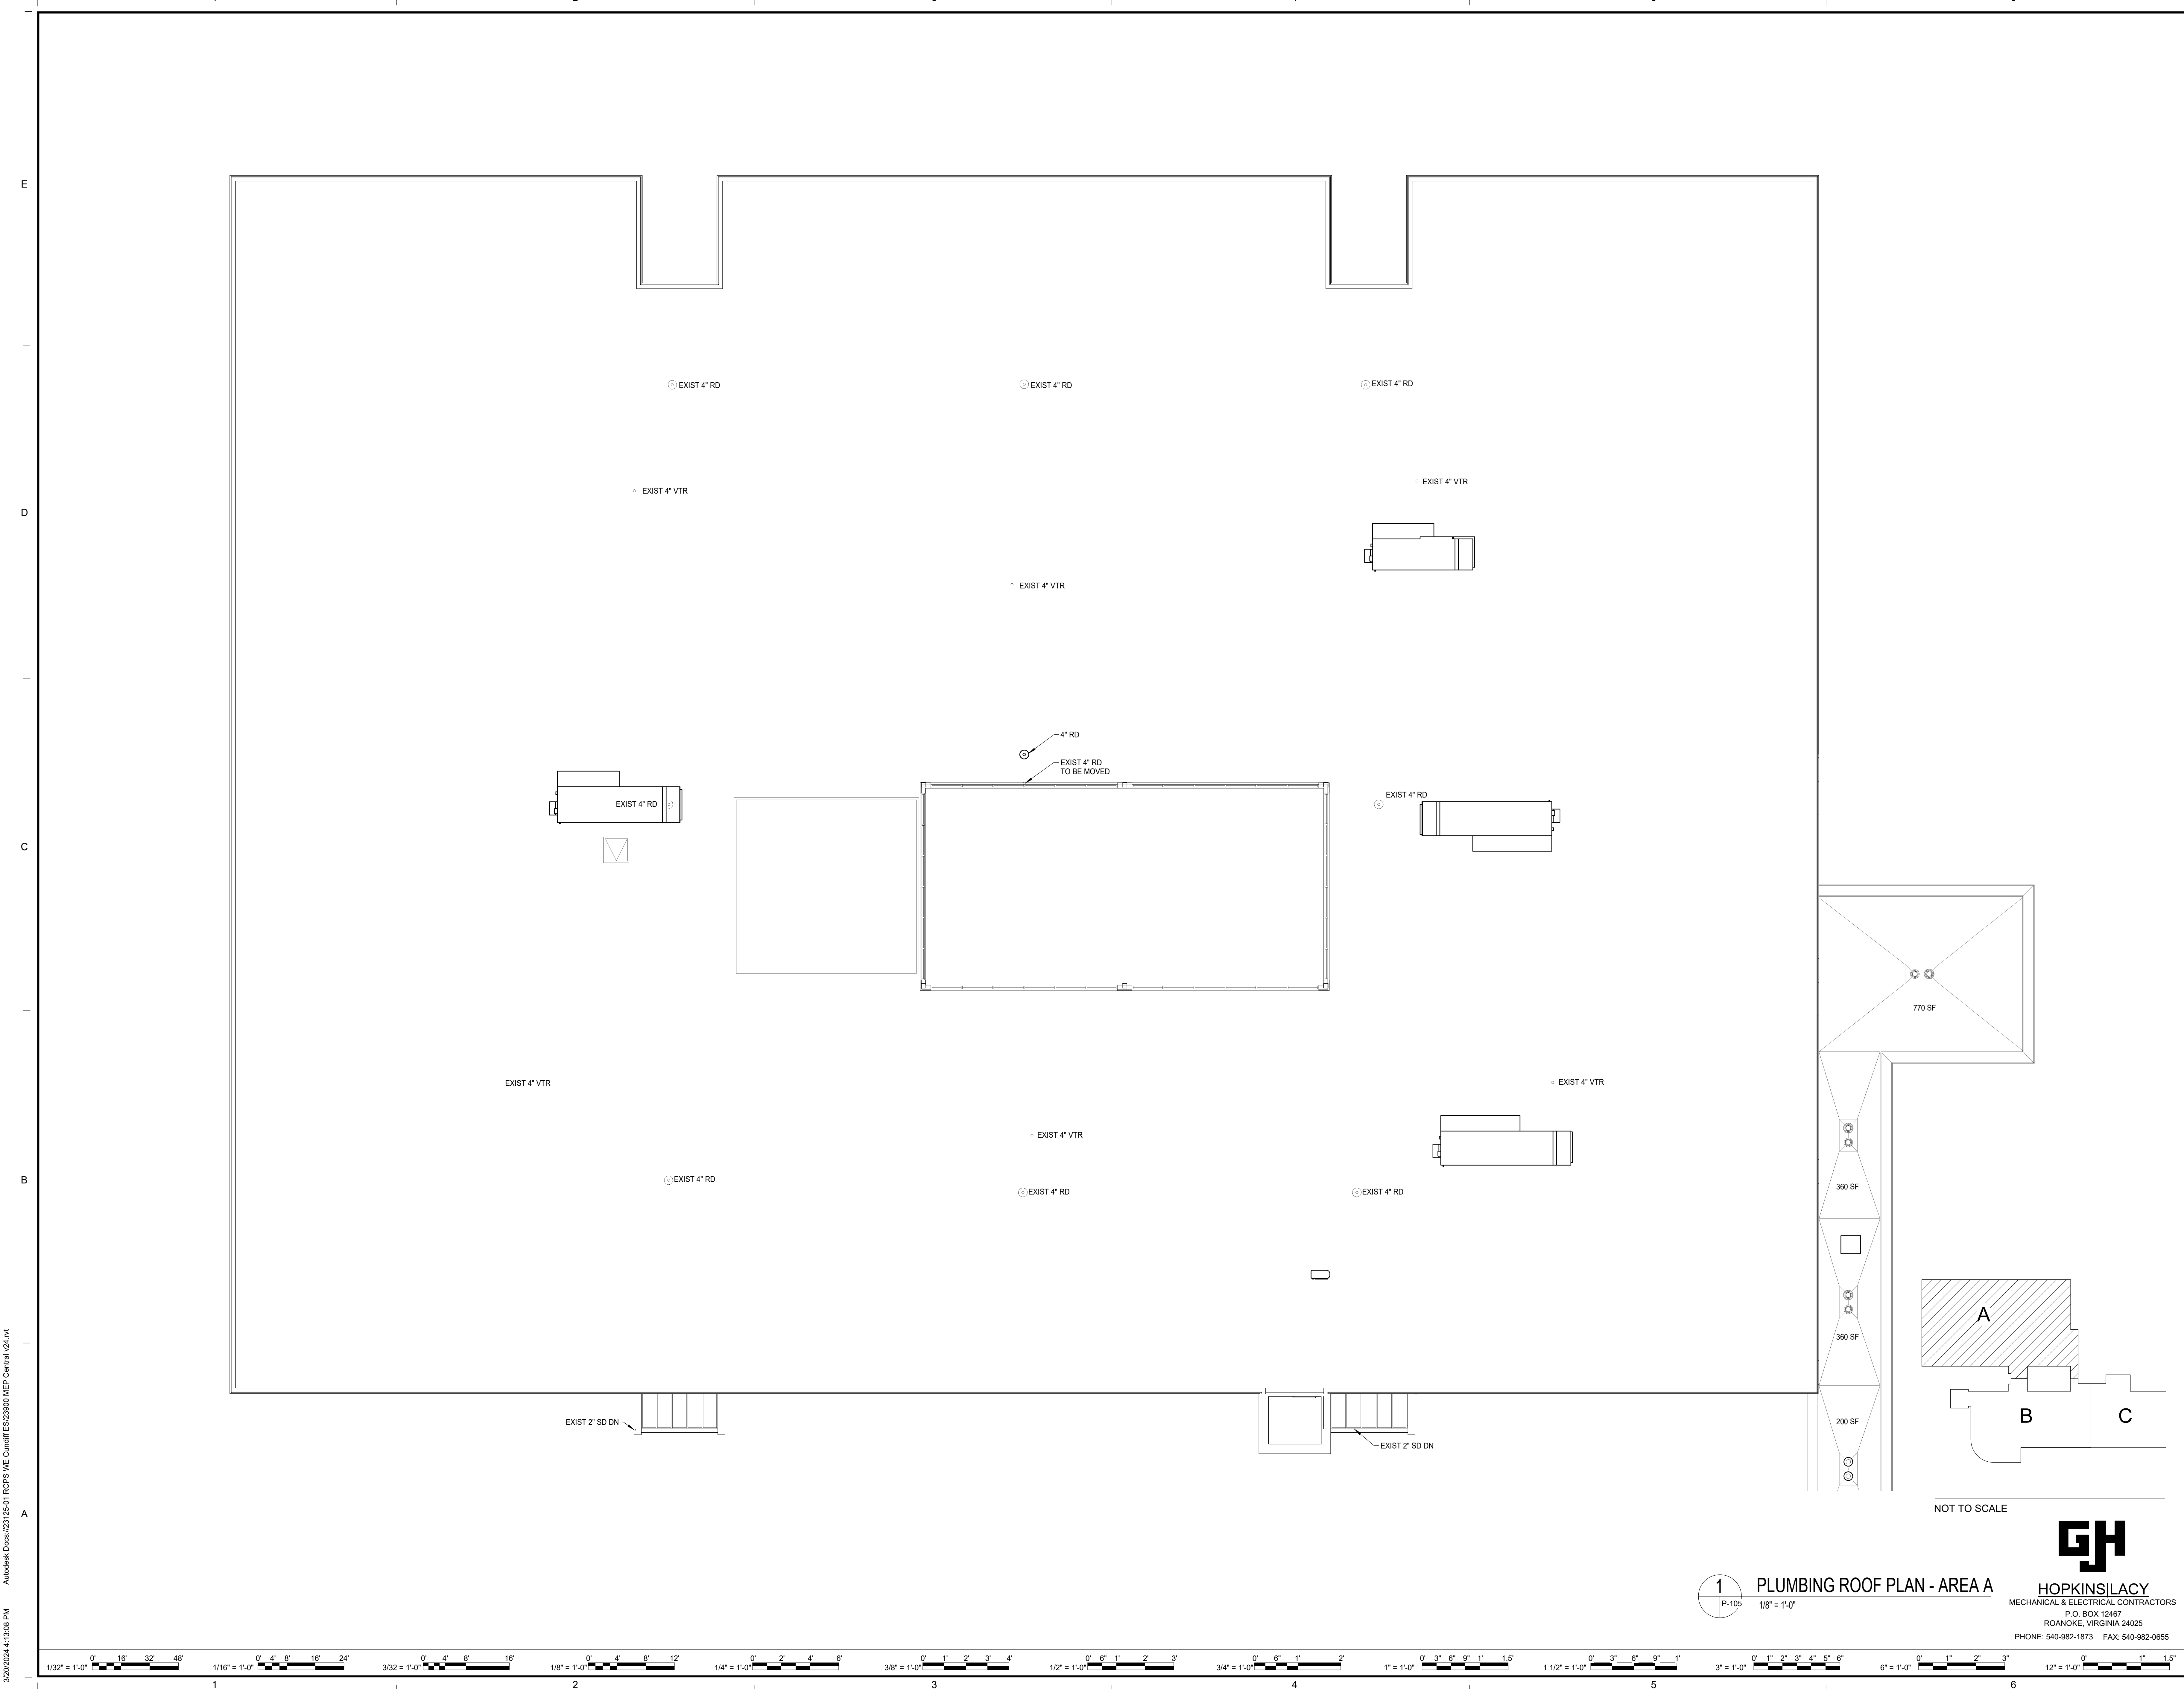

1
P-105

PLUMBING ROOF PLAN - AREA A
1/8" = 1'-0"

HOPKINS LACY
MECHANICAL & ELECTRICAL CONTRACTORS
P.O. BOX 12467
ROANOKE, VIRGINIA 24025
PHONE: 540-982-1873 FAX: 540-982-0655

REVISIONS	
MARK	DATE
BY	DESCRIPTION

5228 VALLEYPOINTE PKWY, SUITE 4
ROANOKE, VIRGINIA 24019
(540) 265-4444

D: 23900 C:

DATE	PROJECT	DESIGNED	DRV	DRAWN	CHECKED	DNL
03/22/2024	23125-01					

28 Church Ave SW
Roanoke, Virginia 24011
(540) 344-1212

NOT FOR CONSTRUCTION



PROJECT: W.E. CUNDIFF ELEMENTARY SCHOOL ADDITIONS AND RENOVATIONS
ROANOKE COUNTY PUBLIC SCHOOLS
1200 HARDY RD
VINTON, VA

DRAWING: PLUMBING ROOF PLAN - AREA A

SHEET

P-105

3/20/2024 4:13:13 PM Autodesk Docs\\23125-01 ROPS WE Condliff ES\\23900 MEP Central v2.dwg

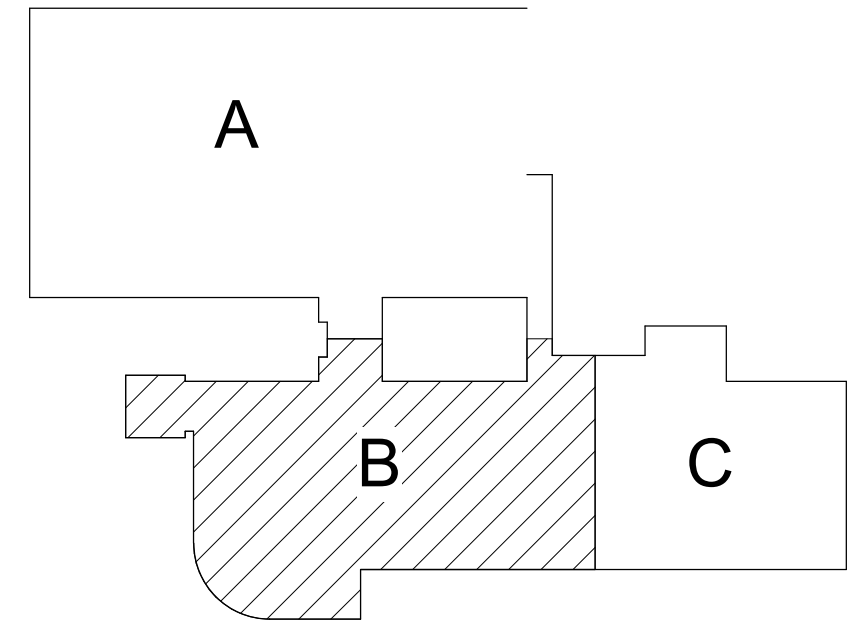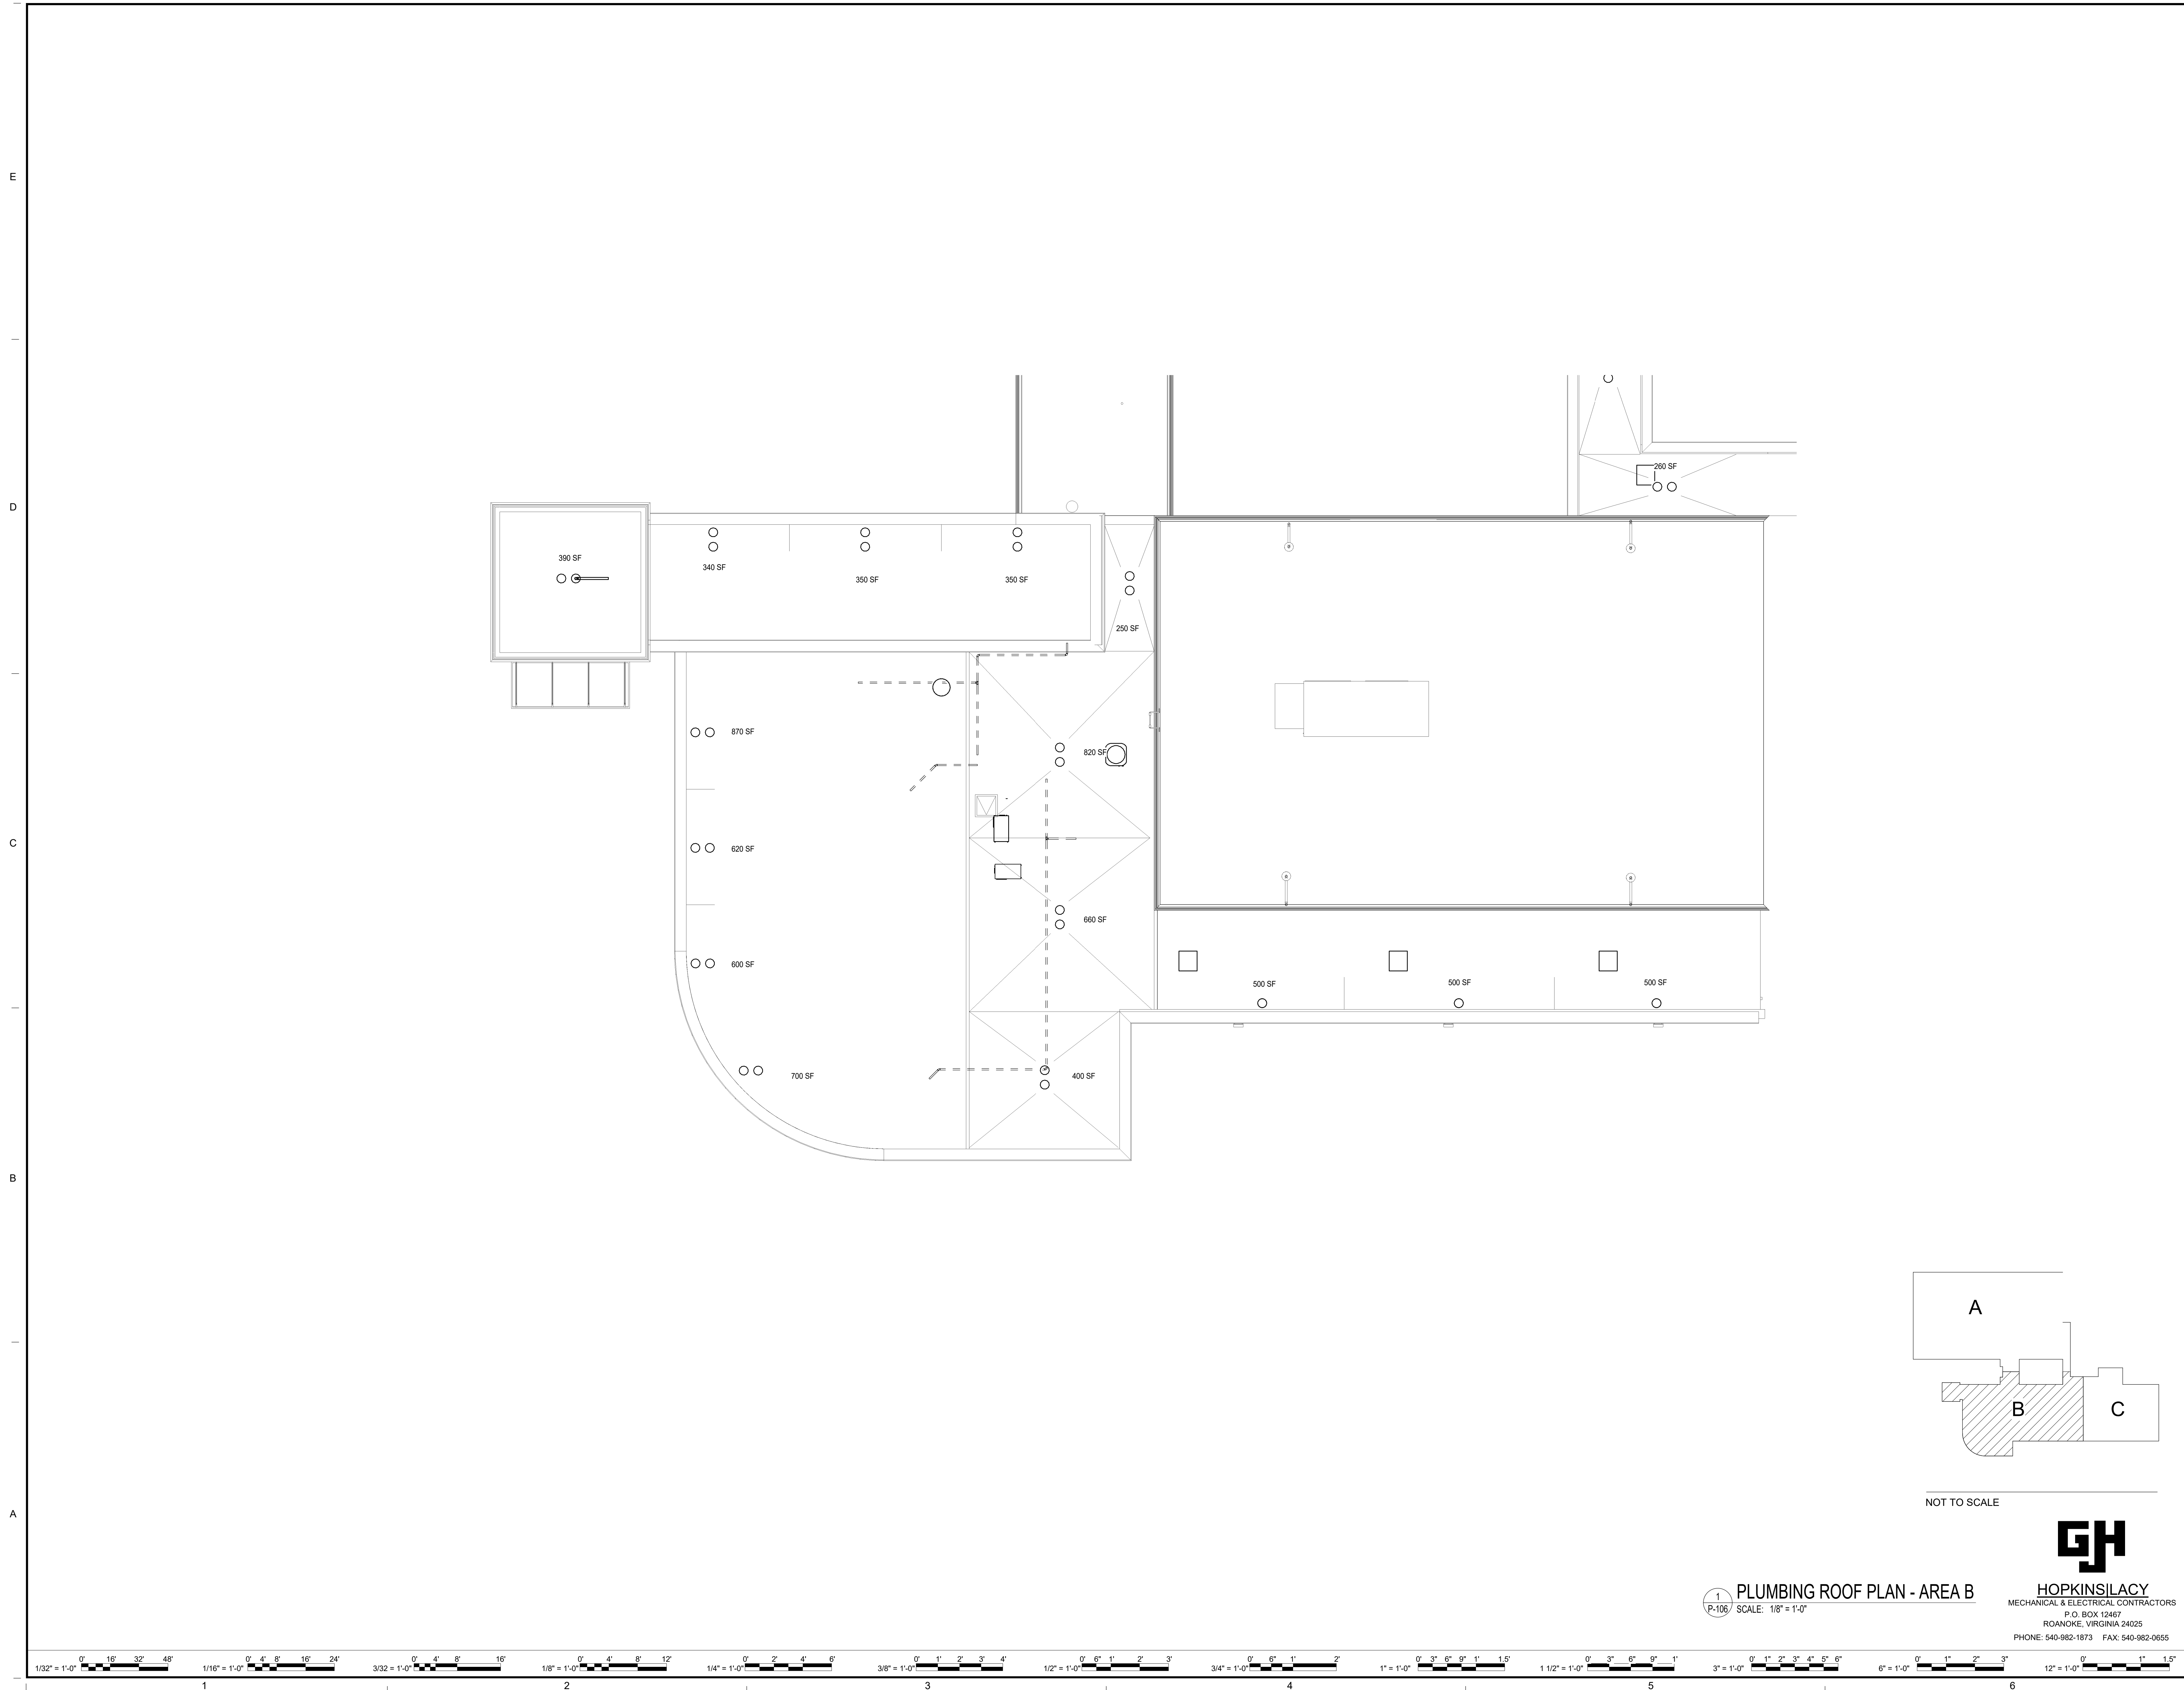

NOT TO SCALE



1 PLUMBING ROOF PLAN - AREA B
P-106/ SCALE: 1/8" = 1'-0"

HOPKINSILACY
MECHANICAL & ELECTRICAL CONTRACTORS
P.O. BOX 12467
ROANOKE, VIRGINIA 24025
PHONE: 540-982-1873 FAX: 540-982-0655




MARK	DATE	DESCRIPTION
BY		
REVISIONS		

ASCENT
ENGINEERING GROUP
5528 VALLEYPOINTE PKWY, SUITE 4
ROANOKE, VIRGINIA 24019
(540) 265-4444
D: 23900 C:

DATE	03/22/2024	PROJECT	23125-01	DRY	DRY	DNL
DESIGNED		DRAWN		CHECKED		

RRMM
ARCHITECTS, PC
28 Church Ave SW
Roanoke, Virginia 24011
(540)344-1212

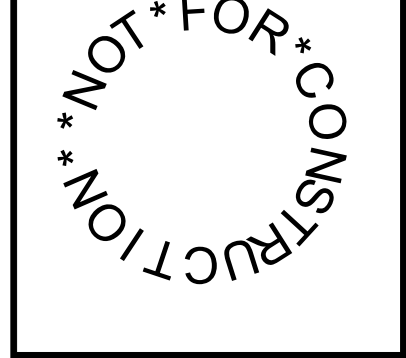



PROJECT W.E. CUNDIFF ELEMENTARY SCHOOL ADDITIONS AND RENOVATIONS
ROANOKE COUNTY PUBLIC SCHOOLS
1200 HARDY RD
VINTON, VA
DRAWING PLUMBING ROOF PLAN - AREA B

SHEET
P-106

3/20/2024 4:13:17 PM Autodesk Docs\\23125-01 ROPS WE Cundiff ES\\23900 MEP Central v2.dwg

A
B
C
D
E

1 2 3 4 5 6

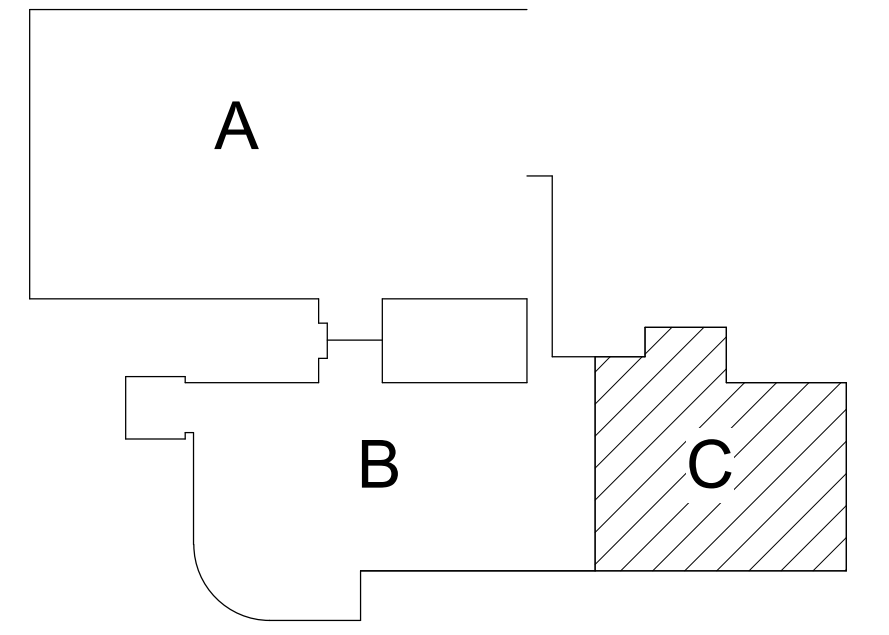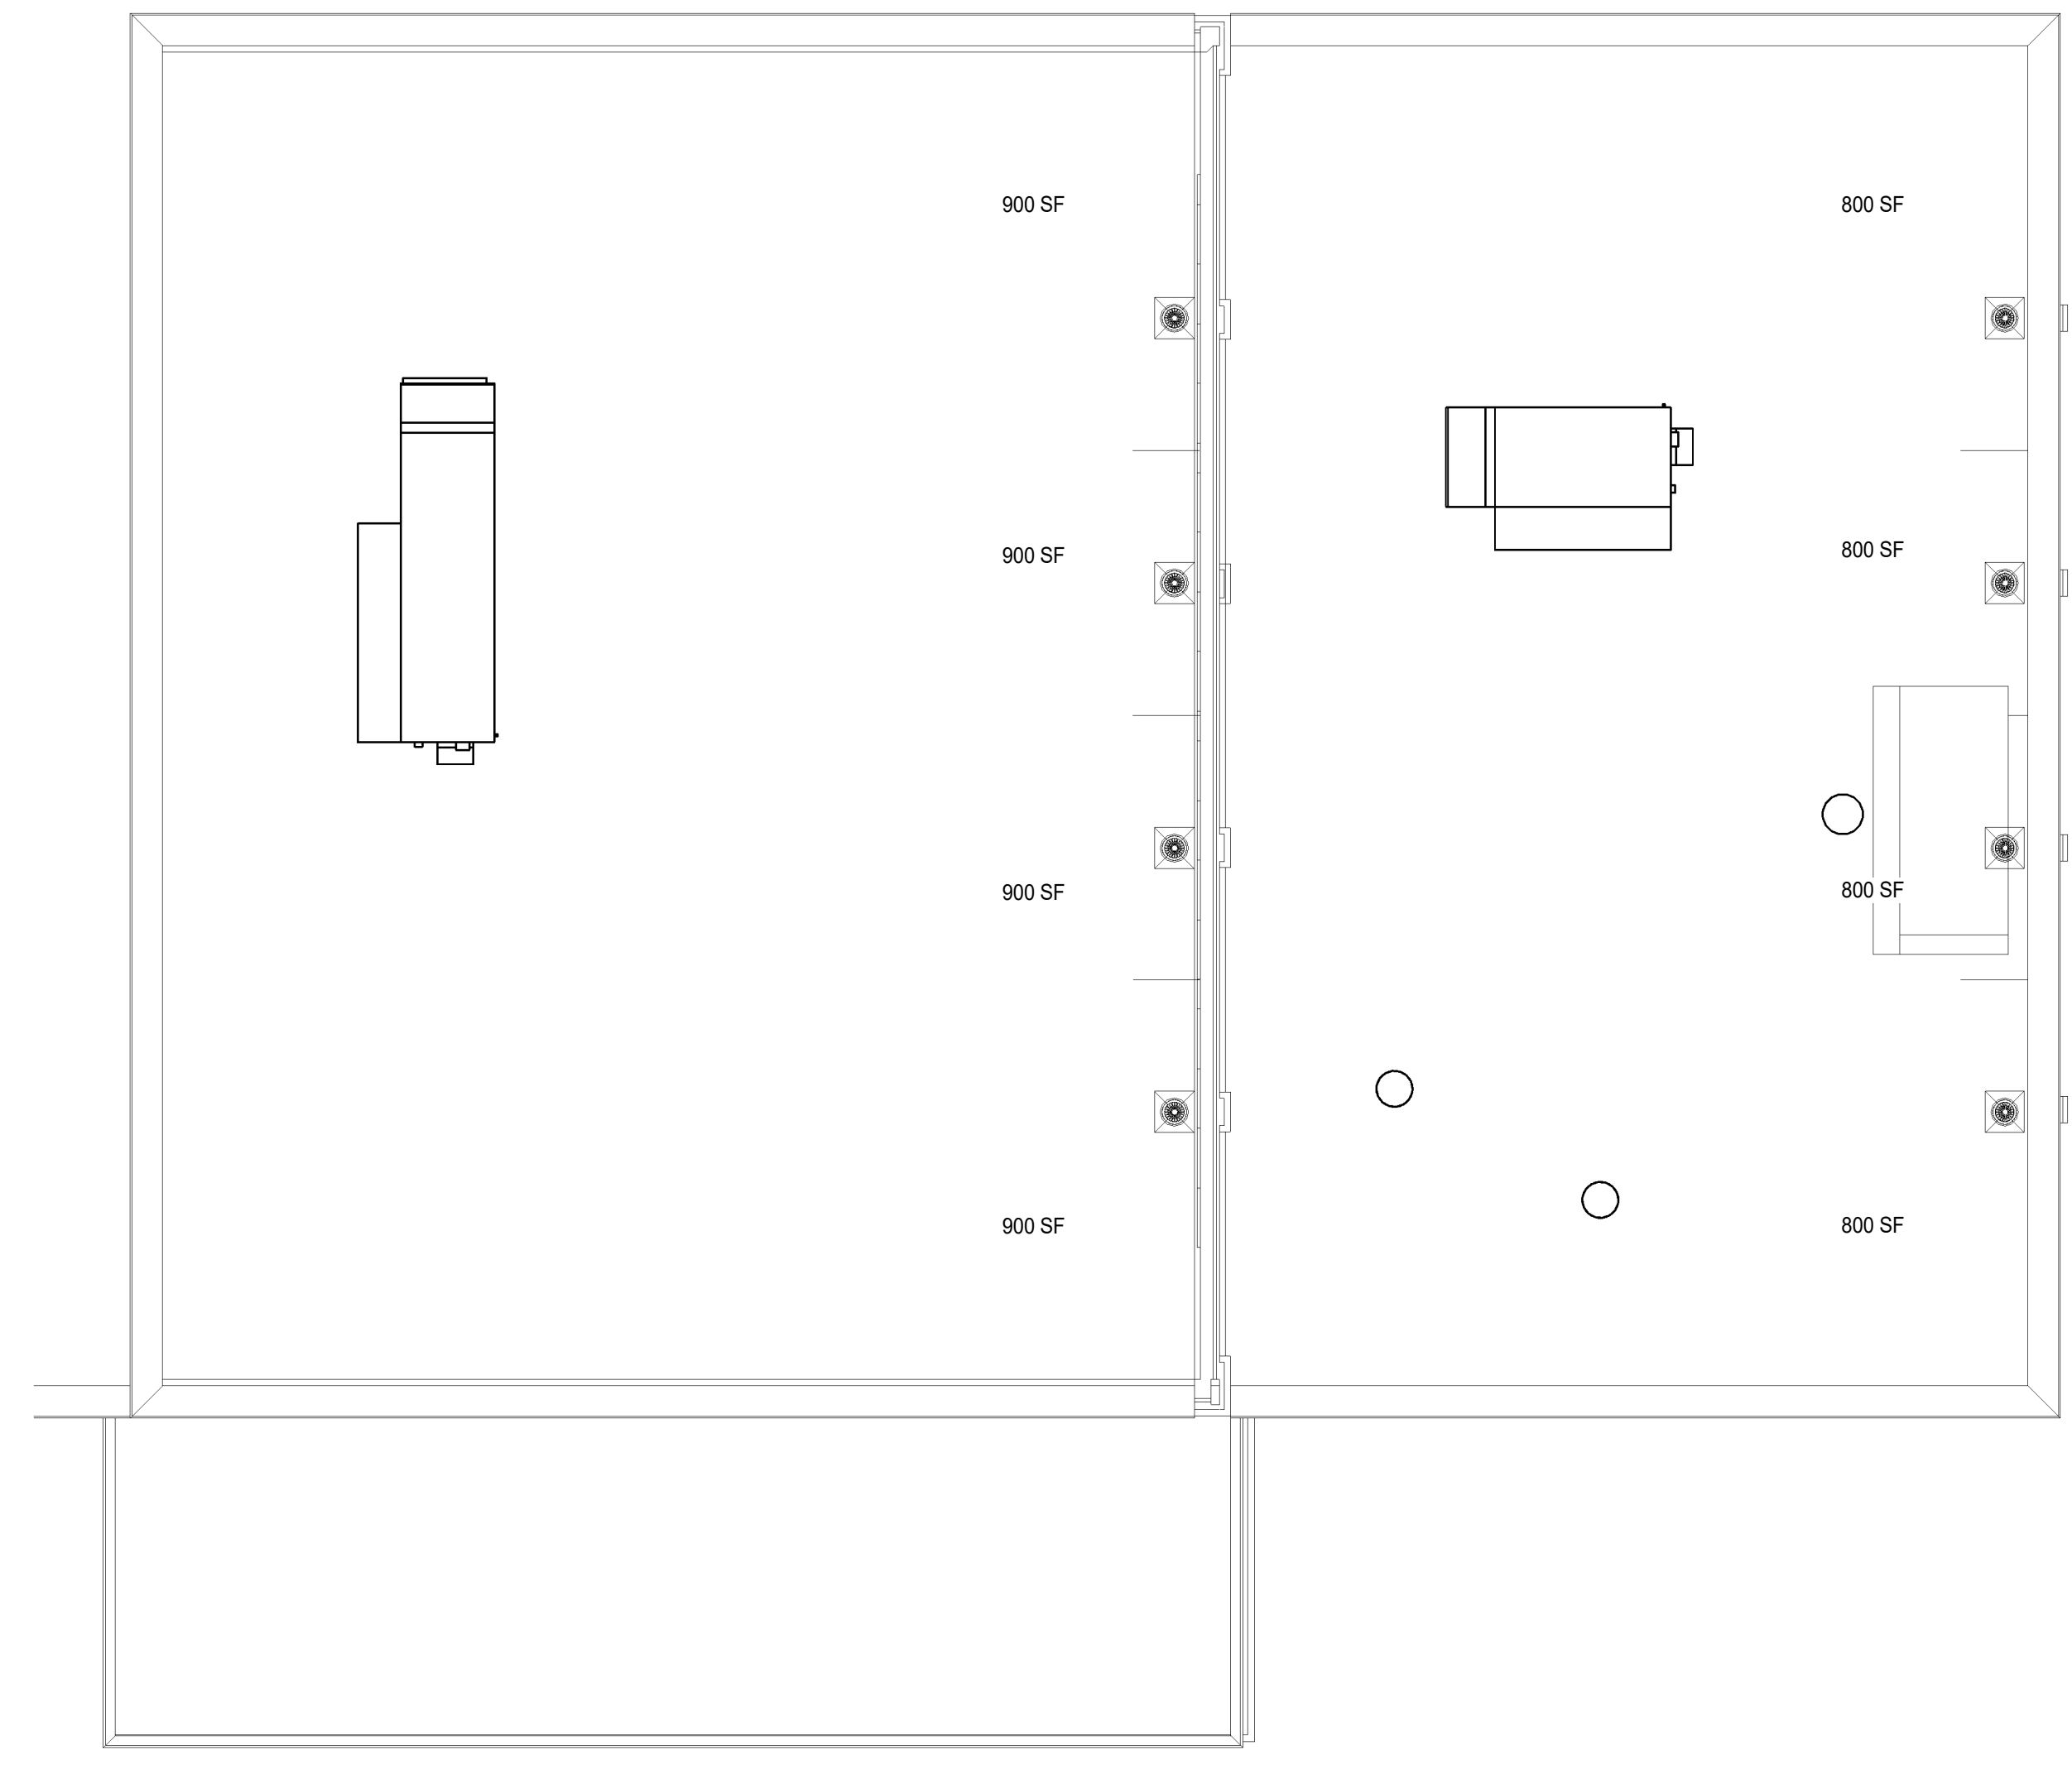

1 PLUMBING ROOF PLAN - AREA C
P-107 SCALE: 1/8" = 1'-0"

HOPKINS LACY
MECHANICAL & ELECTRICAL CONTRACTORS
P.O. BOX 12467
ROANOKE, VIRGINIA 24025
PHONE: 540-982-1873 FAX: 540-982-0655



REVISIONS		DESCRIPTION
MARK	DATE	BY

5228 VALLEYPONTE PKWY, SUITE 4
ROANOKE, VIRGINIA 24019
(540) 265-4444

D: 23900 C:

DATE	03/22/2024	PROJECT	23125-01	DRV	DRV	DNL
DESIGNED		DRAWN		CHECKED		

28 Church Ave SW
Roanoke, Virginia 24011
(540)344-1212



PROJECT W.E. CUNDIFF ELEMENTARY SCHOOL ADDITIONS AND RENOVATIONS
ROANOKE COUNTY PUBLIC SCHOOLS
1200 HARDY RD
VINTON, VA

DRAWING PLUMBING ROOF PLAN - AREA C

SHEET

P-107

3/20/2024 4:24:51 PM Autodesk Docs/123125-01 ROPS WE Condif ES/23900 MEP Central v2.dwg

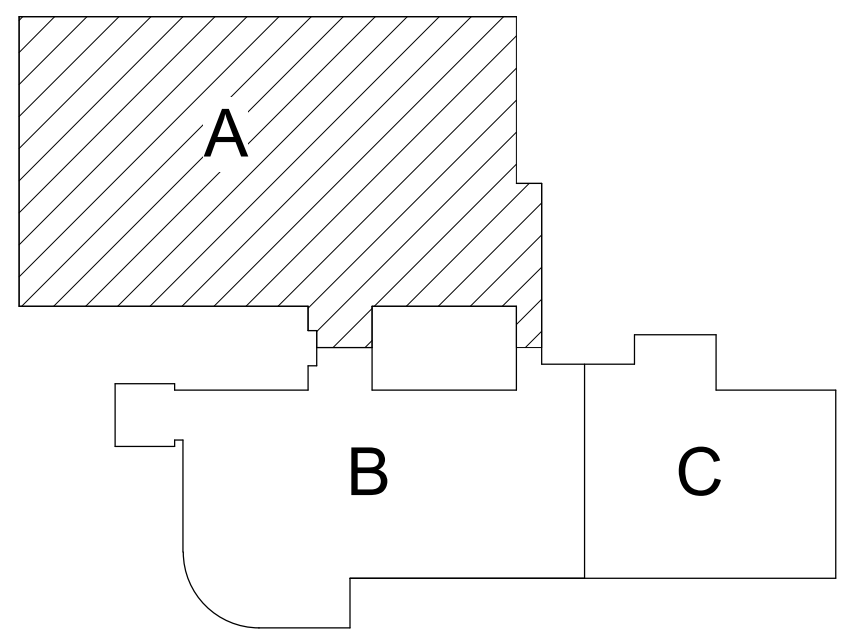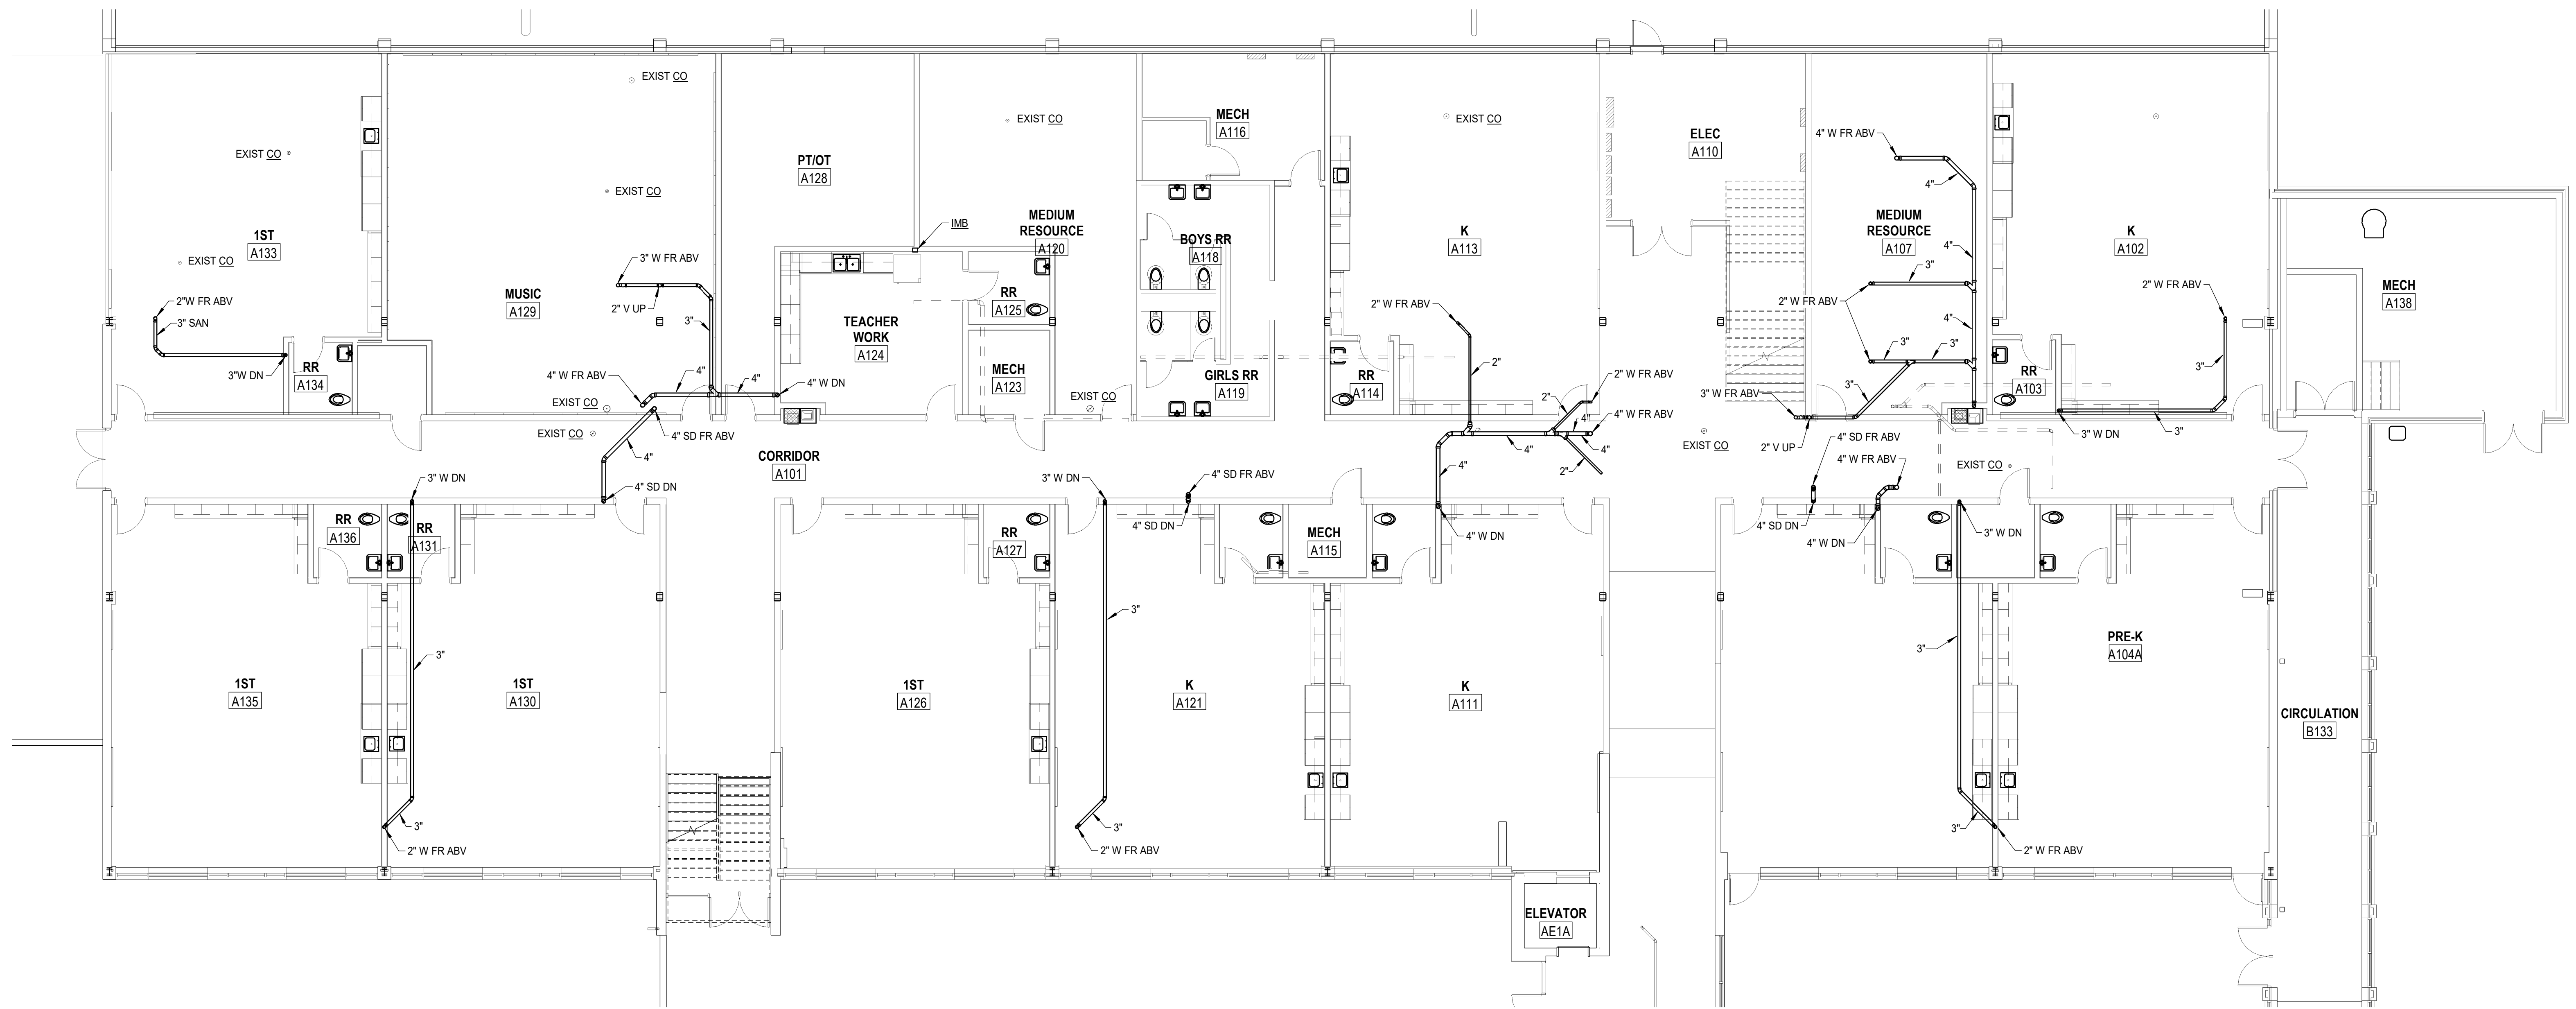

1 PLUMBING SANITARY PLAN - FIRST FLOOR AREA A
P-201 SCALE: 1/8" = 1'-0"



HOPKINS LACY
MECHANICAL & ELECTRICAL CONTRACTORS
P.O. BOX 12467
ROANOKE, VIRGINIA 24025
PHONE: 540-982-1873 FAX: 540-982-0655

PROJECT W.E. CUNDIFF ELEMENTARY SCHOOL ADDITIONS AND RENOVATIONS
ROANOKE COUNTY PUBLIC SCHOOLS
1200 HARDY RD
VINTON, VA
DRAWING PLUMBING SANITARY PLAN - FIRST FLOOR AREA A

SHEET
P-201


RRMM
ARCHITECTS, PC
28 Church Ave SW
Roanoke, Virginia 24011
(540)344-1212

DATE	03/22/2024	PROJECT	23125-01	DRY	DRY	DNL
DESIGNED		DRAWN		CHECKED		

ASCENT
ENGINEERING GROUP
5528 VALLEYPOINTE PKWY, SUITE 4
ROANOKE, VIRGINIA 24019
(540) 265-4444
D: DWR 23900 C: ---

REVISIONS	DATE	BY	DESCRIPTION

3/20/2024 4:13:31 PM Autodesk Docs\\23125-01 ROPS WE Condif ES\\23900 MEP Central v2.dwg

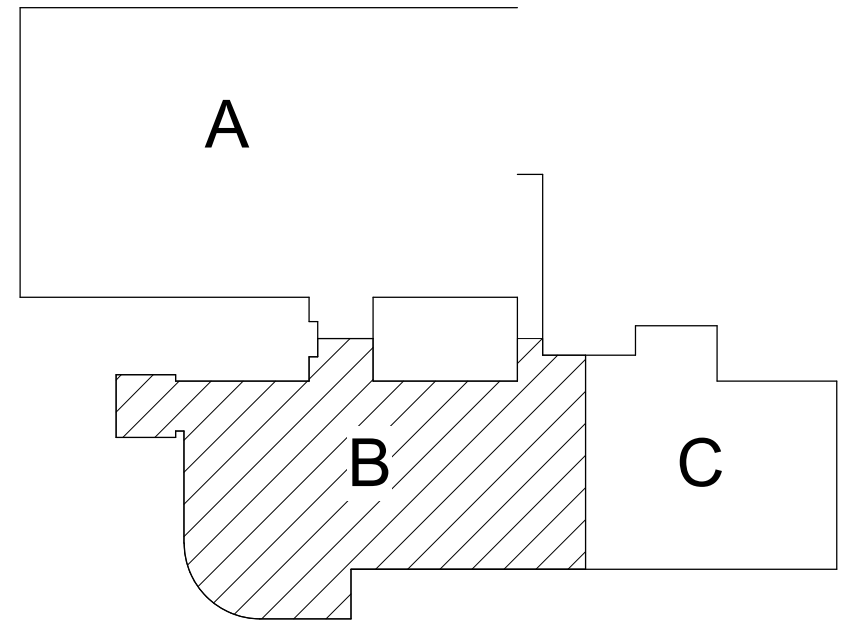

1 PLUMBING SANITARY PLAN - FIRST FLOOR AREA B
P-202 SCALE: 1/8" = 1'-0"



HOPKINS LACY
MECHANICAL & ELECTRICAL CONTRACTORS
P.O. BOX 12467
ROANOKE, VIRGINIA 24025
PHONE: 540-982-1873 FAX: 540-982-0655

PROJECT W.E. CUNDIFF ELEMENTARY SCHOOL ADDITIONS AND RENOVATIONS
ROANOKE COUNTY PUBLIC SCHOOLS
1200 HARDY RD
VINTON, VA
DRAWING PLUMBING SANITARY PLAN - FIRST FLOOR AREA B

SHEET
P-202



RRMM
ARCHITECTS, PC
28 Church Ave SW
Roanoke, Virginia 24011
(540)344-1212

DATE	03/22/2024	PROJECT	23125-01	DRY	DRY	DNL
DESIGNED		DRAWN		CHECKED		

ASCENT
ENGINEERING GROUP
5528 VALLEYPOINTE PKWY, SUITE 4
ROANOKE, VIRGINIA 24019
(540) 265-4444
D: DWR 23900 C: ---

MARK	DATE	BY	DESCRIPTION

3/20/2024 4:13:38 PM Autodesk Docs\\23125-01 ROPS WE Cusdiff ES\\23900 MEP Central v2.dwg

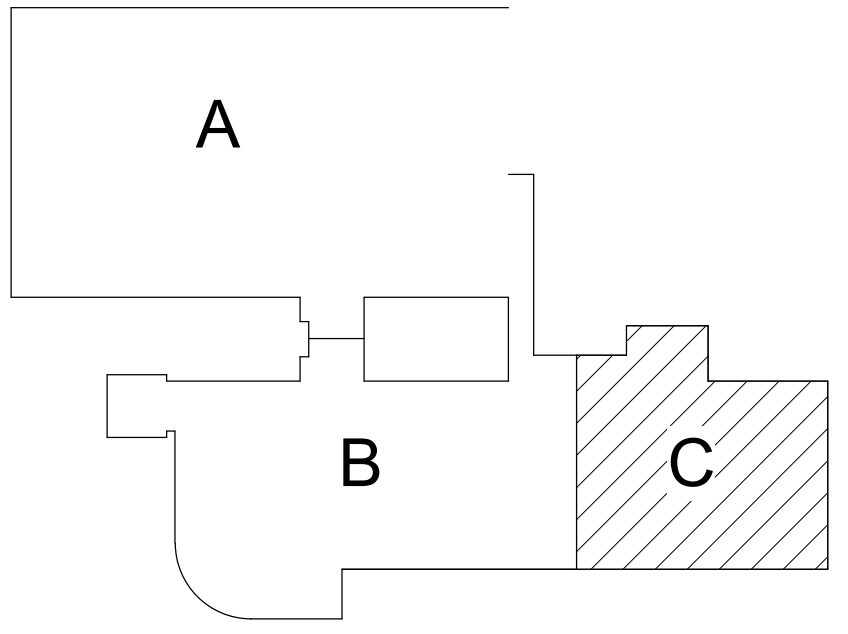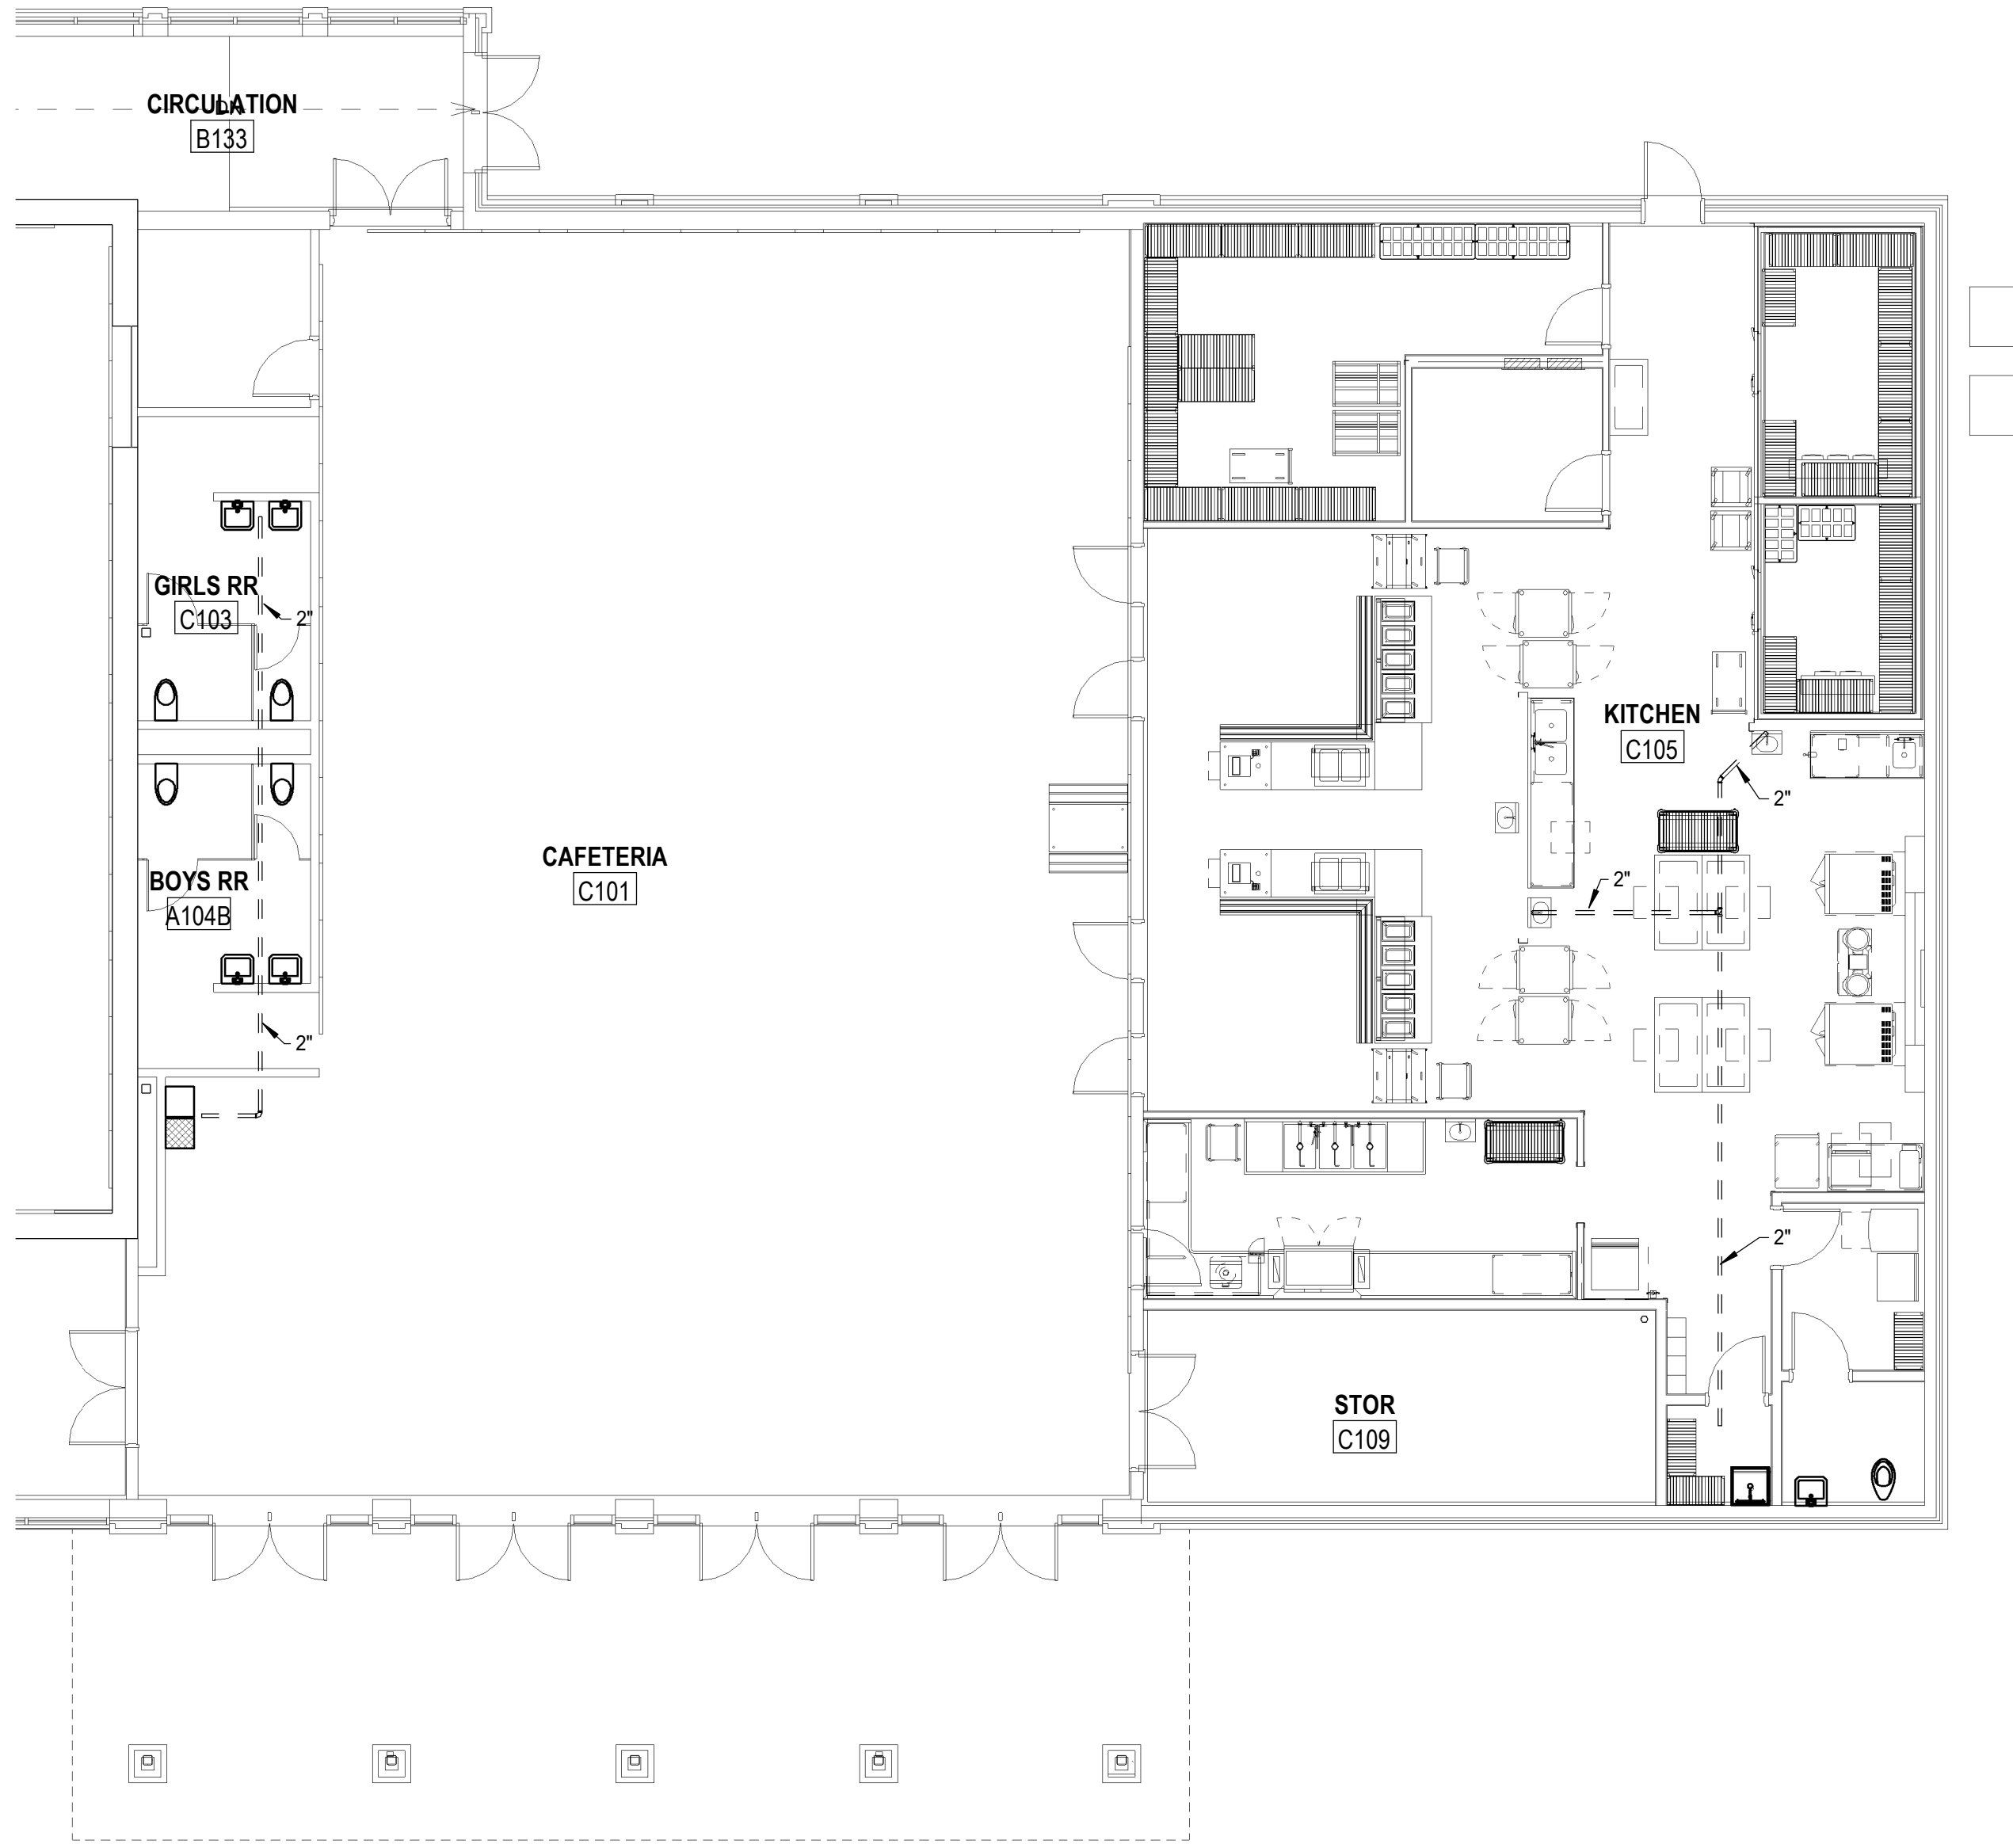

KEY PLAN AREA C
NOT TO SCALE

1
P-203 PLUMBING SANITARY PLAN - FIRST FLOOR AREA C
SCALE: 1/8" = 1'-0"



HOPKINS LACY
MECHANICAL & ELECTRICAL CONTRACTORS
P.O. BOX 12467
ROANOKE, VIRGINIA 24025
PHONE: 540-982-1873 FAX: 540-982-0655



PROJECT W.E. CUNDIFF ELEMENTARY SCHOOL ADDITIONS AND RENOVATIONS
ROANOKE COUNTY PUBLIC SCHOOLS
1200 HARDY RD
VINTON, VA
DRAWING PLUMBING SANITARY PLAN - FIRST FLOOR AREA C

SHEET
P-203

ASCENT
ENGINEERING GROUP
5228 VALLEYVIEW DRIVE, SUITE 4
ROANOKE, VIRGINIA 24019
(540) 265-4444
D: DWR 23900 C: ---


DATE	03/22/2024	PROJECT	23125-01	DRY	DRY	DNL
DESIGNED		DRAWN		CHECKED		

RRMM
ARCHITECTS, PC
28 Church Ave SW
Roanoke, Virginia 24011
(540) 344-1212



MARK	DATE	BY	DESCRIPTION

3/20/2024 4:13:45 PM Autodesk Docs/1/23/25-01 RCPS WE Condif ES/23900 MEP Central v2L.dwg

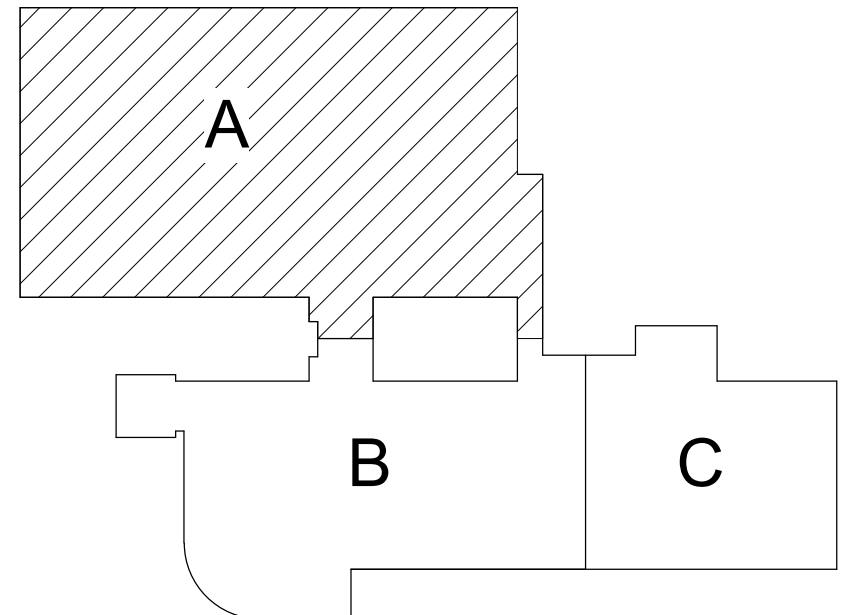

KEY PLAN AREA A
NOT TO SCALE

1 PLUMBING SANITARY PLAN - SECOND FLOOR AREA A
SCALE: 1/8" = 1'-0"



HOPKINS LACY
MECHANICAL & ELECTRICAL CONTRACTORS
P.O. BOX 12467
ROANOKE, VIRGINIA 24025
PHONE: 540-982-1873 FAX: 540-982-0655

PROJECT W.E. CUNDIFF ELEMENTARY SCHOOL ADDITIONS AND RENOVATIONS
ROANOKE COUNTY PUBLIC SCHOOLS
1200 HARDY RD
VINTON, VA
DRAWING PLUMBING SANITARY PLAN - SECOND FLOOR AREA A

SHEET

P-204

NOT FOR CONSTRUCTION



RRMM
ARCHITECTS, PC
28 Church Ave SW
Roanoke, Virginia 24011
(540)344-1212

DATE 03/22/2024
PROJECT 23125-01
DESIGNED DRV
DRAWN DRV
CHECKED DNL

ASCENT
ENGINEERING GROUP
5528 VALLEYVIEW DRIVE, SUITE 4
ROANOKE, VIRGINIA 24019
(540) 265-4444
D/DWR 23900 C: ---

DESCRIPTION
BY
MARK DATE
REVISIONS

3/20/2024 4:13:53 PM Autodesk Docs/1/23/25-01 ROPS WE Condif ES/23900 MEP Central v2.dwg

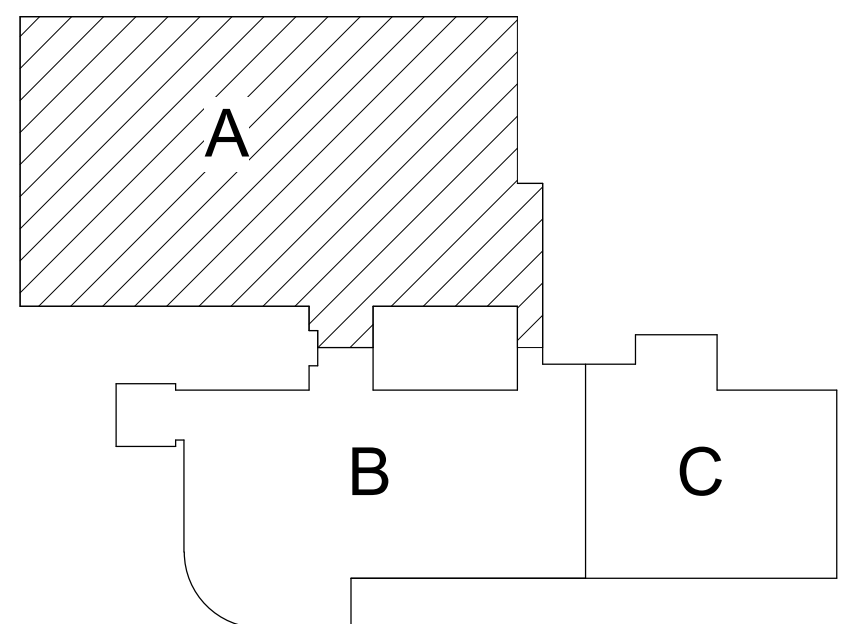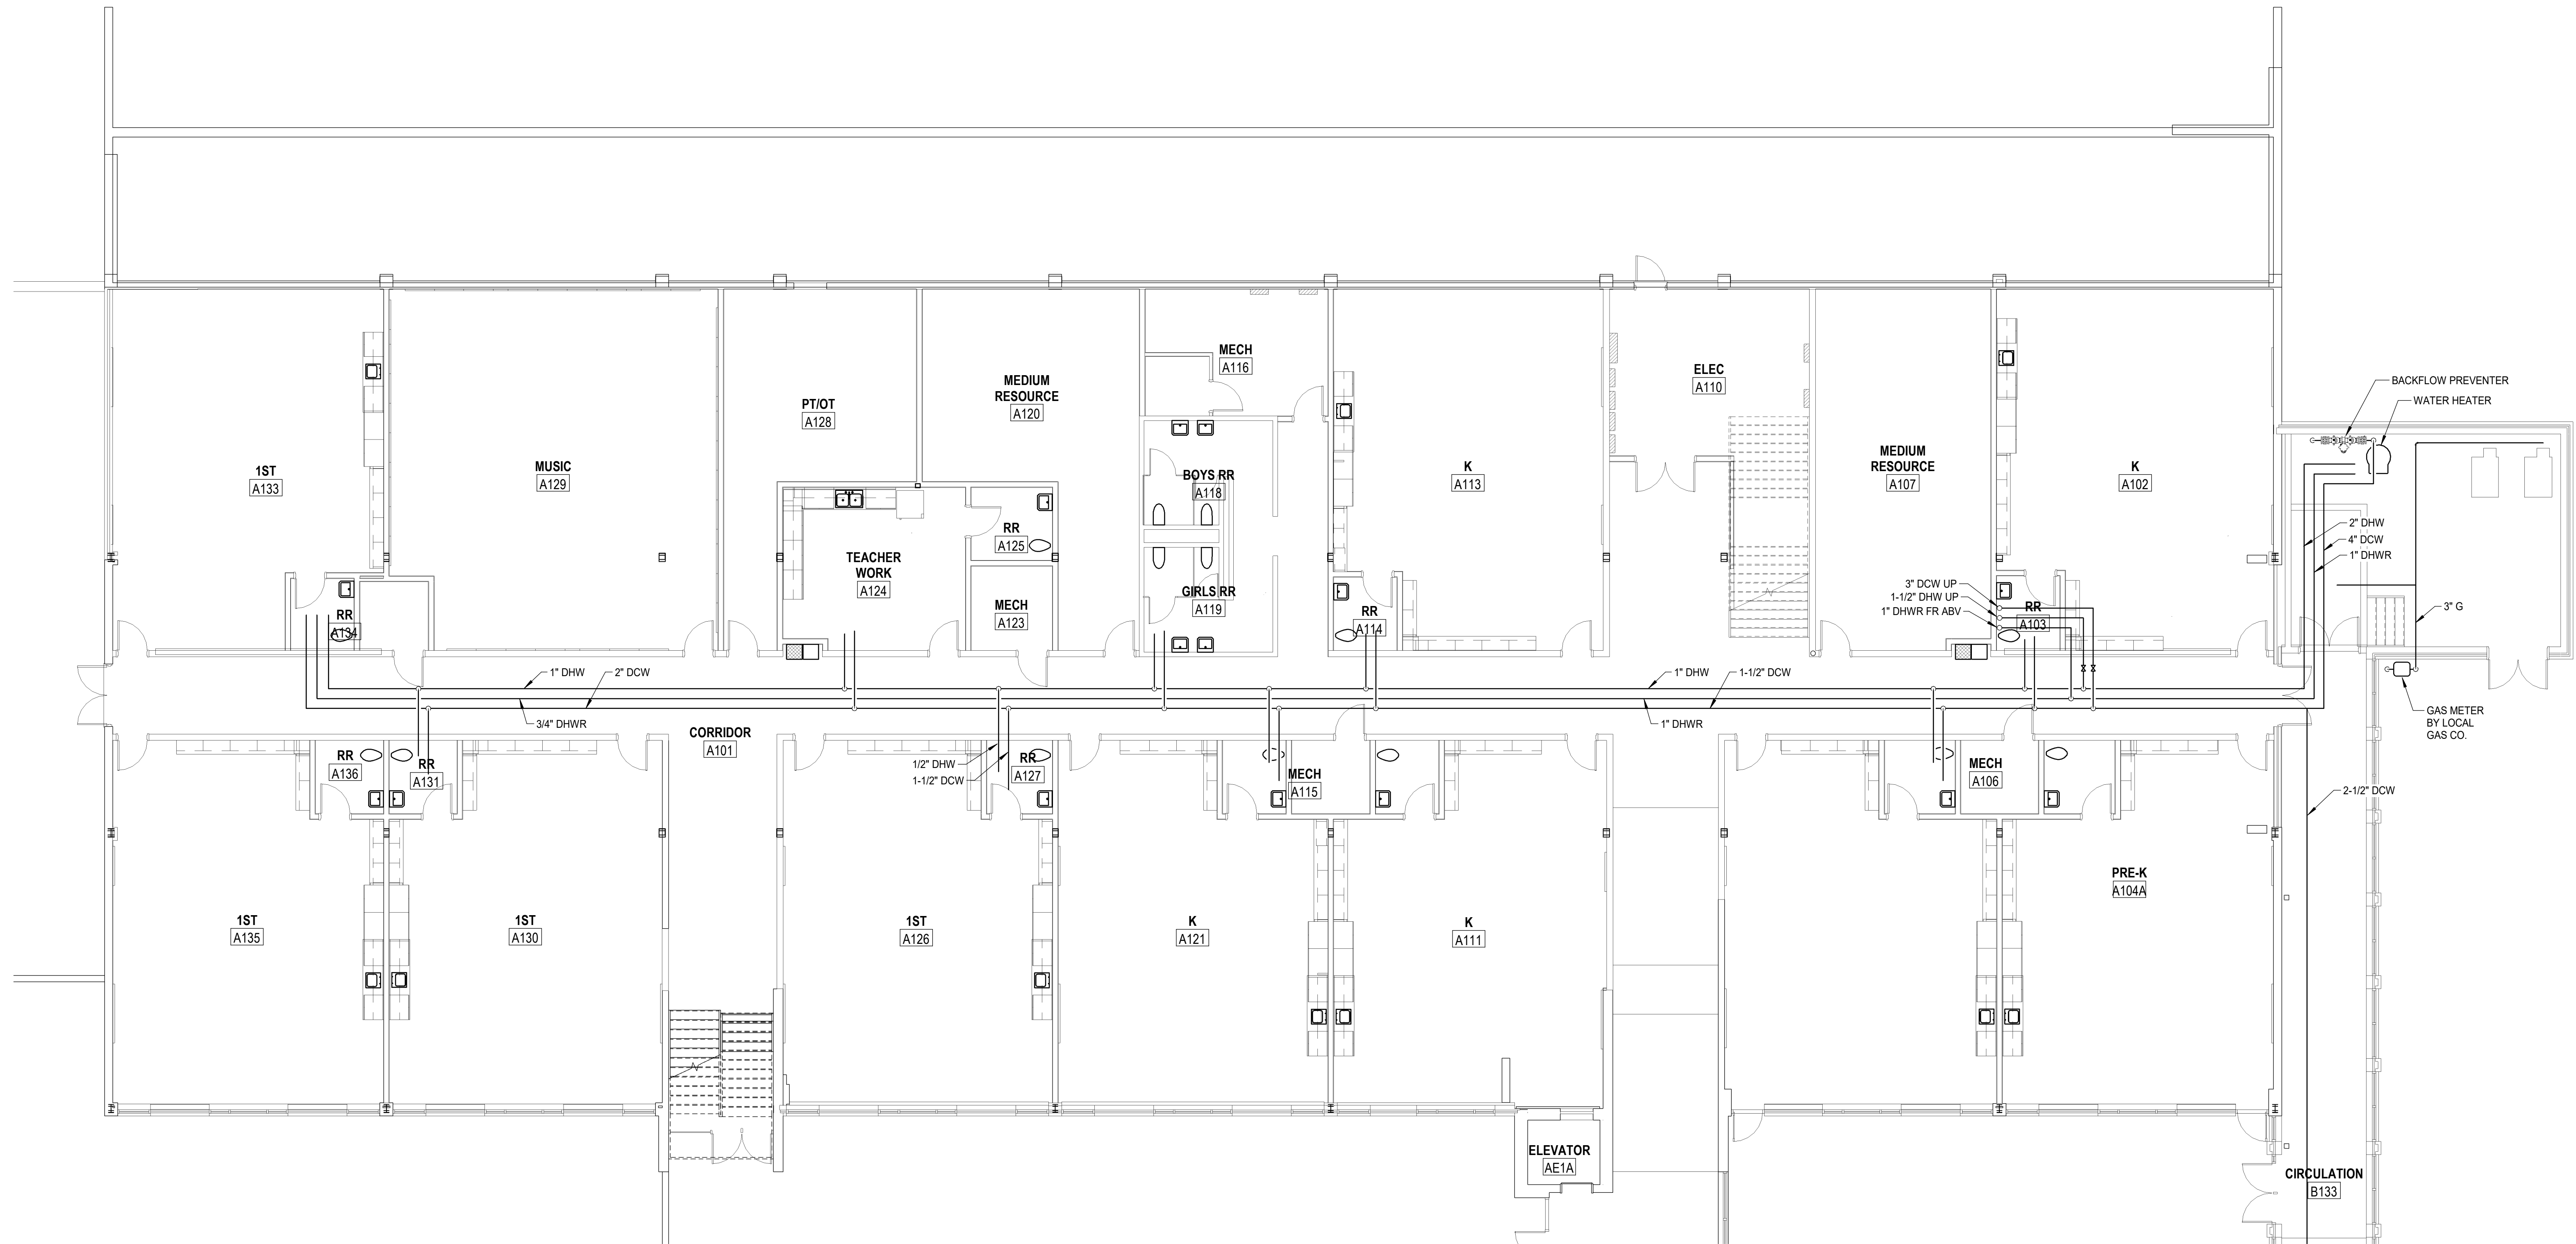

1 PLUMBING DOMESTIC WATER PLAN - FIRST FLOOR AREA A
P-301 SCALE: 1/8" = 1'-0"



HOPKINS LACY
MECHANICAL & ELECTRICAL CONTRACTORS
P.O. BOX 12467
ROANOKE, VIRGINIA 24025
PHONE: 540-982-1873 FAX: 540-982-0655

PROJECT W.E. CUNDIFF ELEMENTARY SCHOOL ADDITIONS AND RENOVATIONS
ROANOKE COUNTY PUBLIC SCHOOLS
1200 HARDY RD
VINTON, VA
DRAWING PLUMBING DOMESTIC WATER PLAN - FIRST FLOOR
AREA A

SHEET

P-301

RRMM
ARCHITECTS, PC
28 Church Ave SW
Roanoke, Virginia 24011
(540)344-1212

NOT FOR CONSTRUCTION

DATE 03/22/2024
PROJECT 23125-01
DESIGNED DRV
DRAWN DRV
CHECKED DNL

ASCENT
ENGINEERING GROUP
5528 VALLEYPOINTE PKWY, SUITE 4
ROANOKE, VIRGINIA 24019
(540) 265-4444
D:DWR 23900 C: ---

DESCRIPTION
BY
MARK DATE
REVISIONS

3/20/2024 4:13:59 PM Autodesk Docs/123125-01 RCPS WE Condif ES/23900 MEP Central v2.dwg



E

D

C

B

A

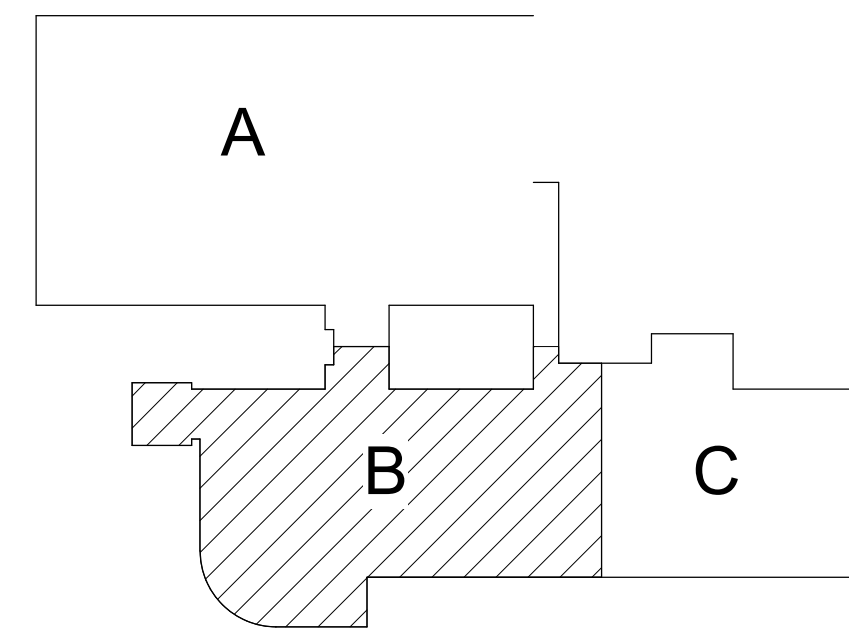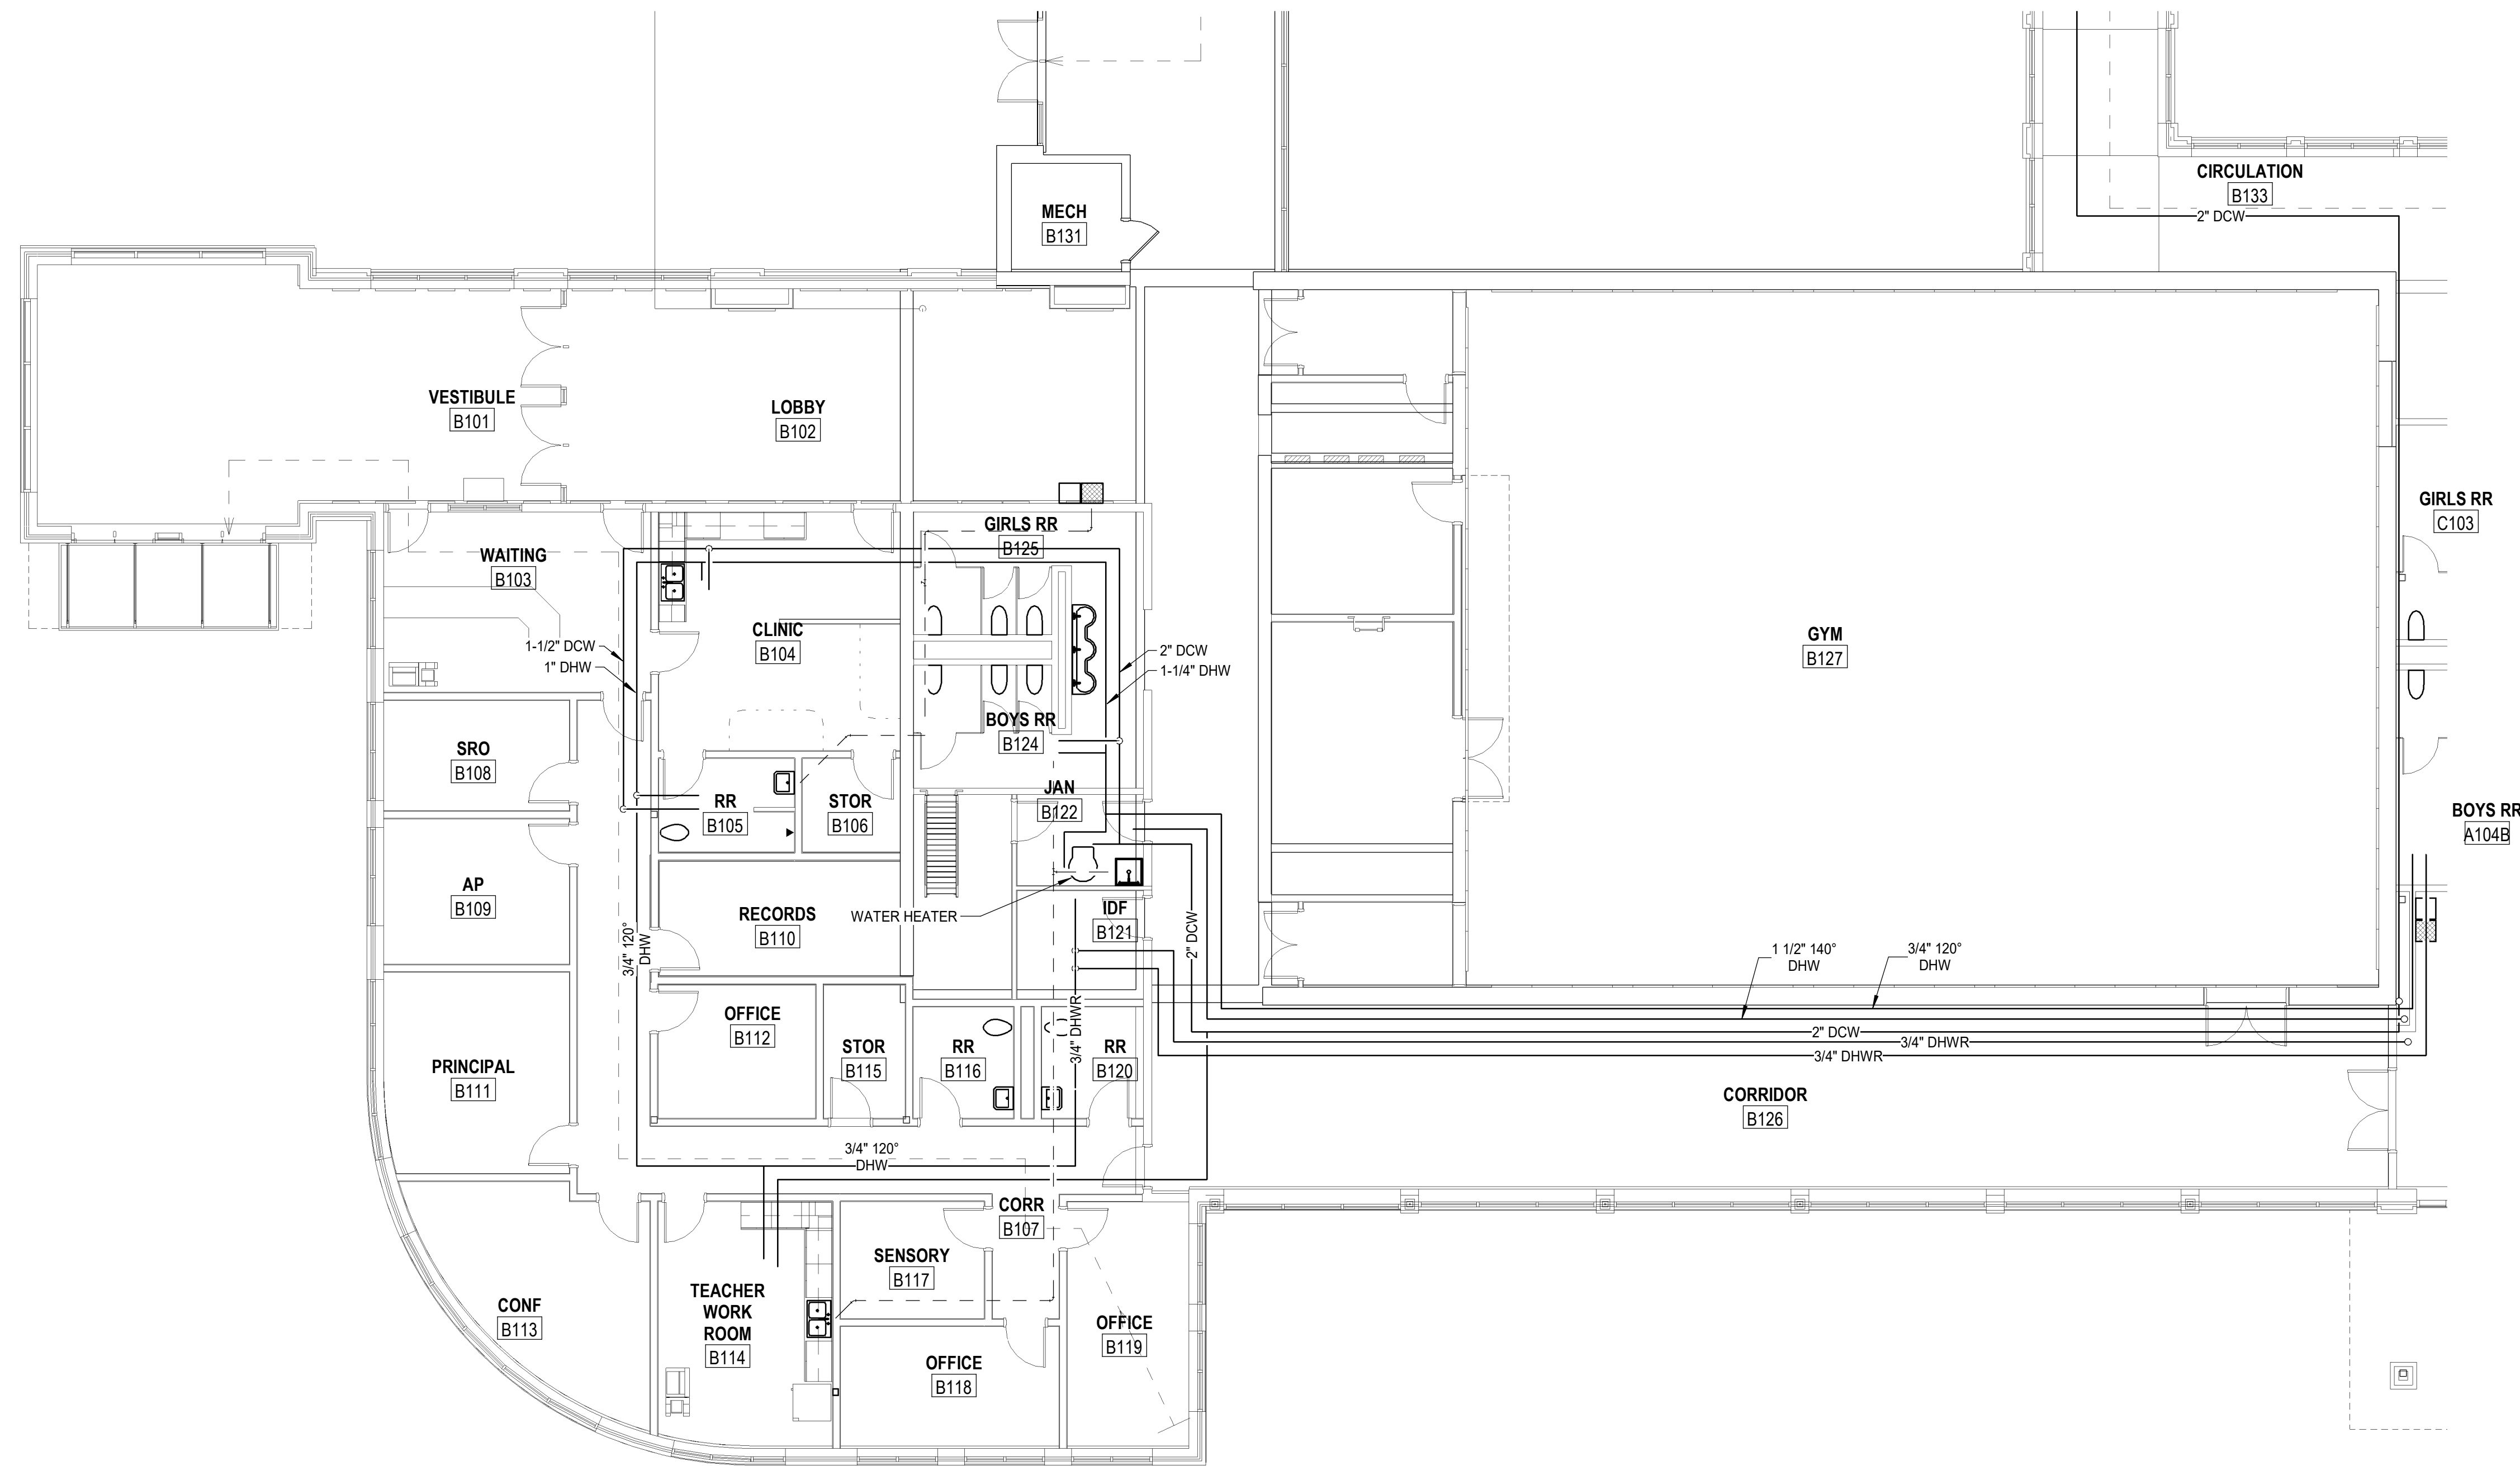

KEY PLAN AREA B
NOT TO SCALE

1
P-302 PLUMBING DOMESTIC WATER PLAN - FIRST FLOOR AREA B
SCALE: 1/8" = 1'-0"



HOPKINS LACY
MECHANICAL & ELECTRICAL CONTRACTORS
P.O. BOX 12467
ROANOKE, VIRGINIA 24025
PHONE: 540-982-1873 FAX: 540-982-0655

PROJECT W.E. CUNDIFF ELEMENTARY SCHOOL ADDITIONS AND RENOVATIONS
ROANOKE COUNTY PUBLIC SCHOOLS
1200 HARDY RD
VINTON, VA
DRAWING PLUMBING DOMESTIC WATER PLAN - FIRST FLOOR
AREA B

SHEET
P-302

ASCENT
ENGINEERING GROUP
5528 VALLEYVIEW DRIVE, SUITE 4
ROANOKE, VIRGINIA 24019
(540) 265-4444
D.DWR 23900 C. ---

DATE 03/22/2024
PROJECT 23125-01
DESIGNED DRV
DRAWN DRV
CHECKED DNL

RRMM
ARCHITECTS, PC
28 Church Ave SW
Roanoke, Virginia 24011
(540) 344-1212

NOT FOR CONSTRUCTION

REVISIONS
MARK DATE BY DESCRIPTION

3/20/2024 4:14:04 PM Autodesk Docs\\23125-01 ROPS WE Cusdiff ES23900 MEP Central v2.dwg



E

D

C

B

A

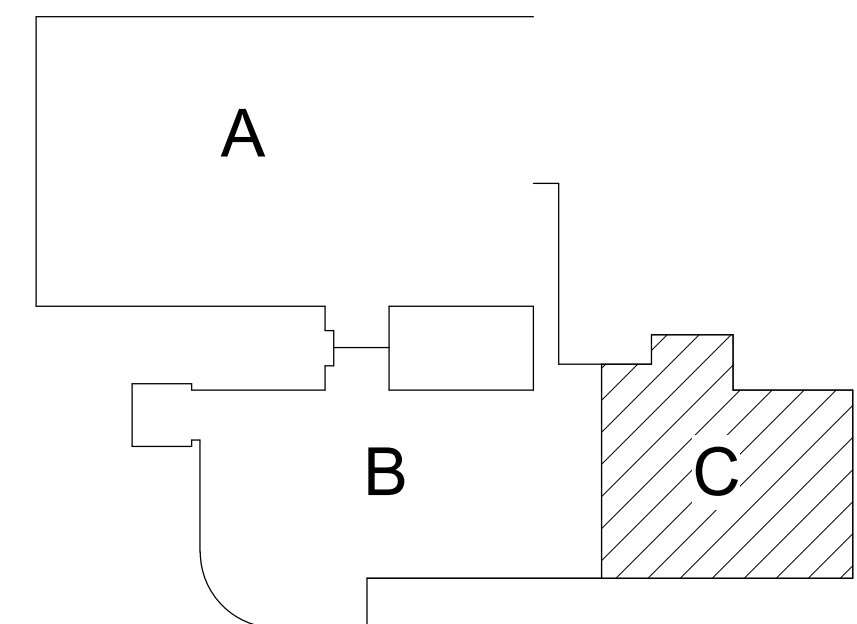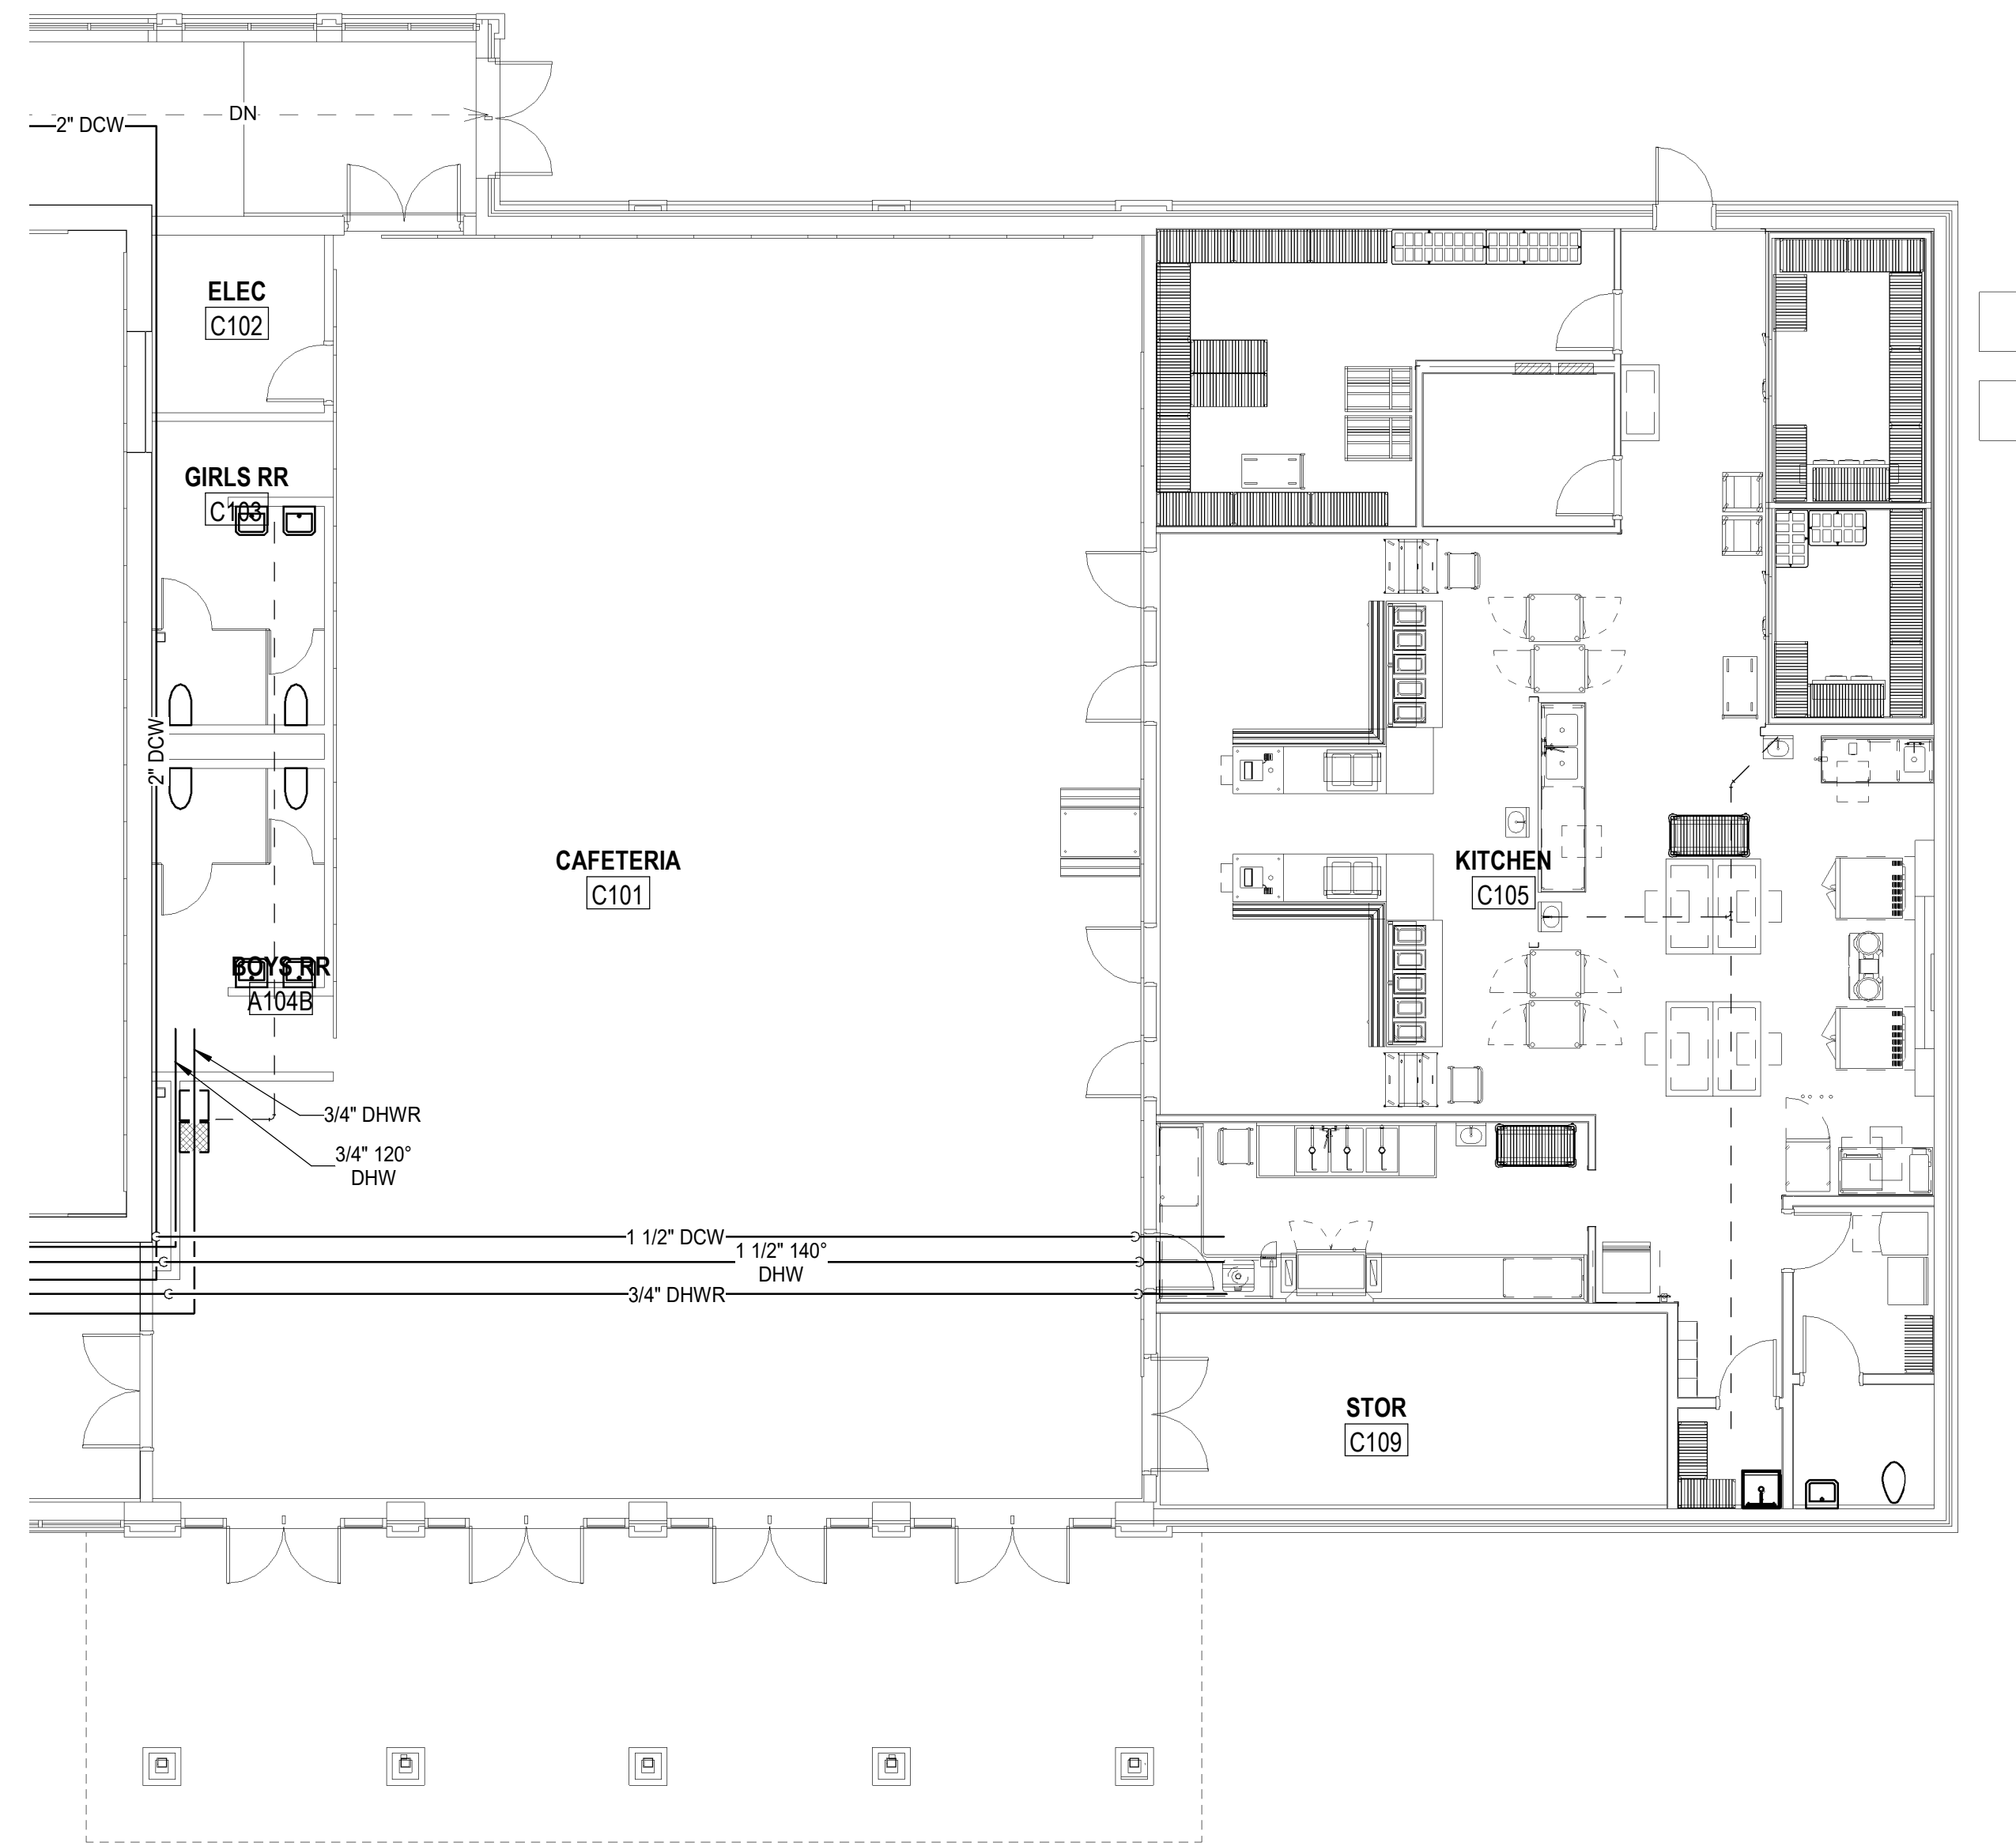

KEY PLAN AREA C

NOT TO SCALE


1 PLUMBING DOMESTIC WATER PLAN - FIRST FLOOR AREA C
P-303 SCALE: 1/8" = 1'-0"



HOPKINS LACY
MECHANICAL & ELECTRICAL CONTRACTORS
P.O. BOX 12467
ROANOKE, VIRGINIA 24025
PHONE: 540-982-1873 FAX: 540-982-0655

PROJECT W.E. CUNDIFF ELEMENTARY SCHOOL ADDITIONS AND RENOVATIONS
ROANOKE COUNTY PUBLIC SCHOOLS
1200 HARDY RD
VINTON, VA
DRAWING PLUMBING DOMESTIC WATER PLAN - FIRST FLOOR
AREA C

SHEET
P-303

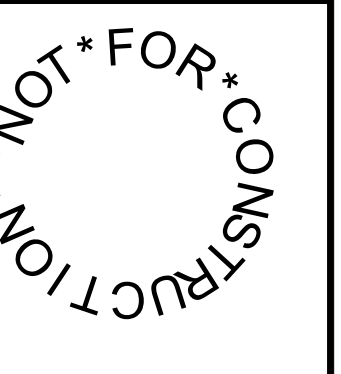

RRMM
ARCHITECTS, PC
28 Church Ave SW
Roanoke, Virginia 24011
(540)344-1212





DATE 03/22/2024
PROJECT 23125-01
DESIGNED DRV
DRAWN DRV
CHECKED DNL

ASCENT
ENGINEERING GROUP
5228 VALLEYPONTE PKWY, SUITE 4
ROANOKE, VIRGINIA 24019
(540) 265-4444
D.DWR 23900 C: ---


MARK	DATE	BY	DESCRIPTION

3/20/2024 4:14:13 PM Autodesk Docs\\123125-01 ROPS WE Condif ES\\23900 MEP Central v2.dwg

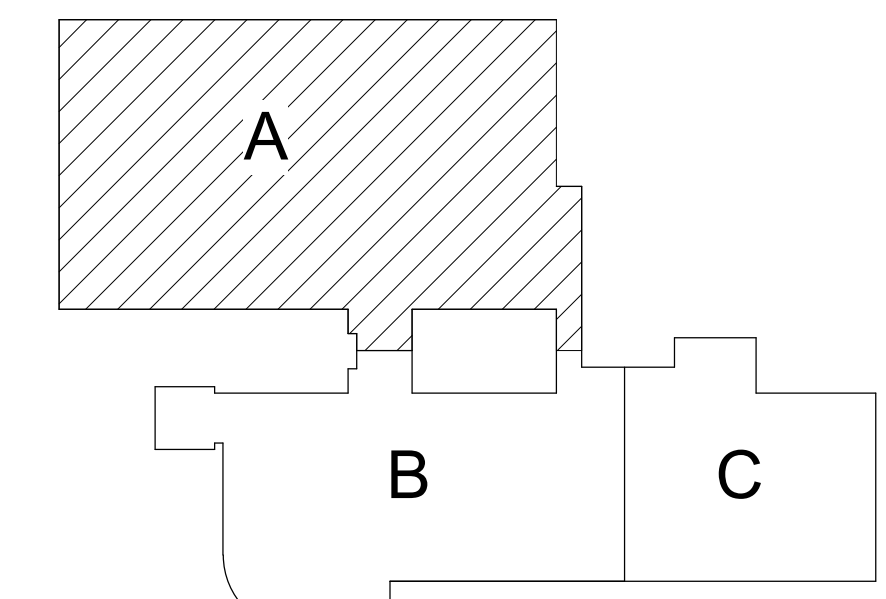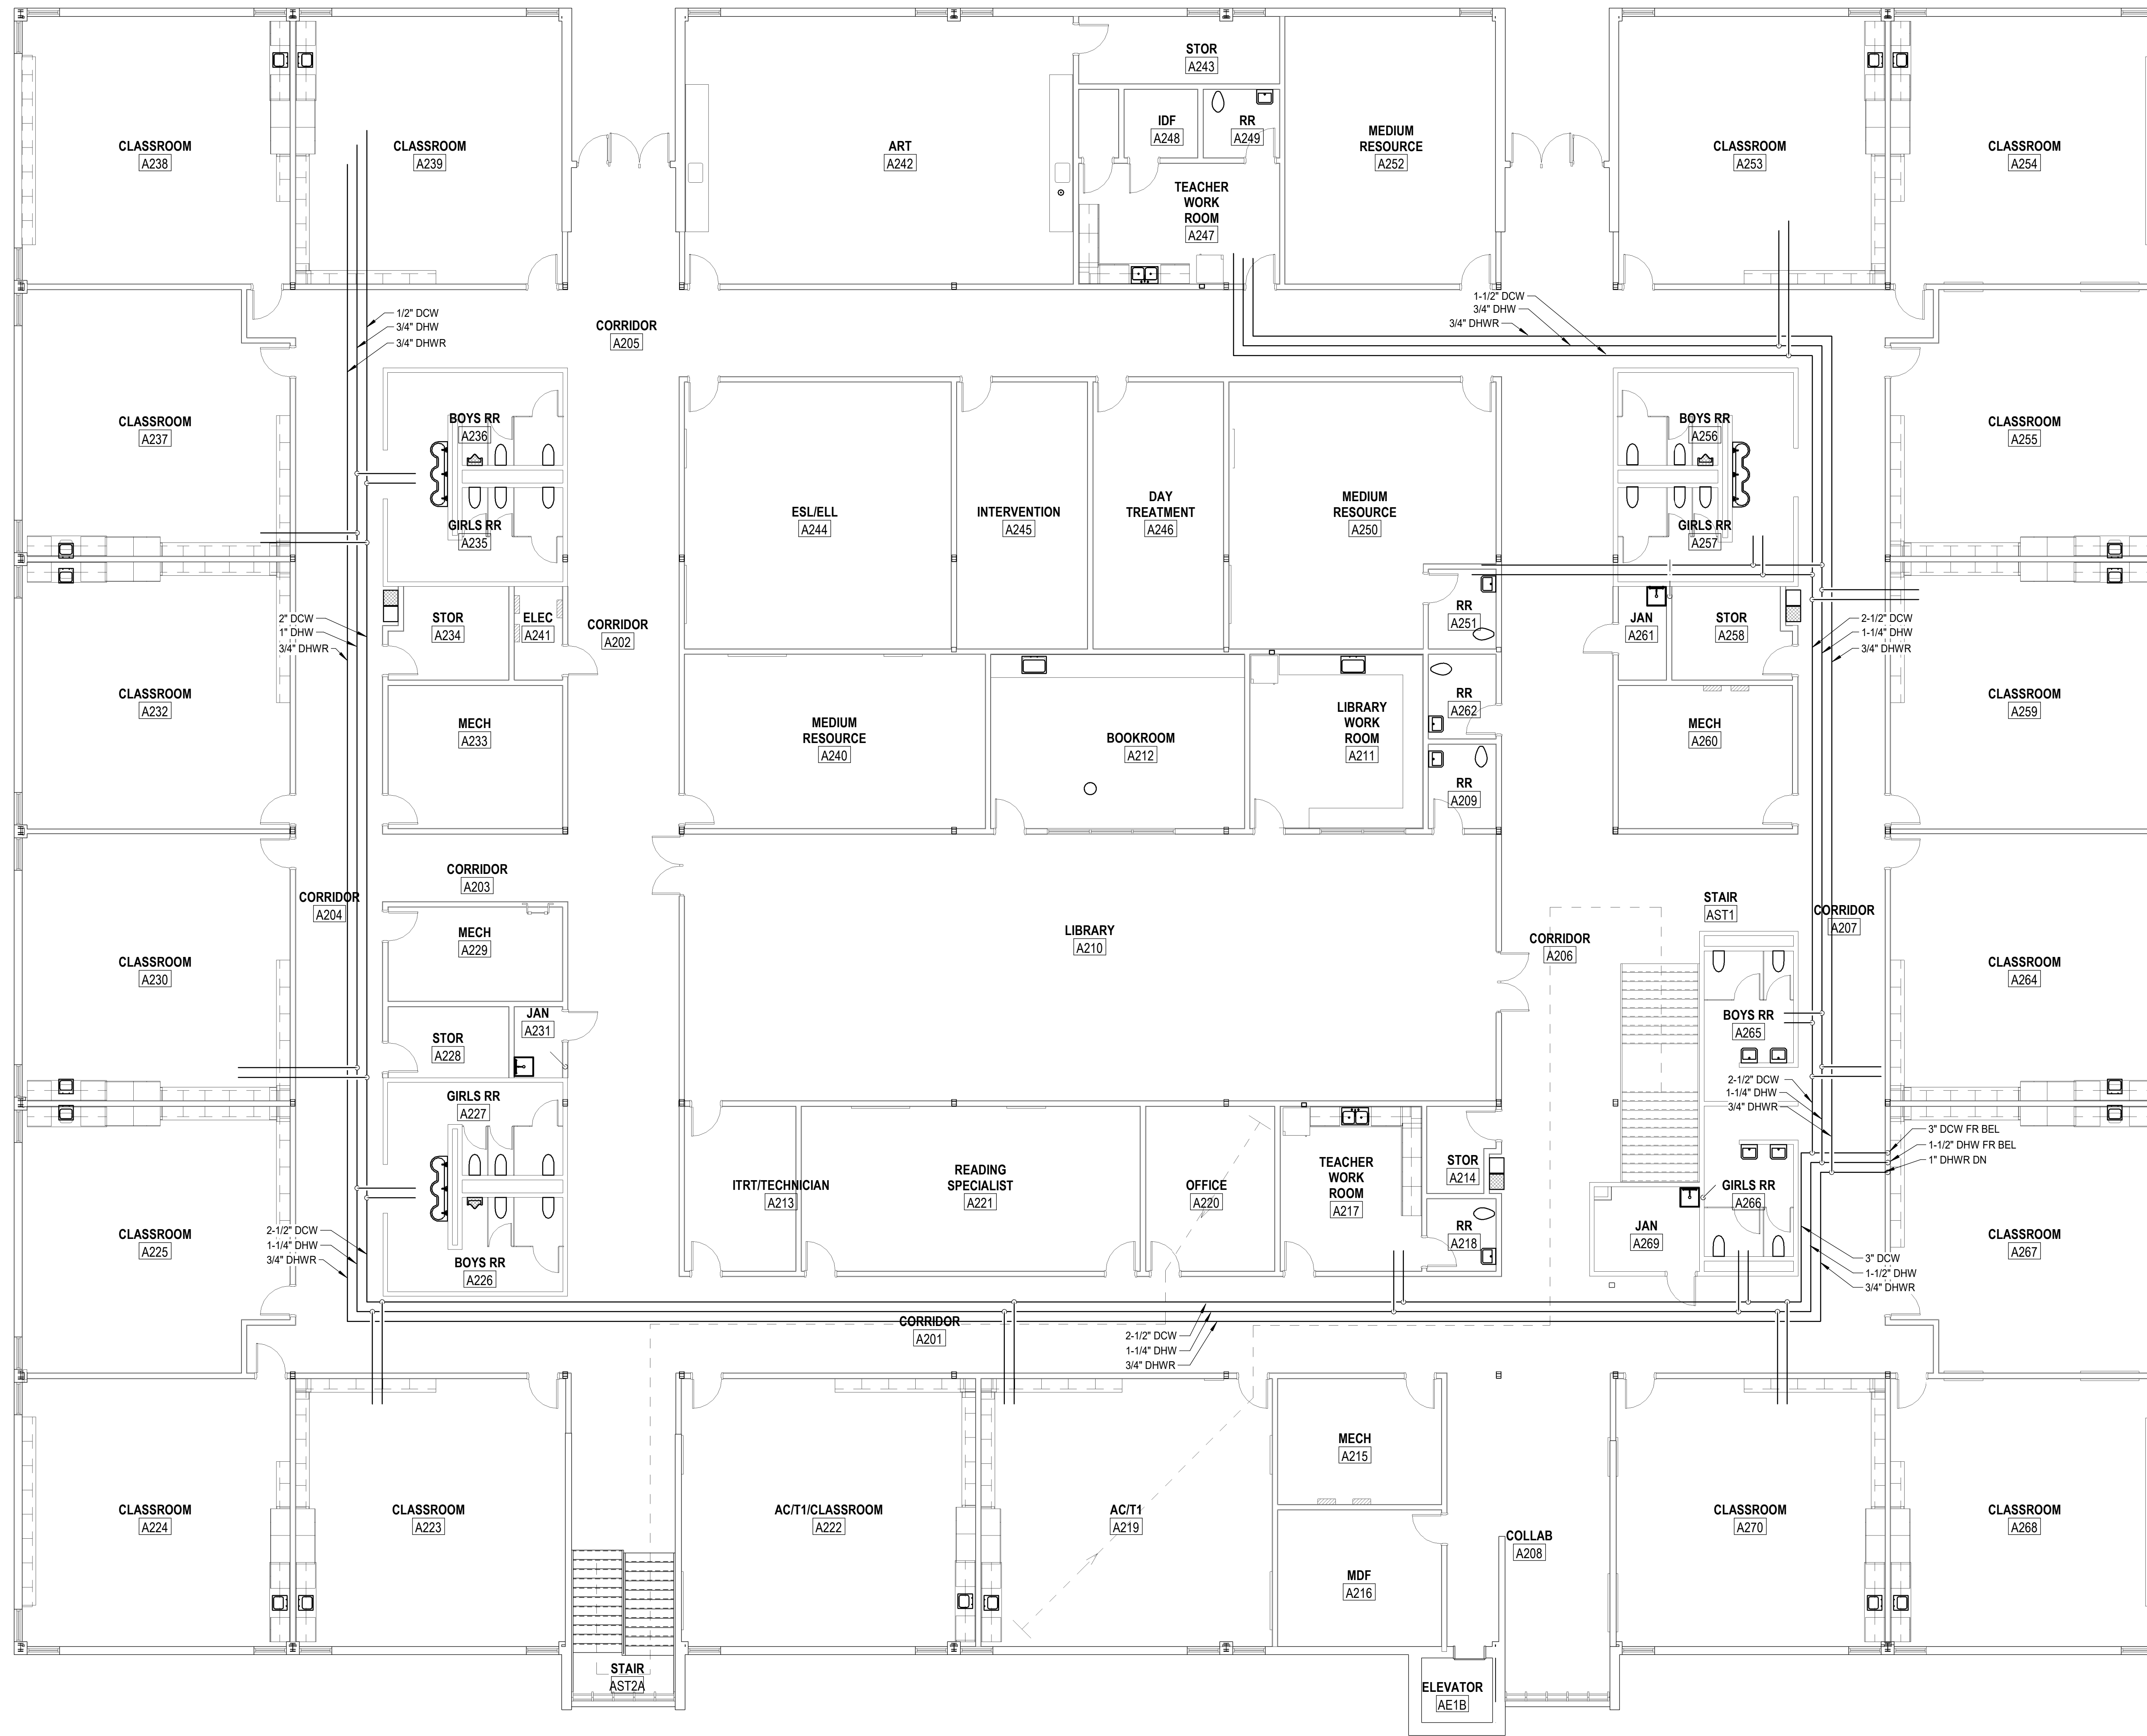

KEY PLAN AREA A
NOT TO SCALE

 1 PLUMBING DOMESTIC WATER PLAN - SECOND FLOOR AREA A
P-304 SCALE: 1/8" = 1'-0"



MARK	DATE	DESCRIPTION
BY		
REVISIONS		

ASCENT
ENGINEERING GROUP
5528 VALLEYFONTE PKWY, SUITE 4
ROANOKE, VIRGINIA 24019
(540) 265-4444
D: DWR 23900 C: ---

DATE	03/22/2024	PROJECT	23125-01	DRY	DRY	DNL
DESIGNED		DRAWN		CHECKED		

RRMM
ARCHITECTS, PC
28 Church Ave SW
Roanoke, Virginia 24011
(540) 344-1212

NOT FOR CONSTRUCTION

PROJECT W.E. CUNDIFF ELEMENTARY SCHOOL ADDITIONS AND RENOVATIONS
ROANOKE COUNTY PUBLIC SCHOOLS
1200 HARDY RD
VINTON, VA
DRAWING PLUMBING DOMESTIC WATER PLAN - SECOND FLOOR
AREA A

SHEET
P-304

GH
HOPKINS LACY
MECHANICAL & ELECTRICAL CONTRACTORS
P.O. BOX 12467
ROANOKE, VIRGINIA 24025
PHONE: 540-982-1873 FAX: 540-982-0655